


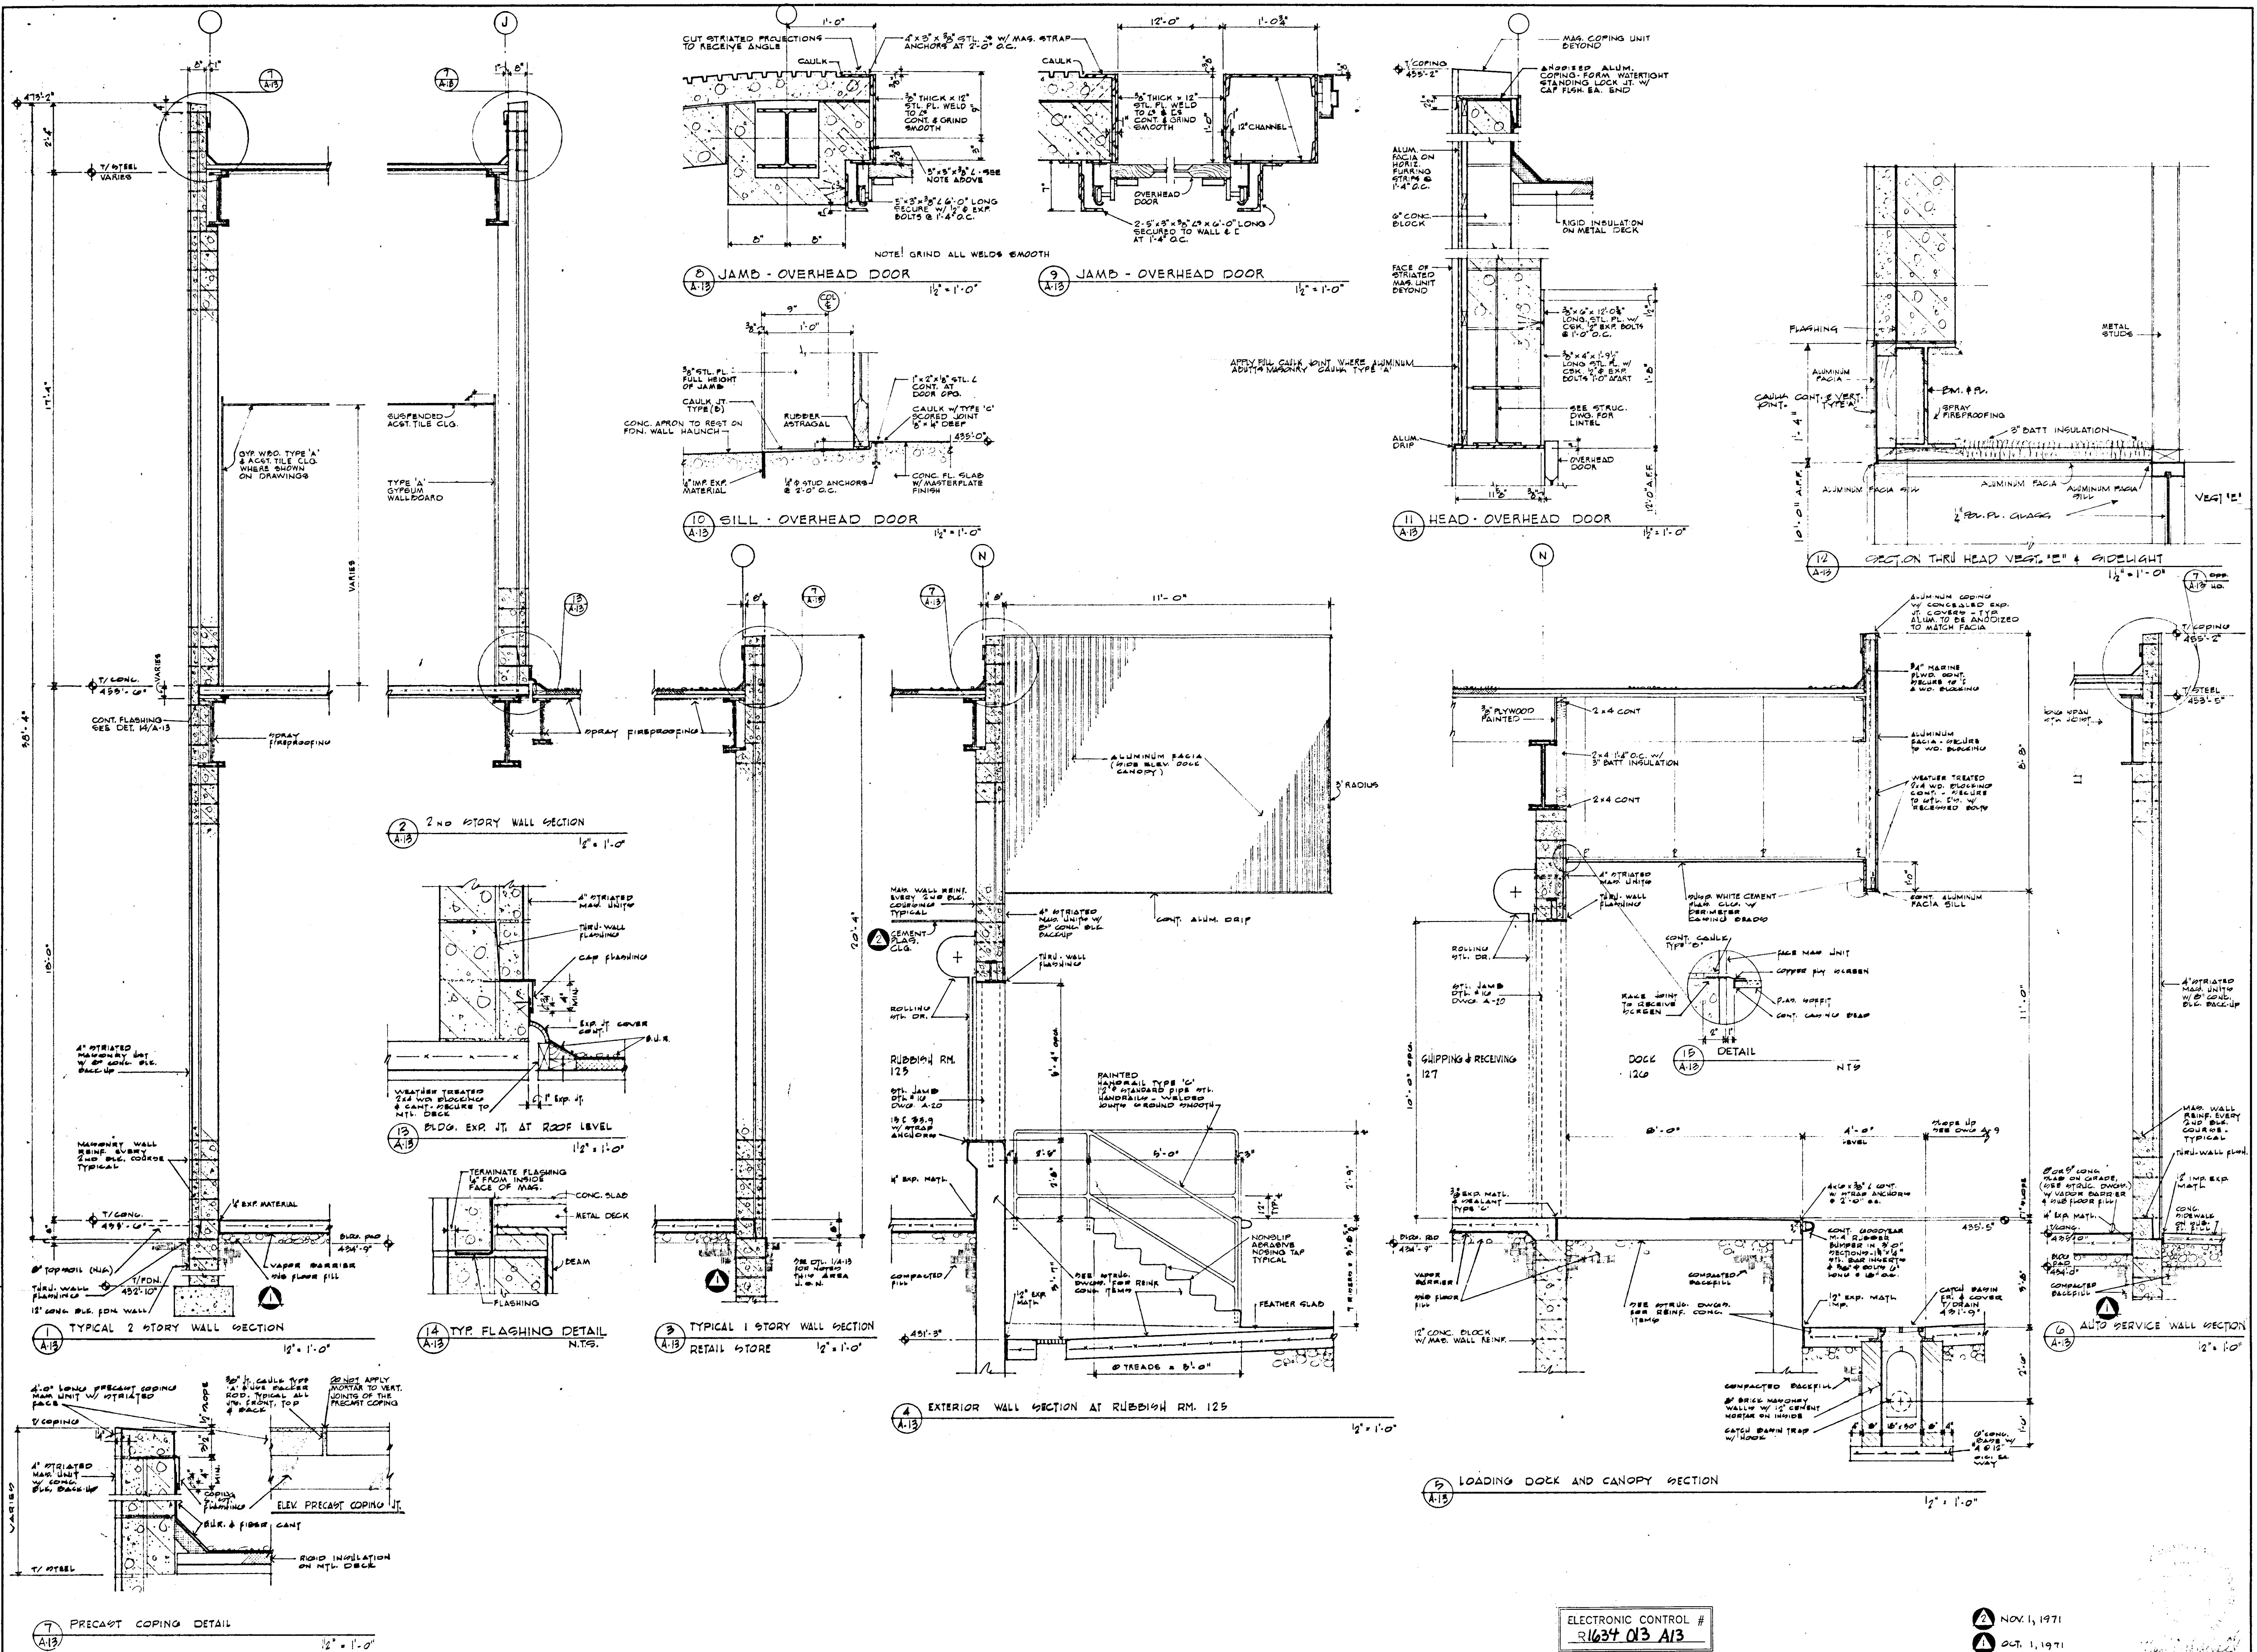

ELECTRONIC CONTROL #
R1634 Q13 A13

NOV. 1, 1971
OCT. 1, 1971

WALL SECTIONS and DETAILS
RETAIL STORE and 23 CAR AUTO SERVICE
SEARS ROEBUCK & COMPANY
SECURITY SQUARE - BALTIMORE WEST, MARYLAND

SCALE: AS NOTED
DATE: AUG. 16, 1971
REVISED

DRAWING NUMBER
A-13

ABM

ALLAN B. MITCHELL and ASSOCIATES ARCHITECTS PITTSBURGH, PA.