



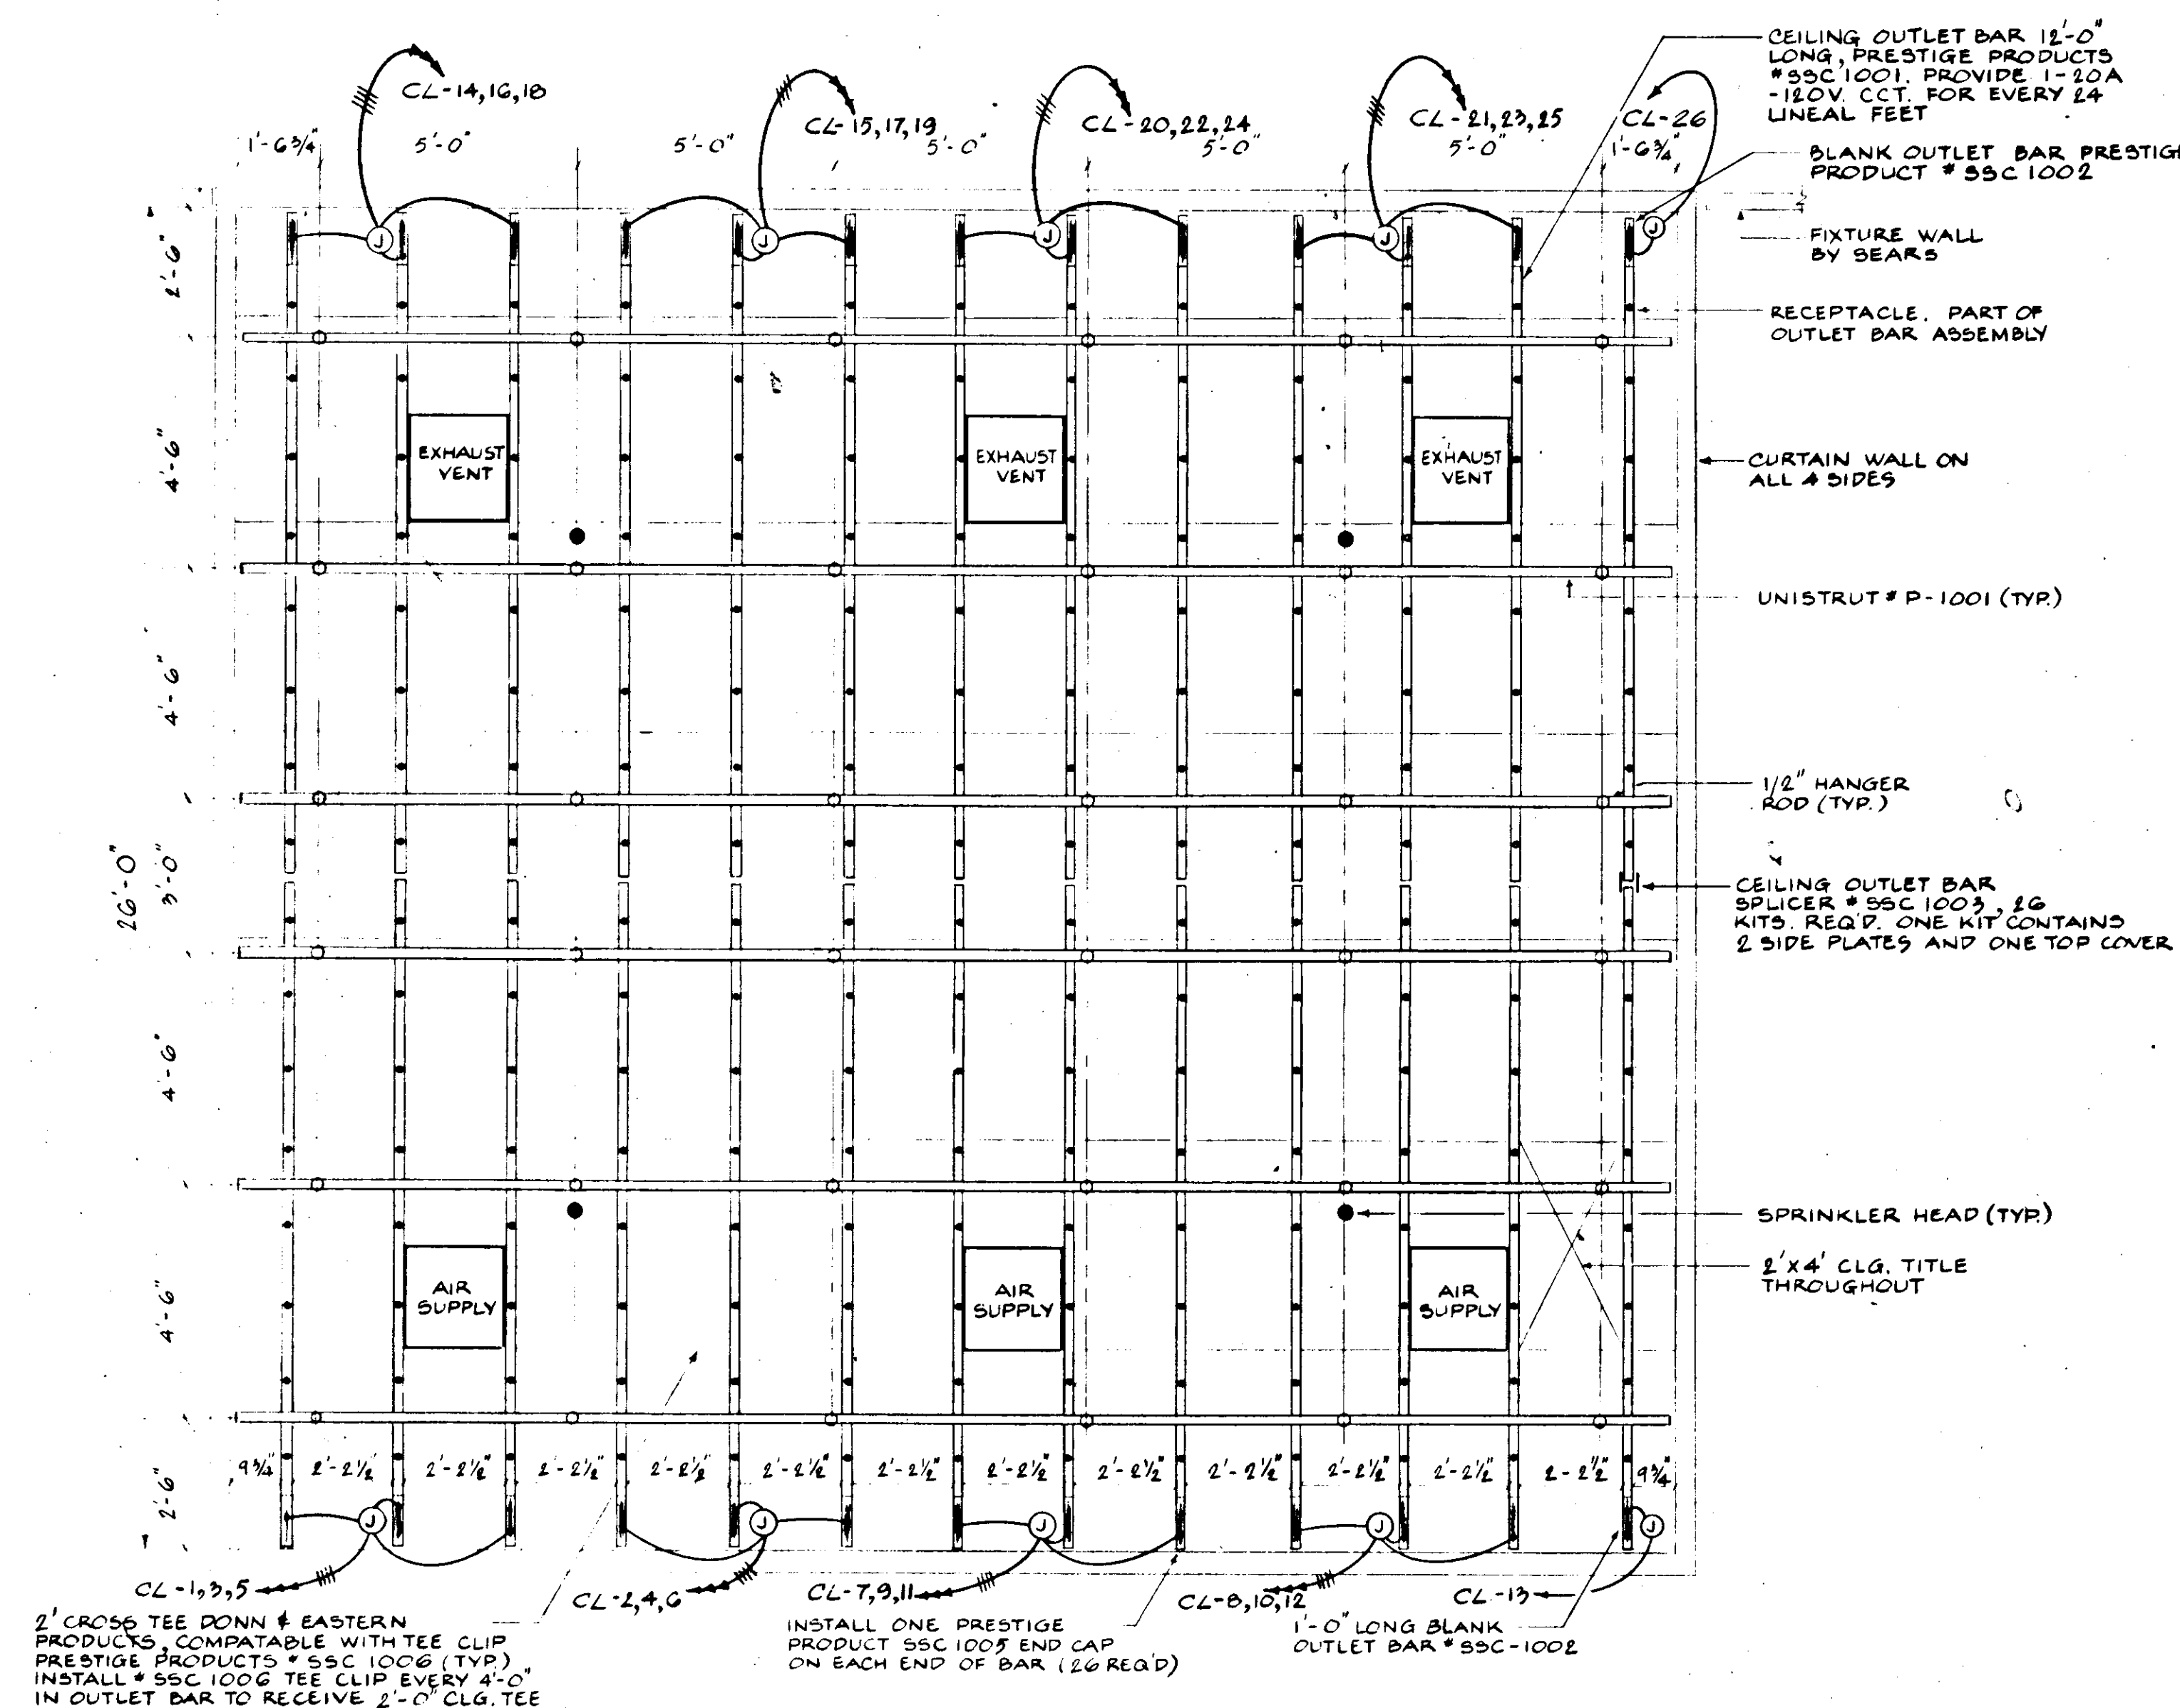


PLAN VIEW
SCALE: 3/8" = 1'-0"


- NOTES
1. ALL ELBET. SHALL BE FURNISHED BY SEARS, INSTALLED BY ELEC. CONTRACTOR.
 2. REFER TO DWG. E-2 FOR LOCATION.

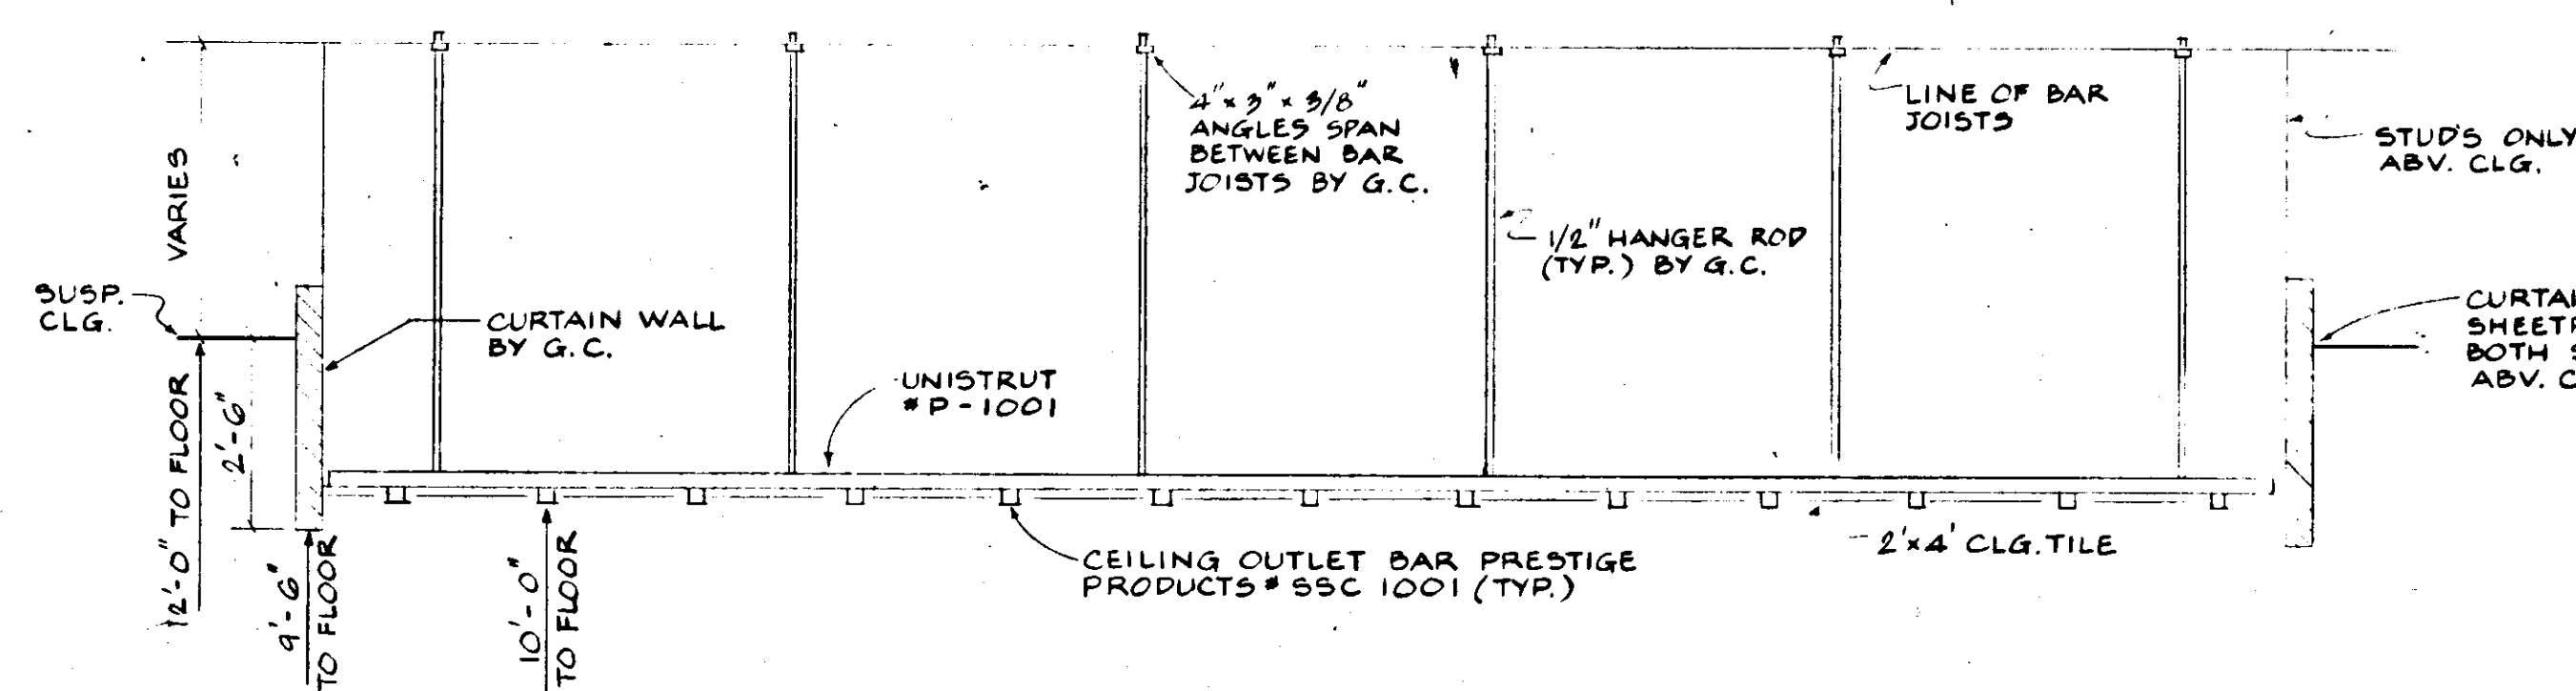

SECTION A-A'
SCALE: 3/8" = 1'-0"



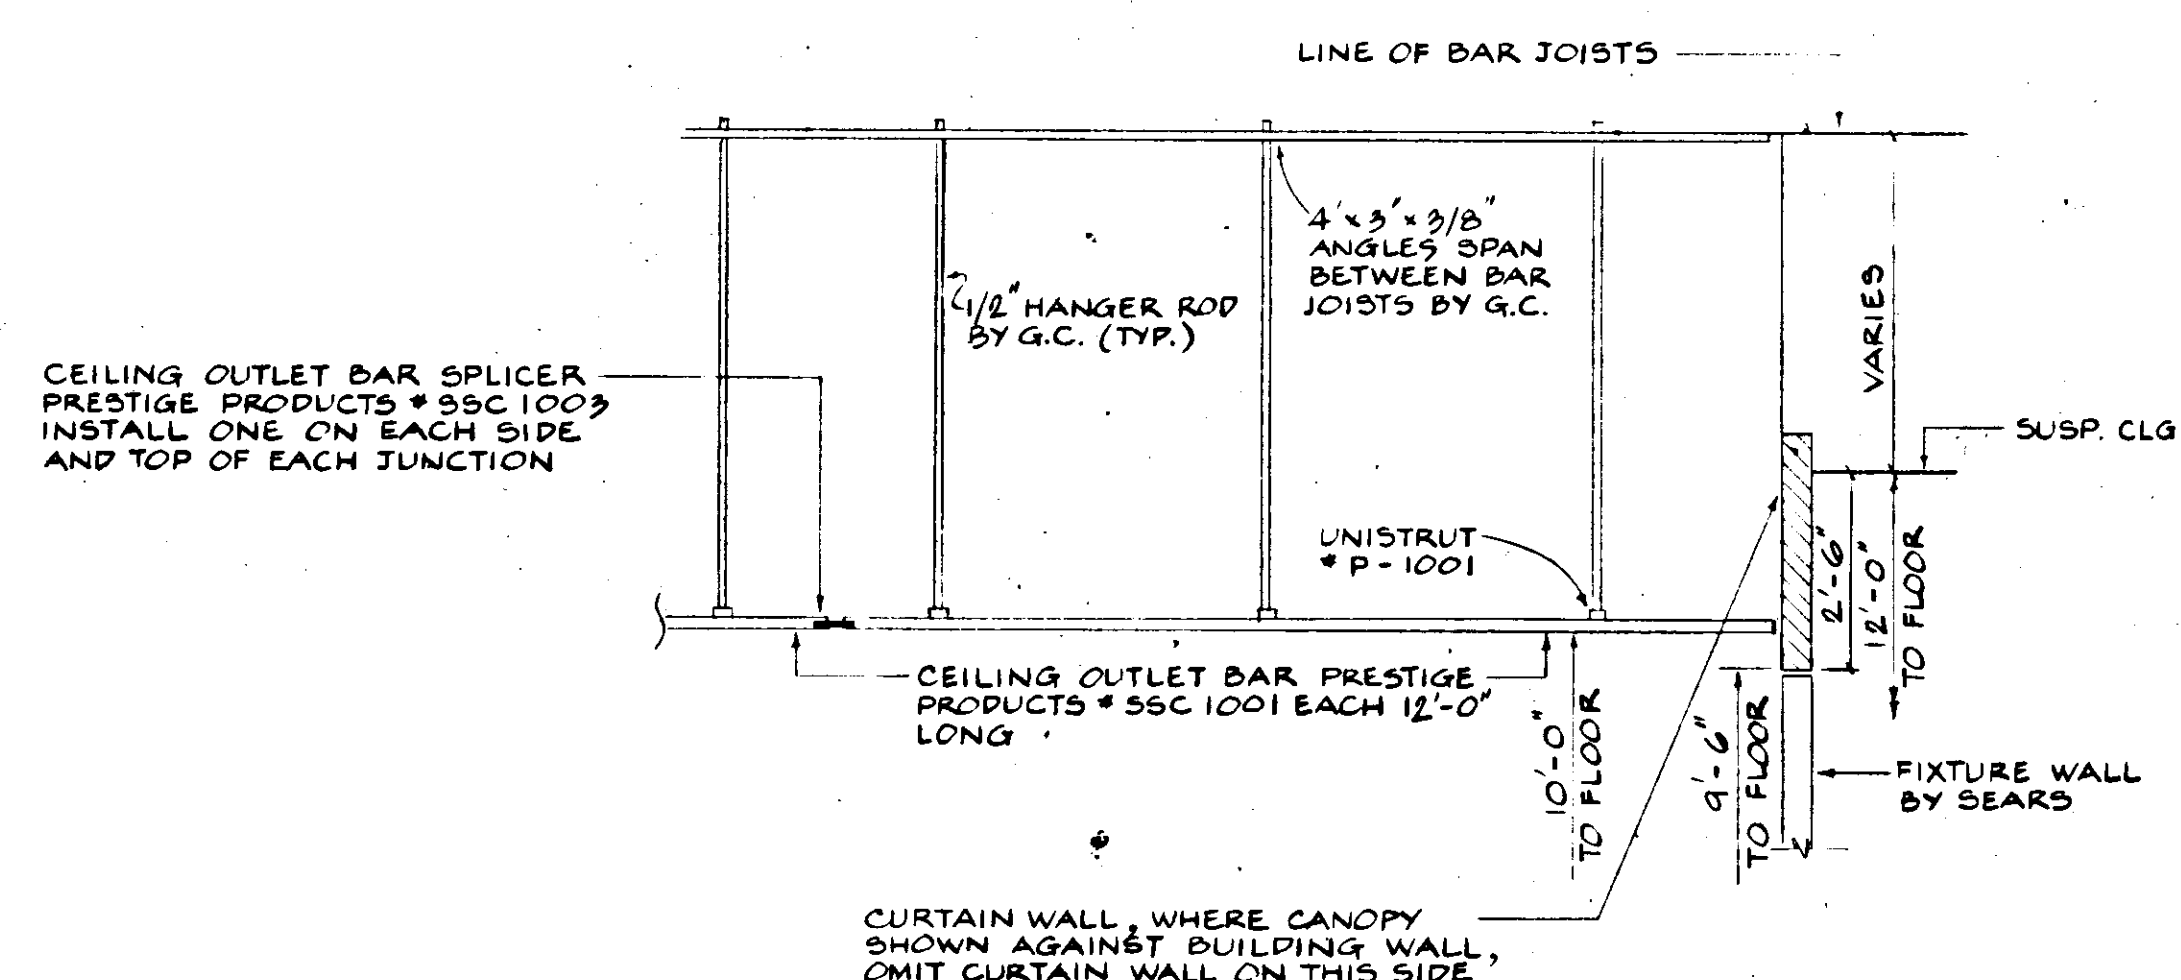


SECTION B-B'
SCALE: 3/8" = 1'-0"

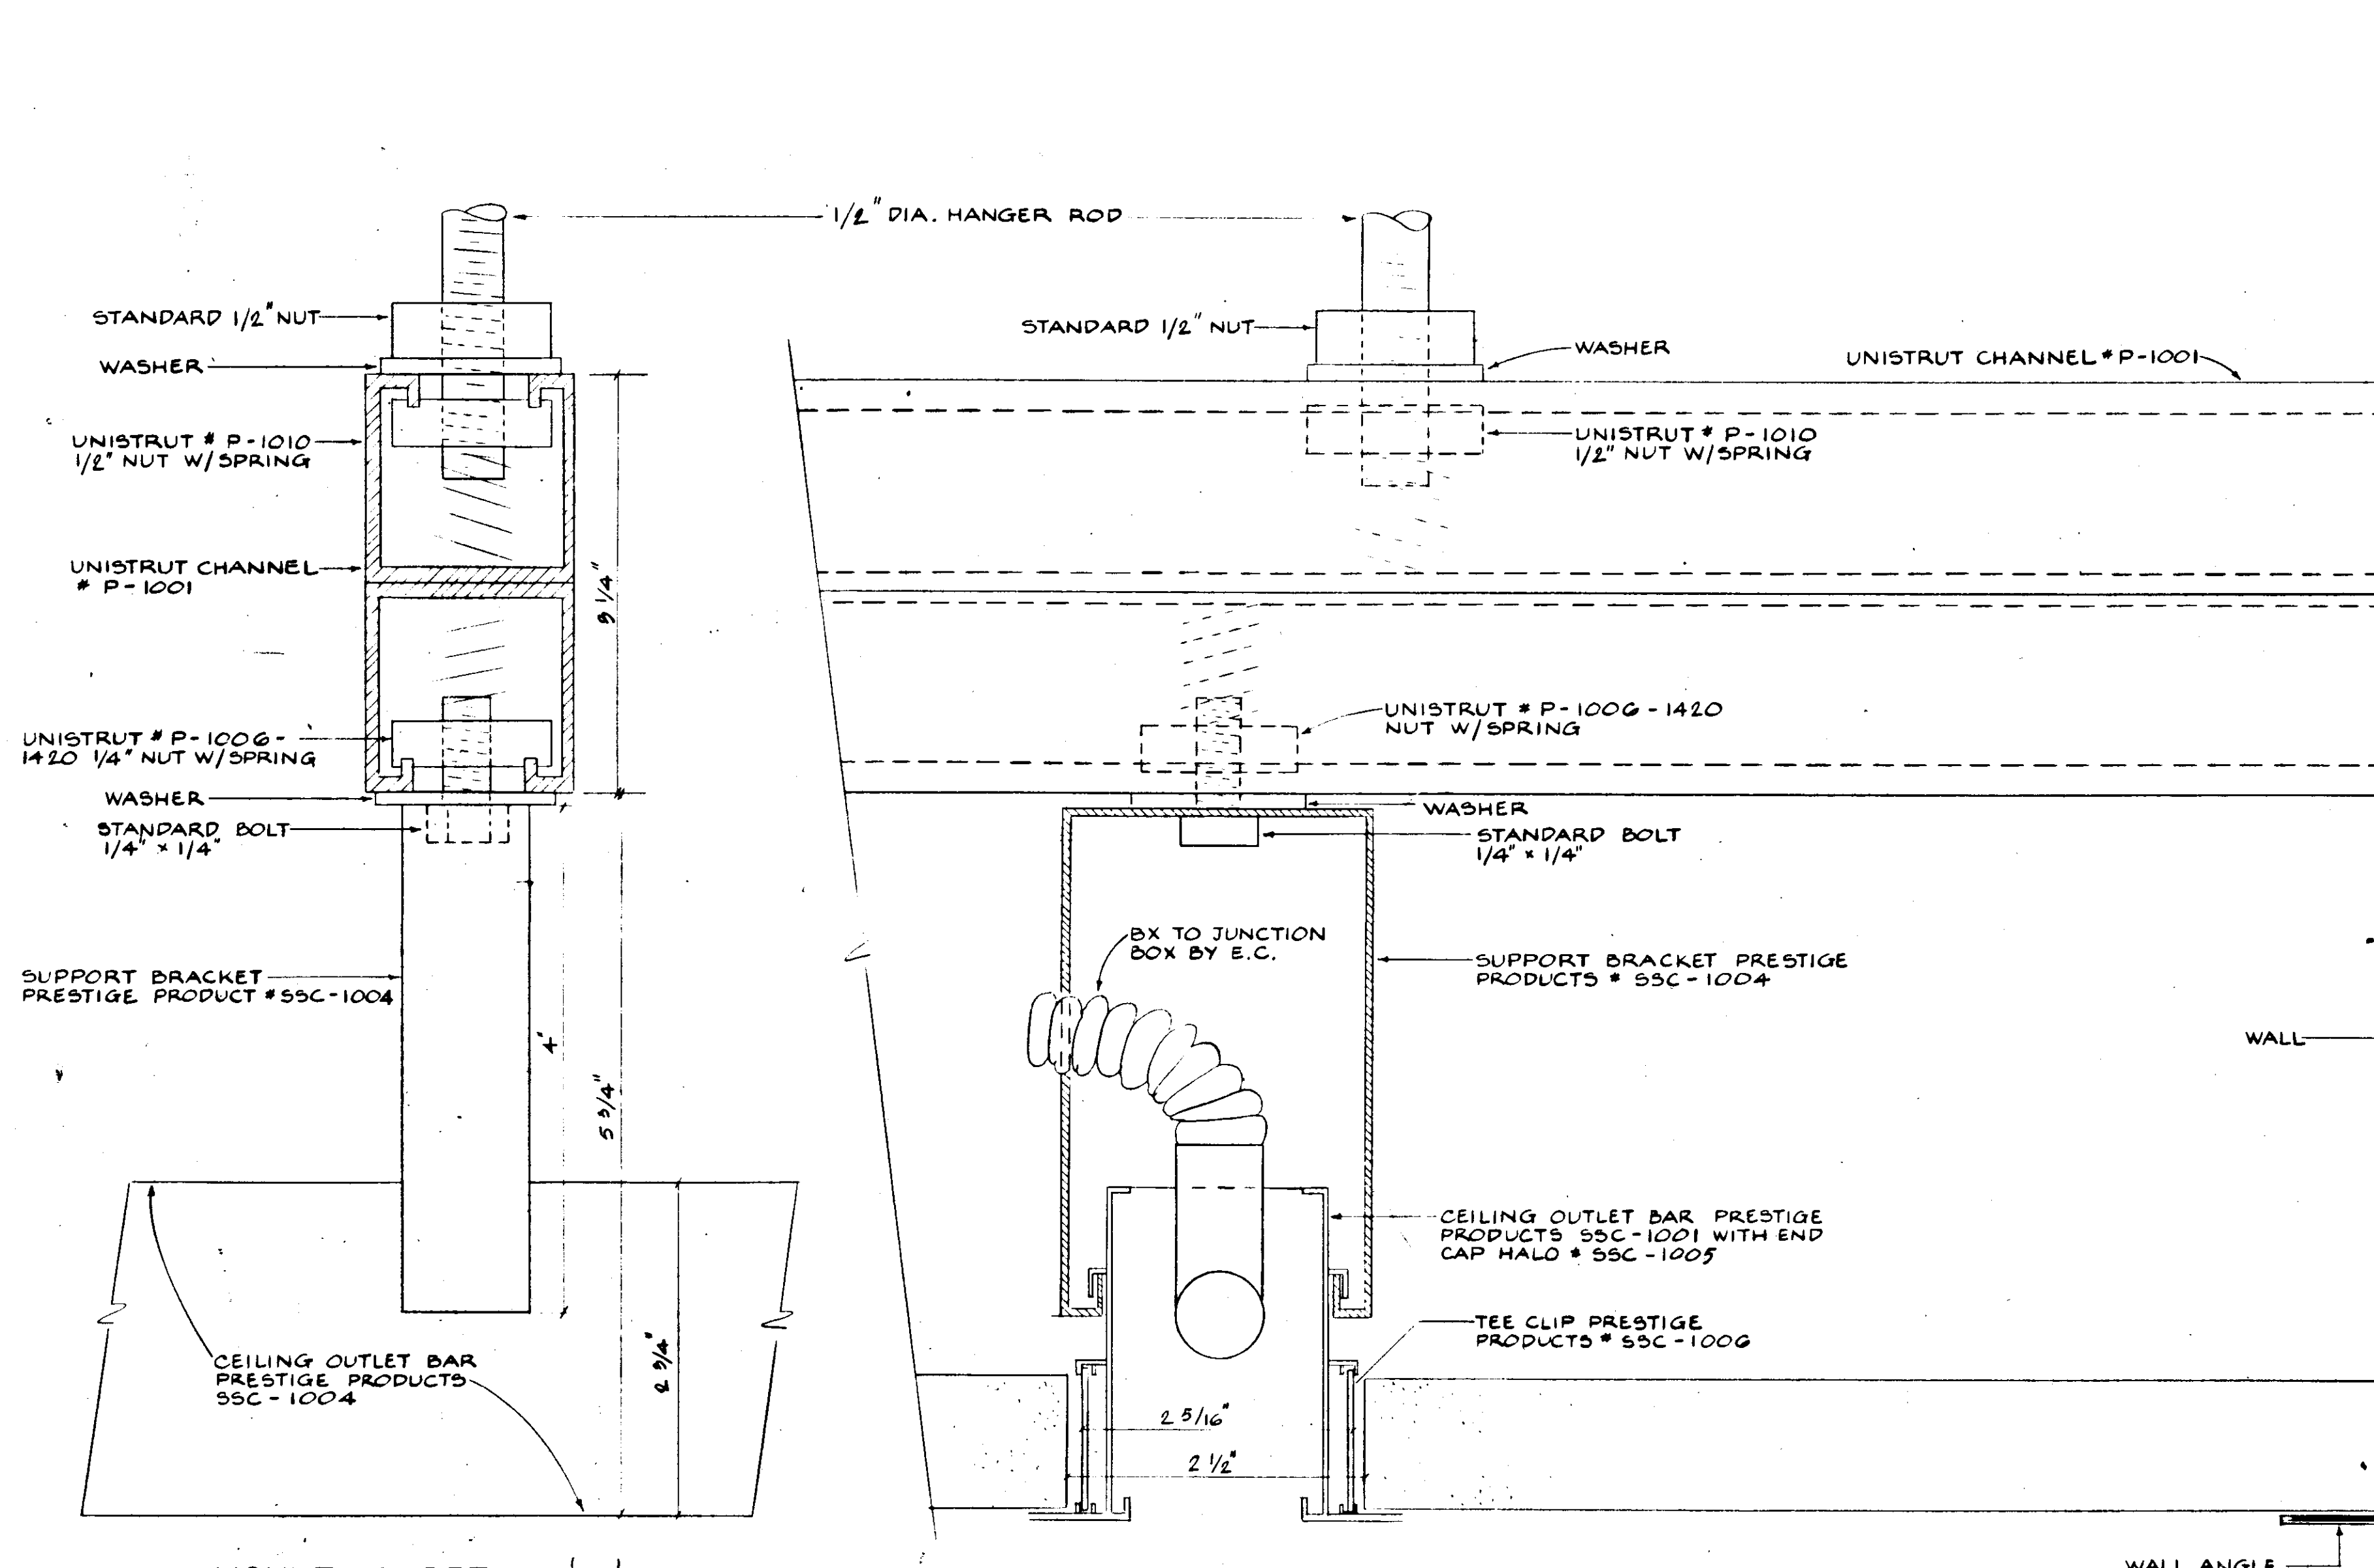

MOUNTING DETAIL 'B'
FULL SCALE

MOUNTING DETAIL 'A'
FULL SCALE

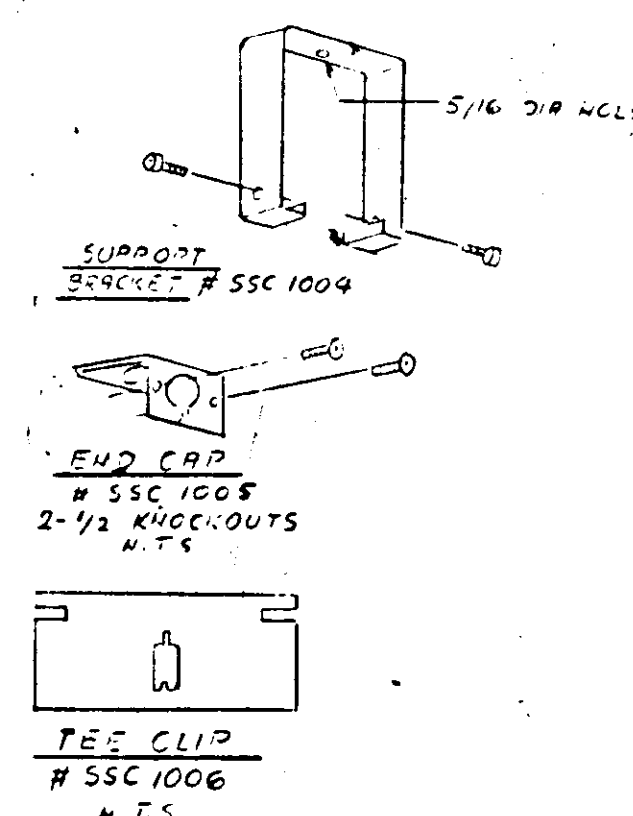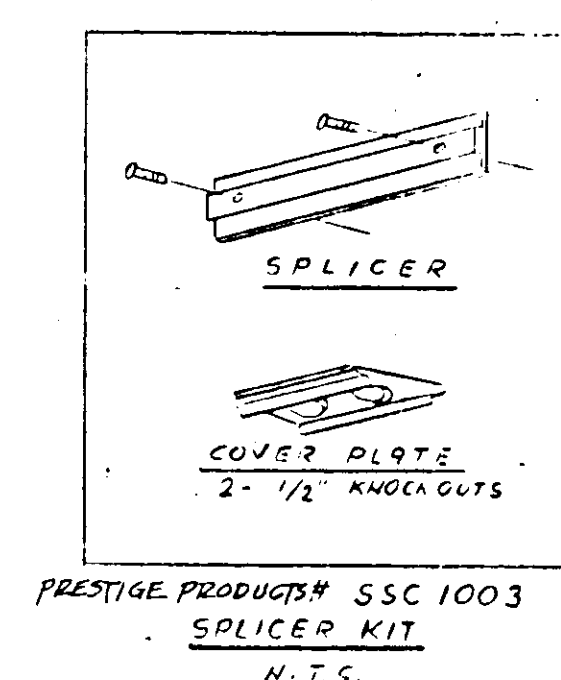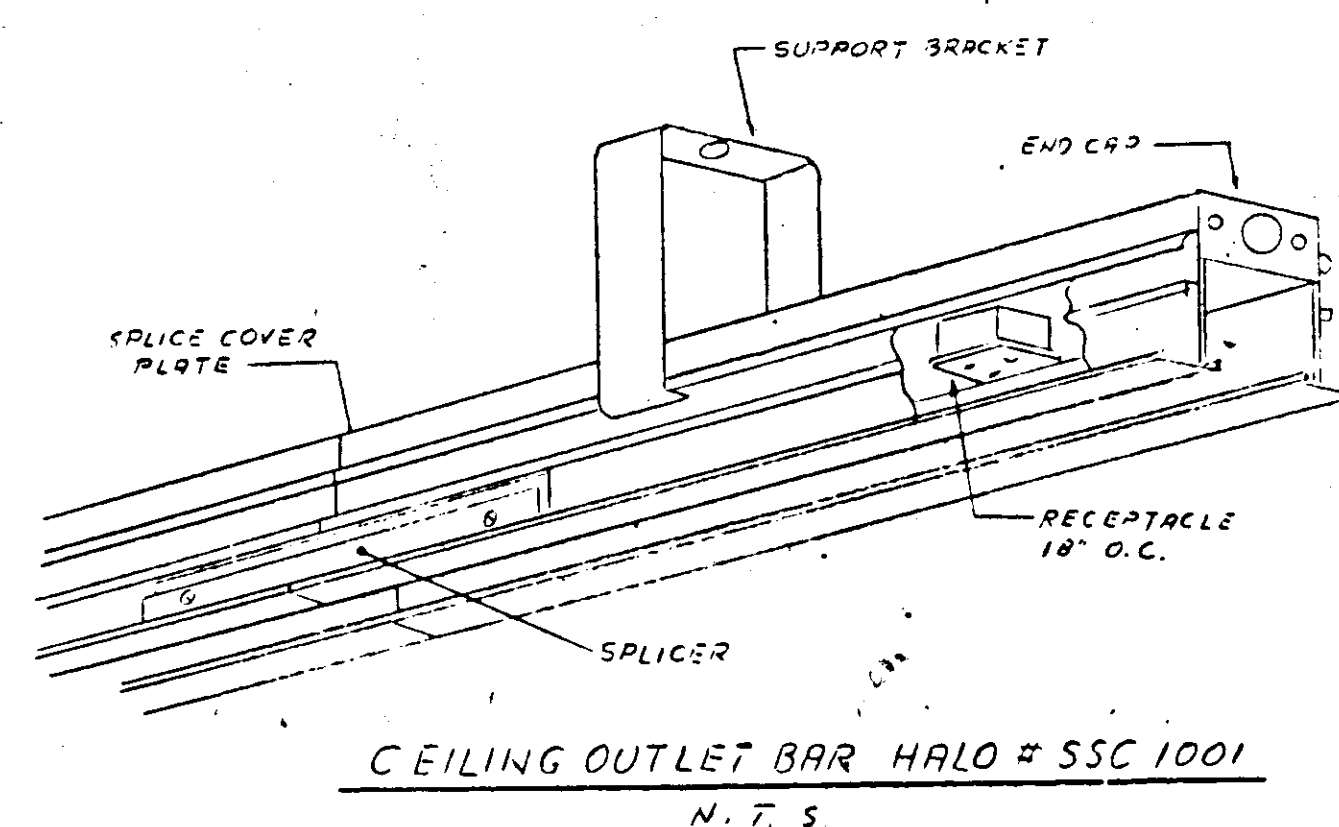

- | GENERAL CONTRACTOR | ELECTRICAL CONTRACTOR |
|---|---|
| 1. FURNISH AND INSTALL ANGLES AT BAR JOISTS AND 3/4" HANGER RODS AS DIMENSIONED ON FLOOR PLANS AND THIS DETAIL. | 1. FURNISH AND INSTALL #P-1001 UNISTRUT WITH ALL MTG. ACCESSORIES. |
| 2. BUILD CURTAIN WALL. | 2. INSTALL ALL CEILING OUTLET BARS PER DETAIL. ALL PRESTIGE PRODUCTS EQUIPMENT SHALL BE FURNISHED BY SEARS, INSTALLED BY ELEC. CONTRACTOR. CUT TO LENGTH AS REQD. |
| 3. FURNISH AND INSTALL CLG. TIES AND CEILING TILE. | 3. PROVIDE ALL WIRING FROM PANEL AS SHOWN (CEILING OUTLET BARS ARE PREWIRED). |
| 4. RESPONSIBLE FOR SPRINKLERS IN CANOPY CEILING. | 4. FOR MTG. DETAILS SEE ABOVE. |

SEARS, ROEBUCK AND CO.
ALTERATIONS AND ADDITIONS TO
RETAIL STORE
SECURITY SQUARE, BALTIMORE, MD.

FEDCO SYSTEMS INC.
10905 FT. WASHINGTON ROAD
FORT WASHINGTON, MARYLAND 20744
292-3900 645-3337
ARCHITECTS - ENGINEERS - PLANNERS - SURVEYORS

RSI

SHEET NO.

E-14

ELECTRONIC CONTROL #
R1634 116 E14

PROJECT NO. 531-2