



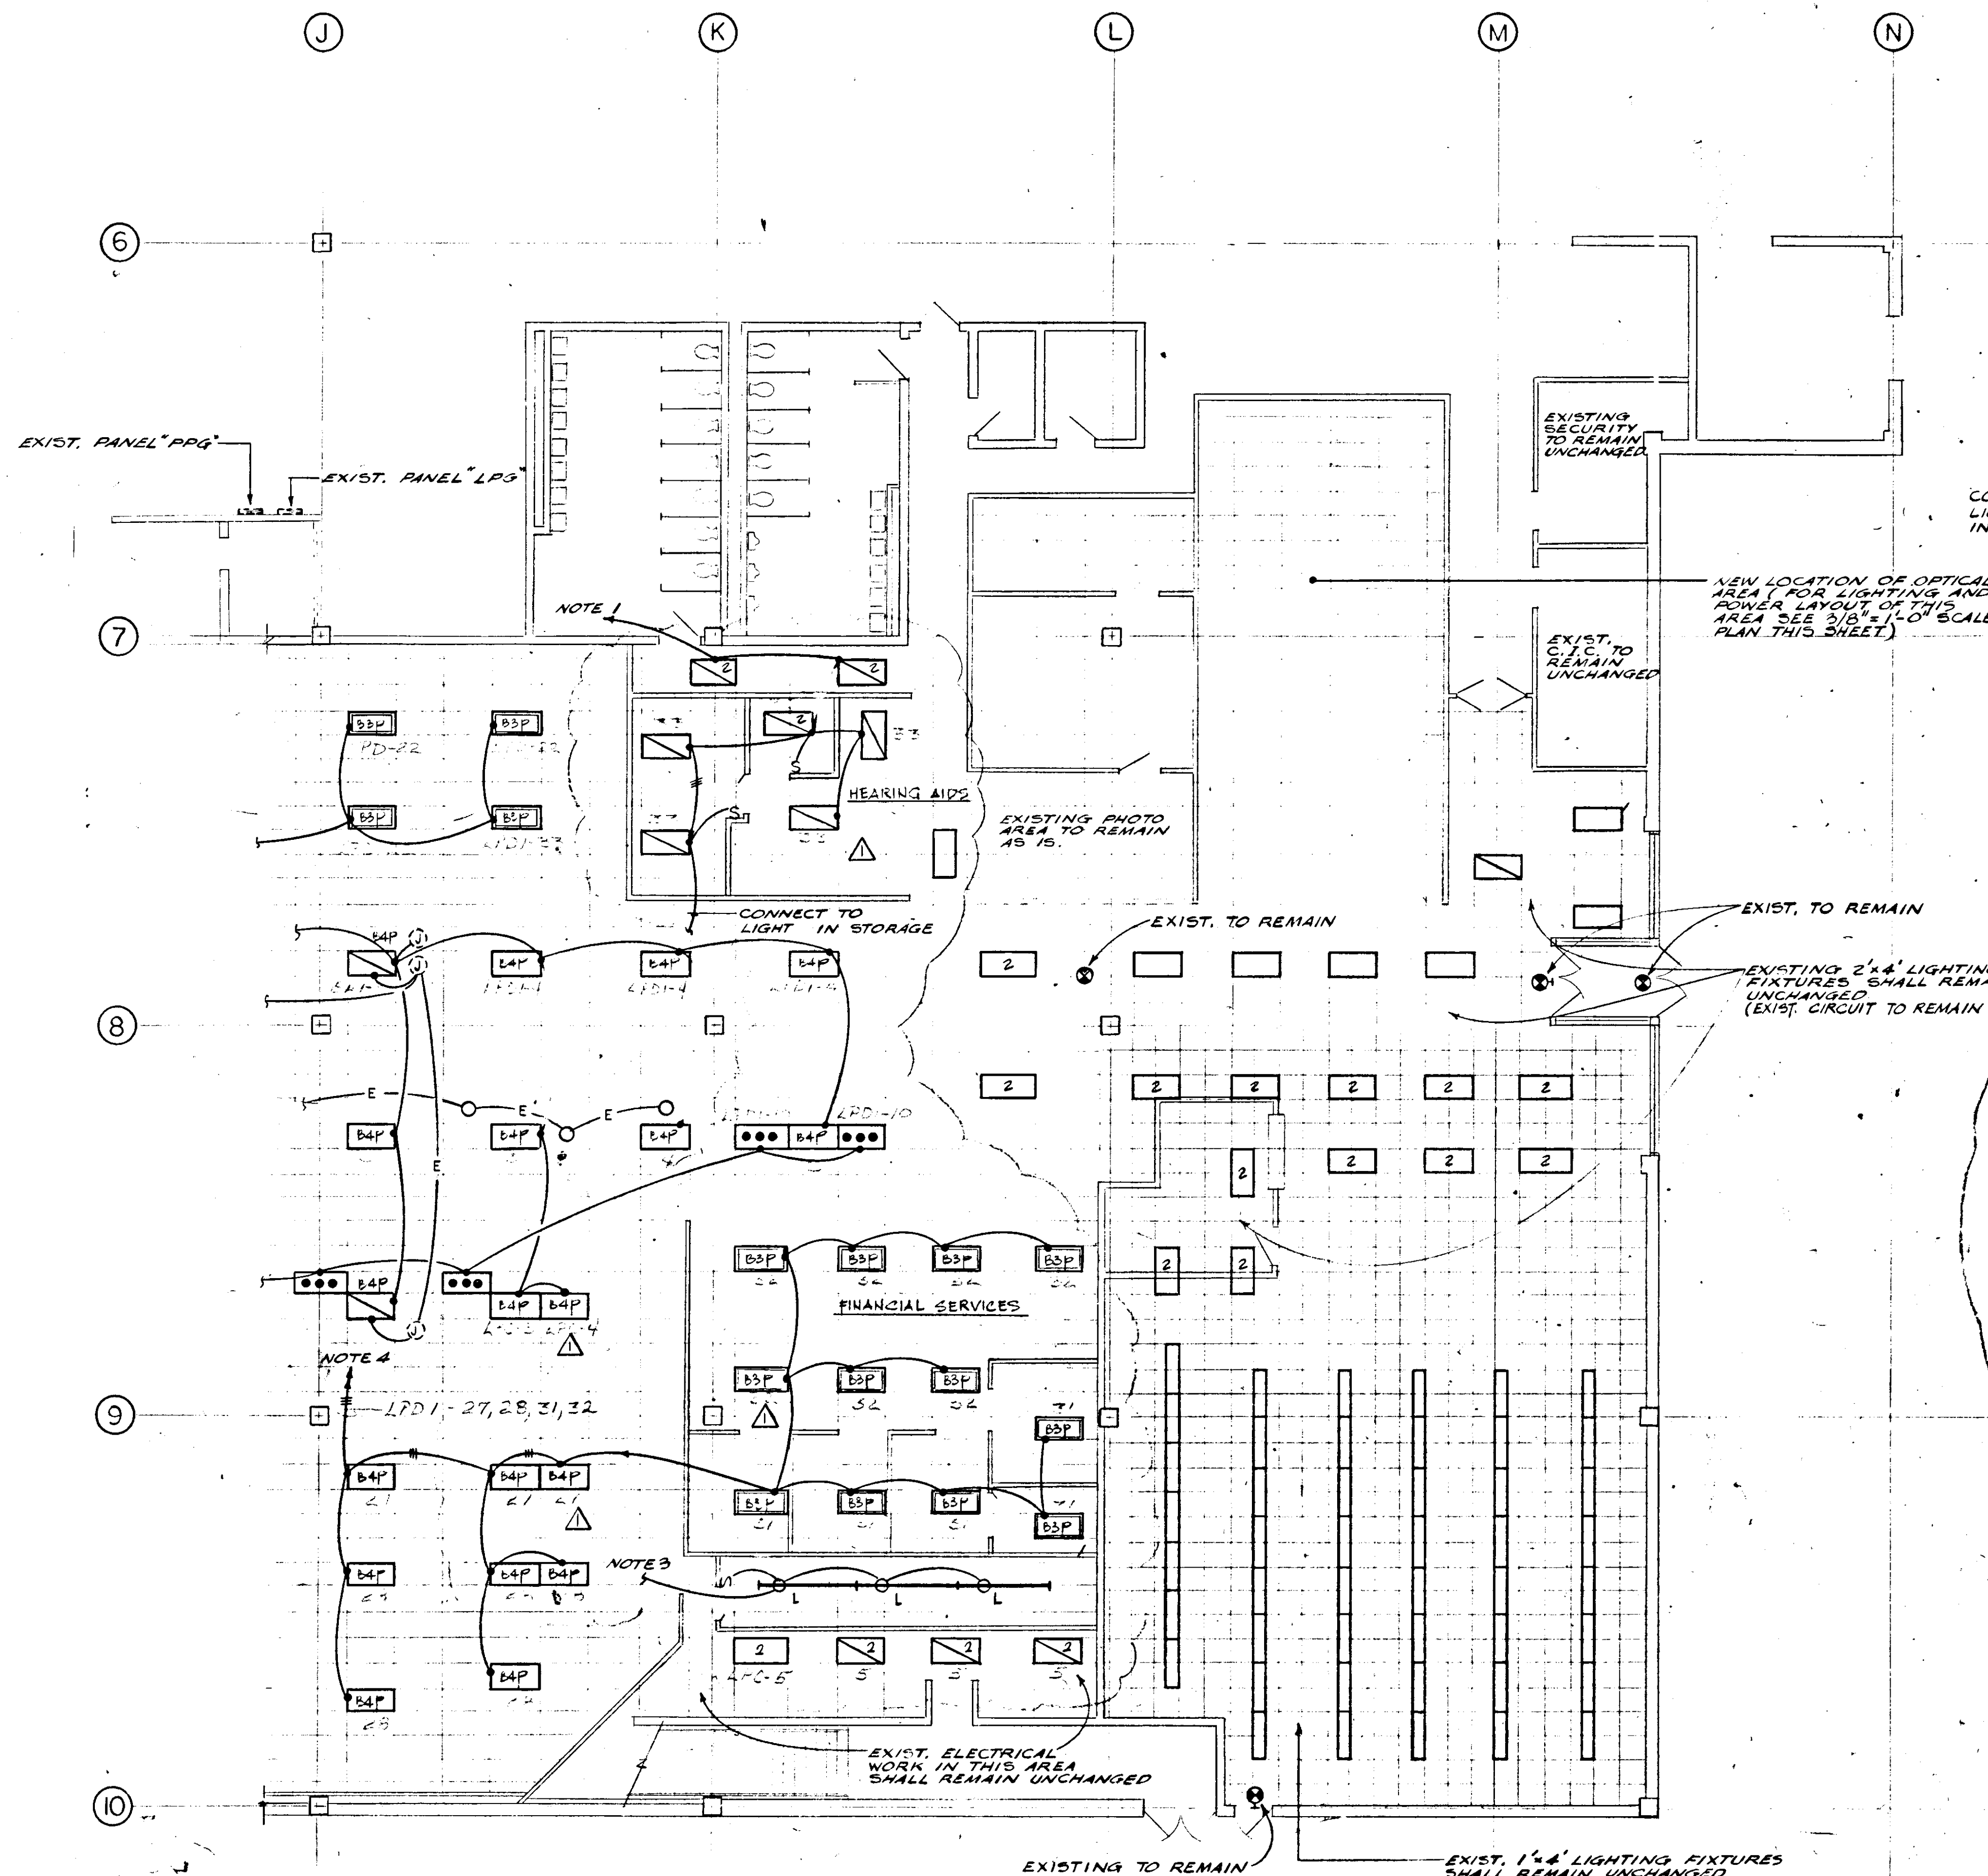

FIRST FLOOR - LIGHTING
SCALE: 1/8" = 1'-0"

NOTES:


1. CONNECT TO 1-IP-20A SPARE CIRCUIT BREAKER IN EXISTING PANEL "LPG" RUN 3/12 (BX) TO LIGHTS AS SHOWN.
2. DELETED
3. CONNECT TO LIGHTING FIXTURE IN HEARING AID
4. CONNECT TO 2-IP-20A SPARE CIRCUIT BREAKERS IN EXISTING PANEL "LPG" RUN 3/12 (BX) TO LIGHTS AS SHOWN

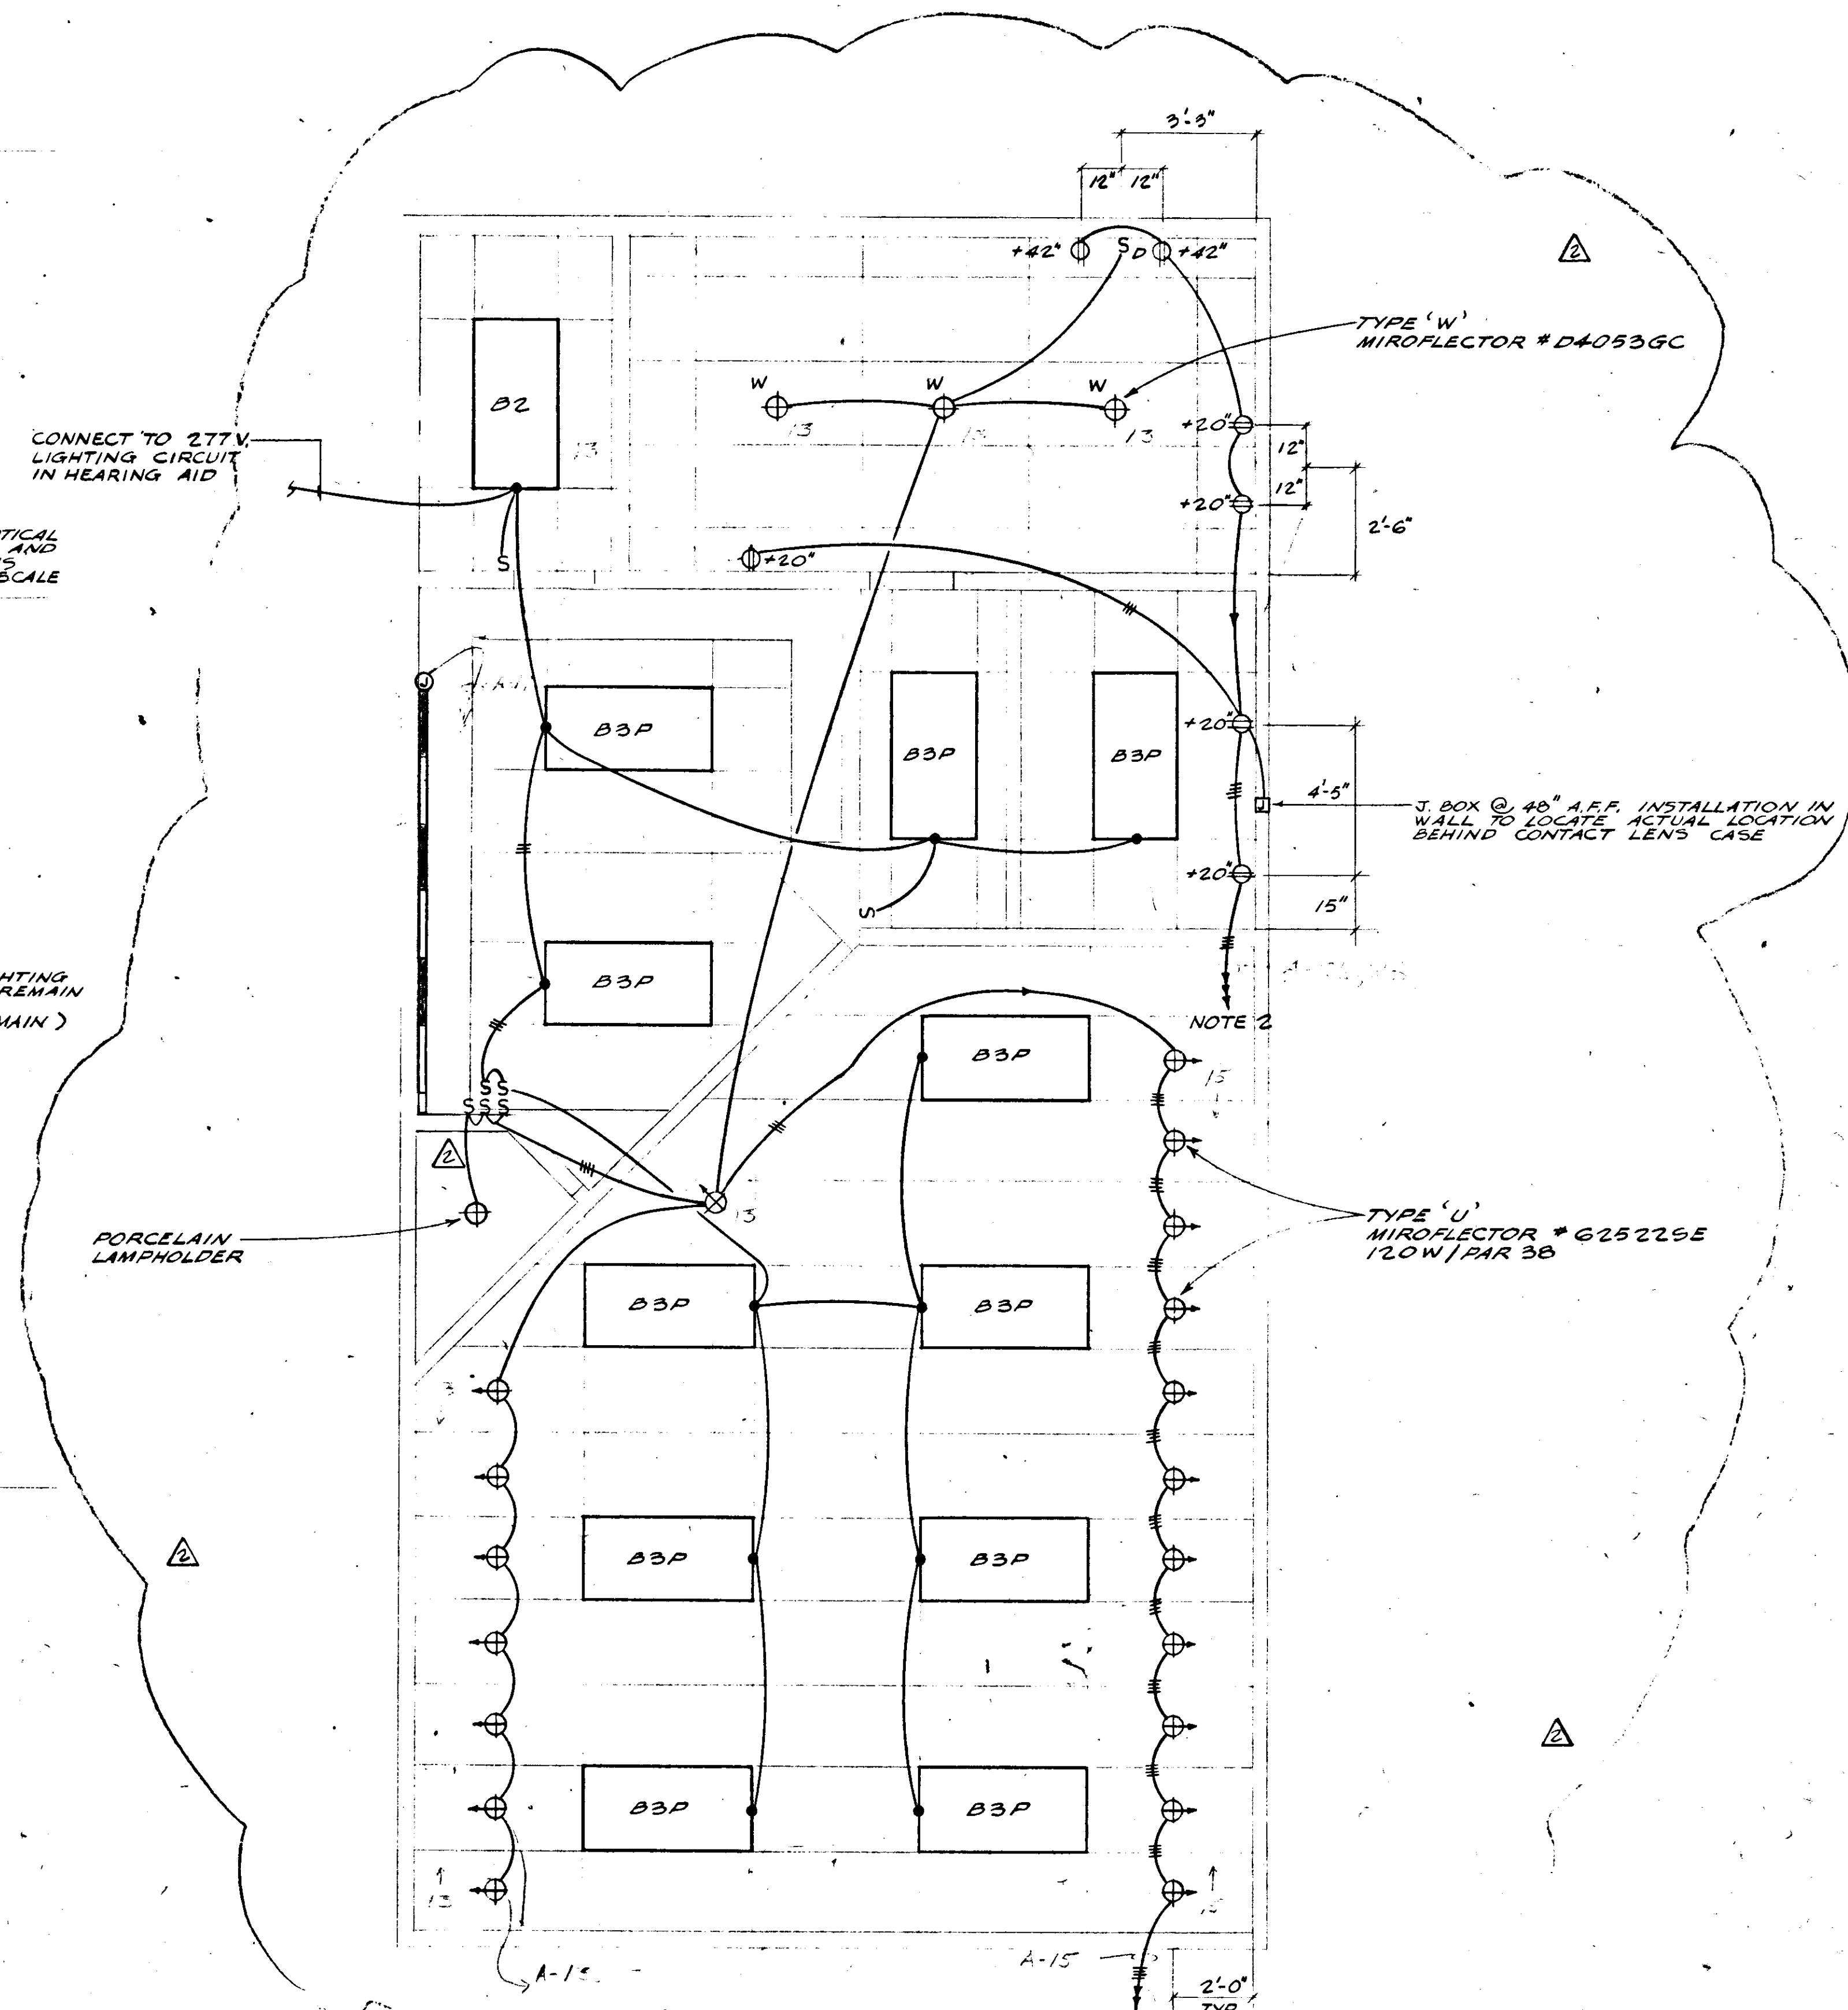

OPTICAL OPTOMETRIST LIGHTING & POWER PLAN
SCALE: 3/8" = 1'-0"

NOTES:

1. CONNECT TO 2-IP-20A SPARE CIRCUIT BREAKERS IN EXISTING PANEL "A" RUN 3/12 (BX) TO LIGHTS AS SHOWN
2. CONNECT TO 3-IP-20A SPARE CIRCUIT BREAKERS IN EXIST. PANEL "A" RUN 4/12 (BX) TO OUTLET AS SHOWN

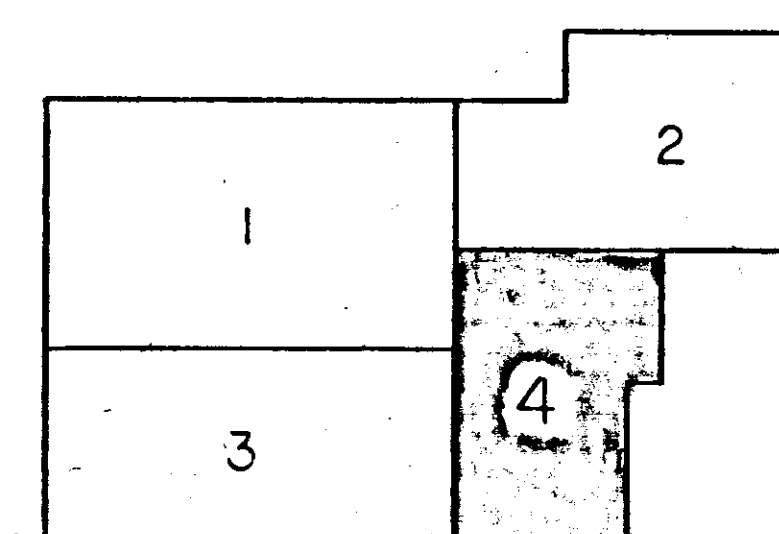

SHEET TITLE: FIRST FLOOR - LIGHTING (QUADRANT 4)

SEARS

SEARS, ROEBUCK AND CO.
ALTERATIONS AND ADDITIONS TO
RETAIL STORE
SECURITY SQUARE, BALTIMORE, MD.

FEDCO SYSTEMS INC.
10905 FT. WASHINGTON ROAD
FORT WASHINGTON MARYLAND 20744
292-3900 645-3337
ARCHITECTS - ENGINEERS - PLANNERS - SURVEYORS

RSI

SHEET NO.

E-5

PROJECT NO. 531-2

ELECTRONIC CONTROL
R1634, 10Z ES

ISSUED	REVISIONS	DATE	DRAWN	CHECKED
	1. 10/05/74	10/05/74		
	2. 10/05/74	10/05/74		
	3. 10/05/74	10/05/74		
	4. 10/05/74	10/05/74		
	5. 10/05/74	10/05/74		
	6. 10/05/74	10/05/74		
	7. 10/05/74	10/05/74		
	8. 10/05/74	10/05/74		
	9. 10/05/74	10/05/74		
	10. 10/05/74	10/05/74		
	11. 10/05/74	10/05/74		
	12. 10/05/74	10/05/74		
	13. 10/05/74	10/05/74		
	14. 10/05/74	10/05/74		
	15. 10/05/74	10/05/74		
	16. 10/05/74	10/05/74		
	17. 10/05/74	10/05/74		
	18. 10/05/74	10/05/74		
	19. 10/05/74	10/05/74		
	20. 10/05/74	10/05/74		
	21. 10/05/74	10/05/74		
	22. 10/05/74	10/05/74		
	23. 10/05/74	10/05/74		
	24. 10/05/74	10/05/74		
	25. 10/05/74	10/05/74		
	26. 10/05/74	10/05/74		
	27. 10/05/74	10/05/74		
	28. 10/05/74	10/05/74		
	29. 10/05/74	10/05/74		
	30. 10/05/74	10/05/74		