


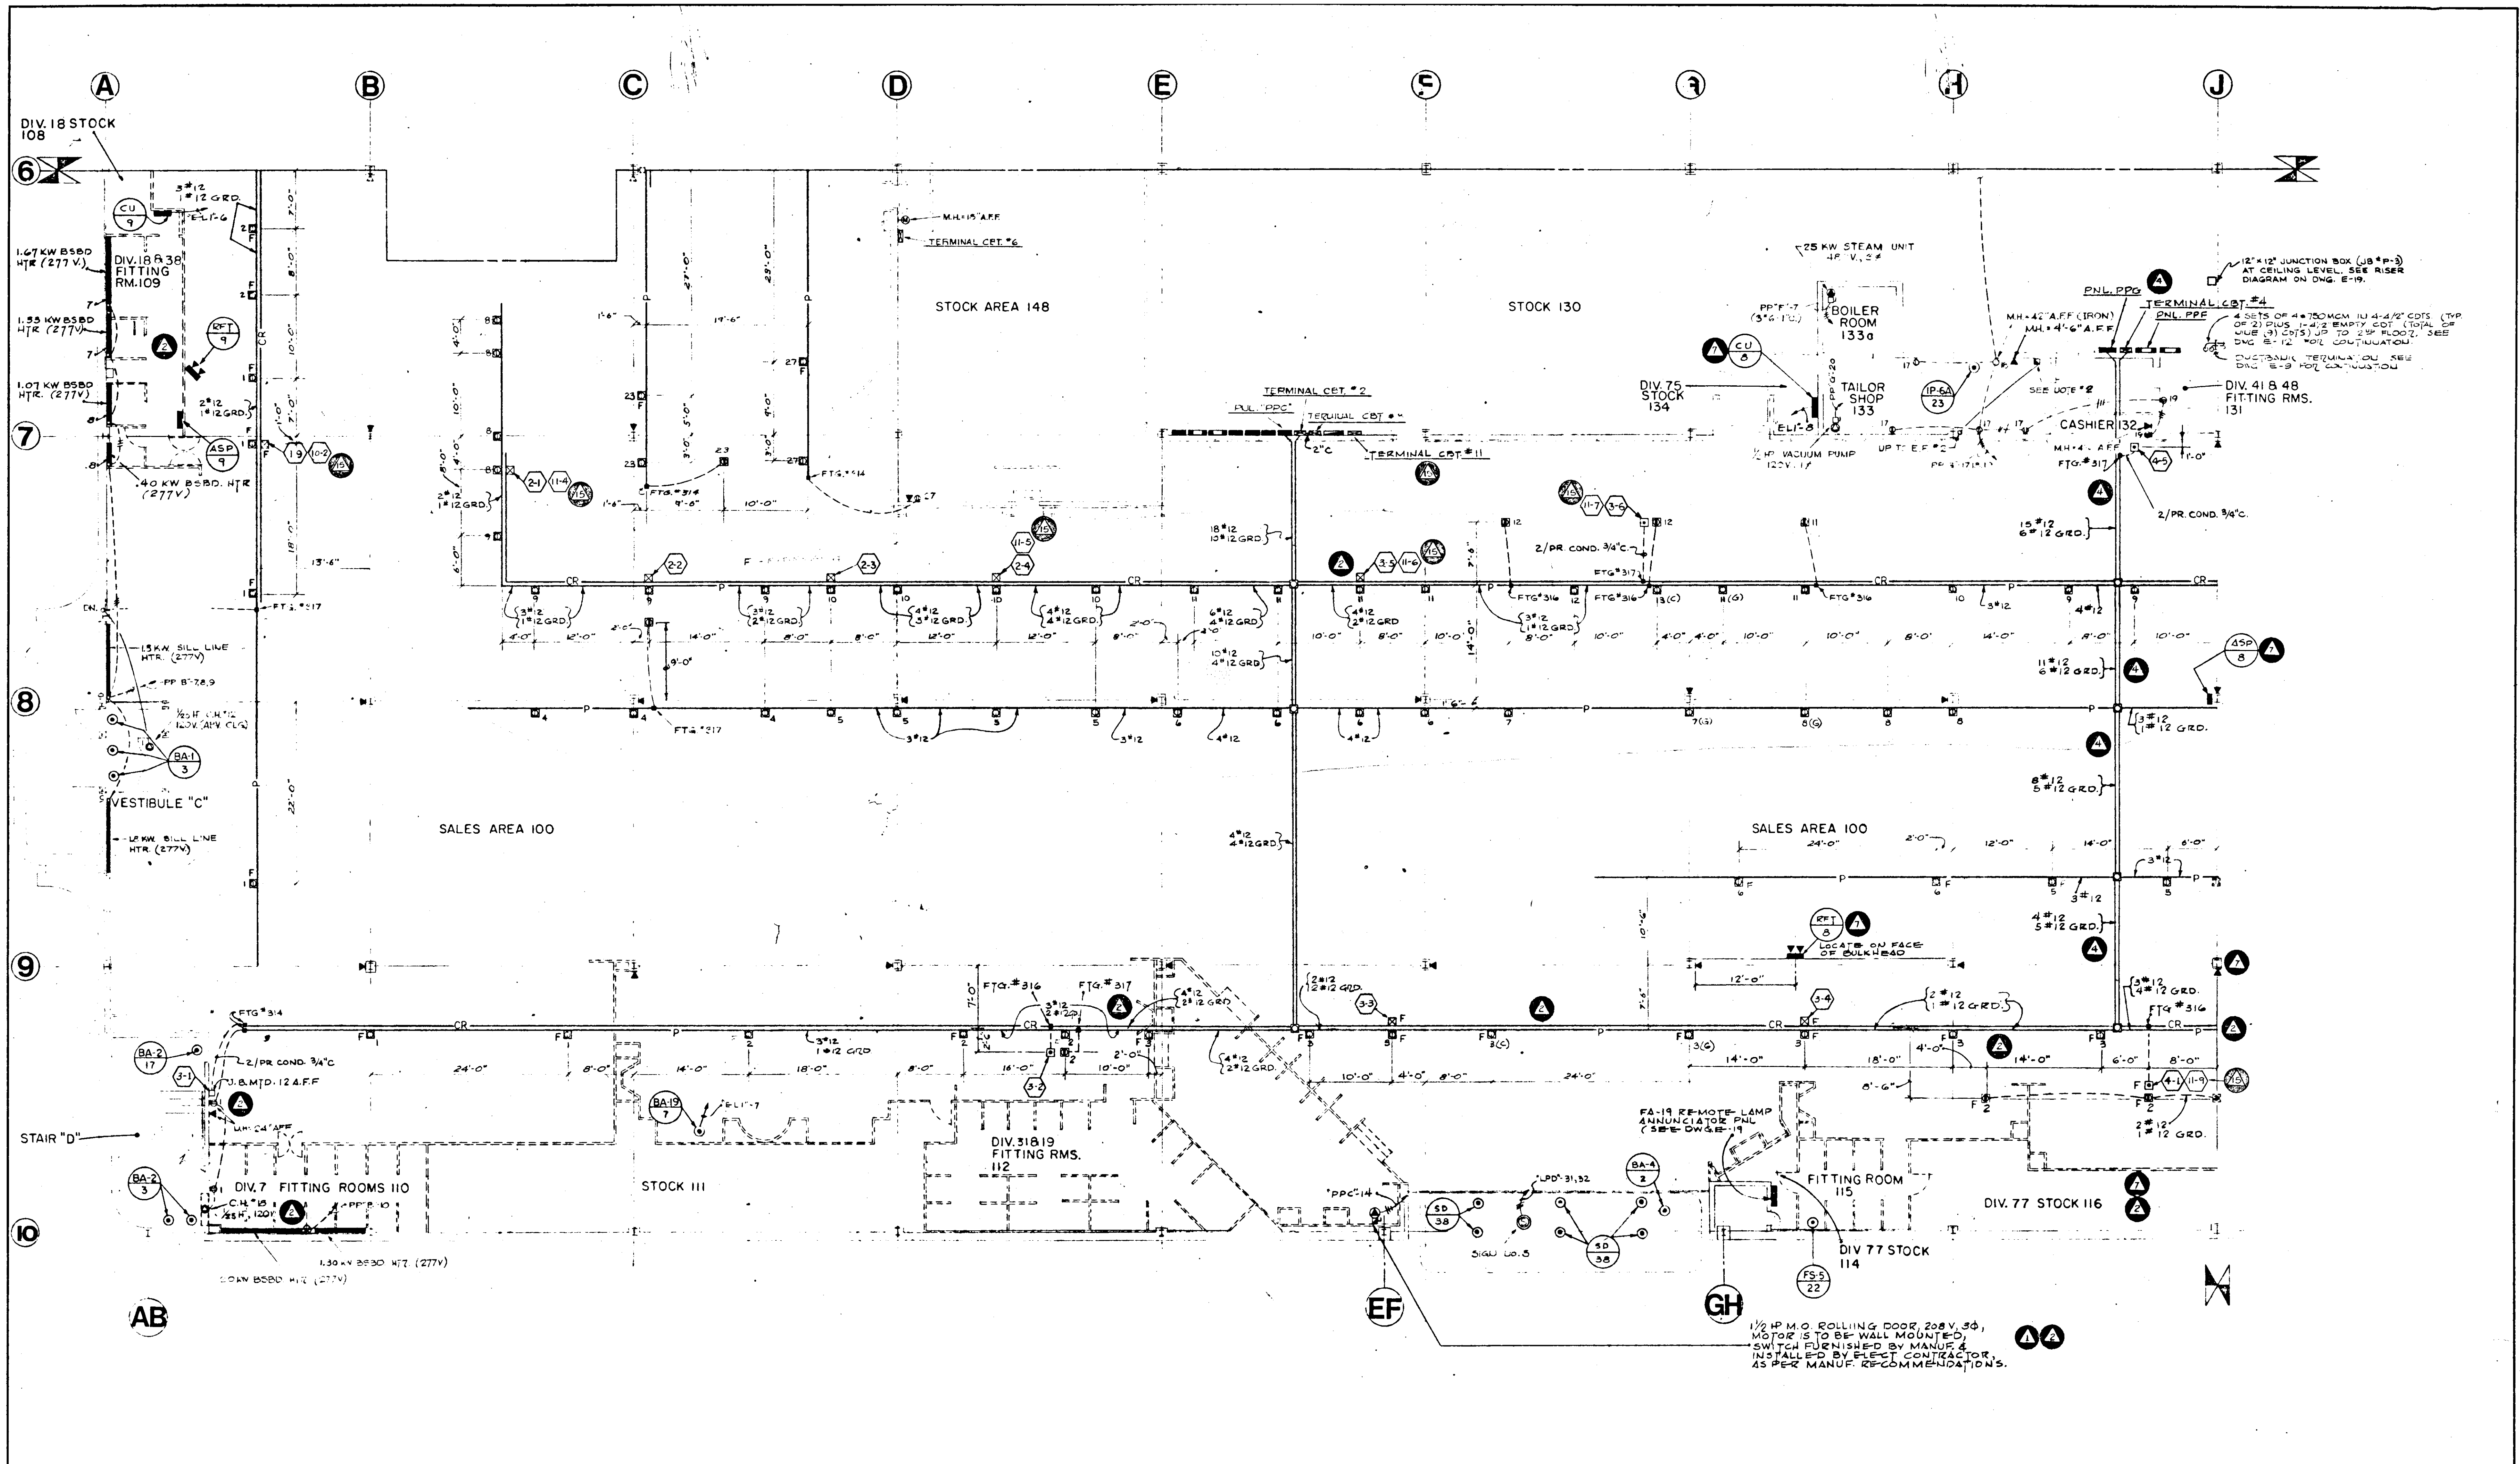

NOTES:

- SEE RISER DIAGRAM ON DWG E-22 FOR NUMBER OF CONDUCTORS IN CASH REGISTER UNDERFLOOR DUCTS.
- P.B. STATION RUN 3/4" UP TO EXH. PAN #2 (SAME AS #4)

F. ADL 30 22.10.15

- OCT. 20, 1972
- MAY 2, 1972
- MARCH 7, 1972
- NOV 1, 1971
- OCT. 1, 1971

ELECTRONIC CONTROL #
E-127-071E7

ABM

ALLAN B. MITCHELL and ASSOCIATES ARCHITECTS PITTSBURGH, PA.

FIRST FLOOR - QUADRANT N° 3, POWER PLAN
RETAIL STORE and 23 CAR AUTO SERVICE
SEARS ROEBUCK & COMPANY
SECURITY SQUARE - BALTIMORE WEST, MARYLAND

SCALE 1/8" = 1'-0"
DATE AUGUST 16, 1971
REVISED

DRAWING NUMBER
E-7