




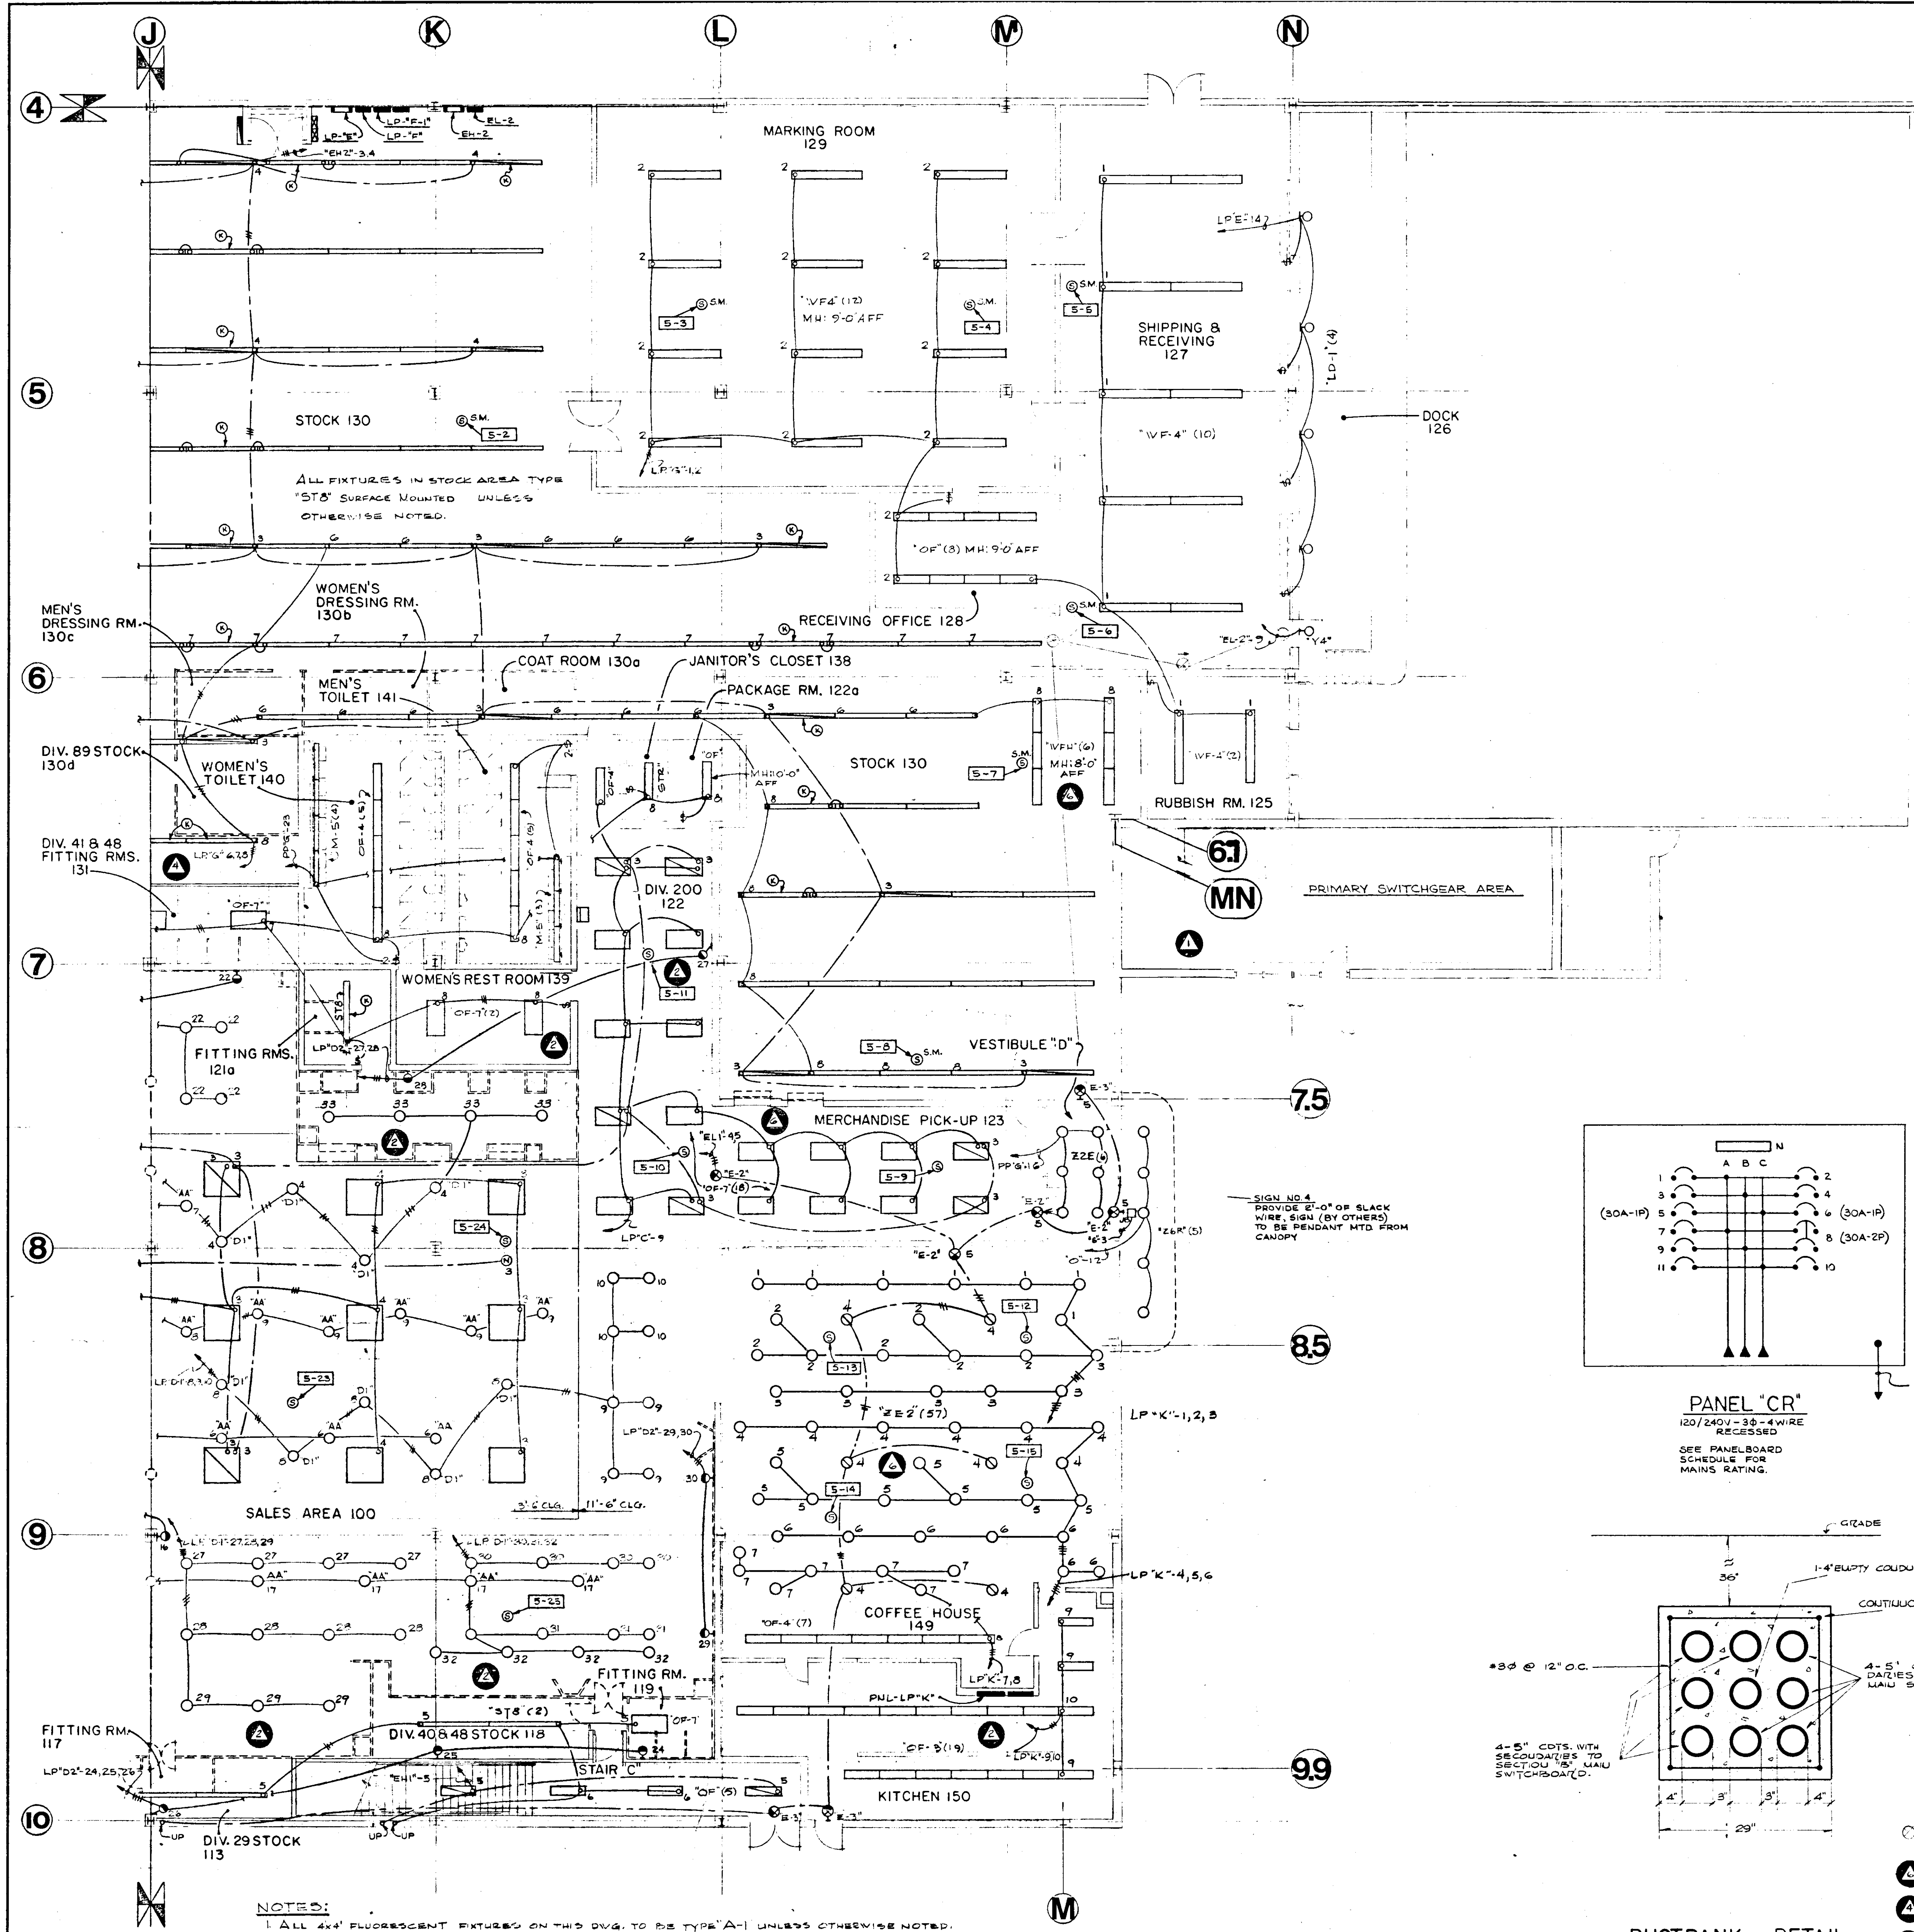


NOTES:
 1. ALL 4x4' FLUORESCENT FIXTURES ON THIS DWG. TO BE TYPE "A-1" UNLESS OTHERWISE NOTED.
 2. ALL RECESSED INCANDESCENT FIXTURES ON THIS DWG. SHALL BE TYPE "D" UNLESS OTHERWISE NOTED.
 3. ALL FLUORESCENT LIGHTING FIXTURES IN KITCHEN 150 AND COFFEE HOUSE 149 AREAS SHALL BE PROVIDED WITH 120V, 60 Hz BALLASTS.

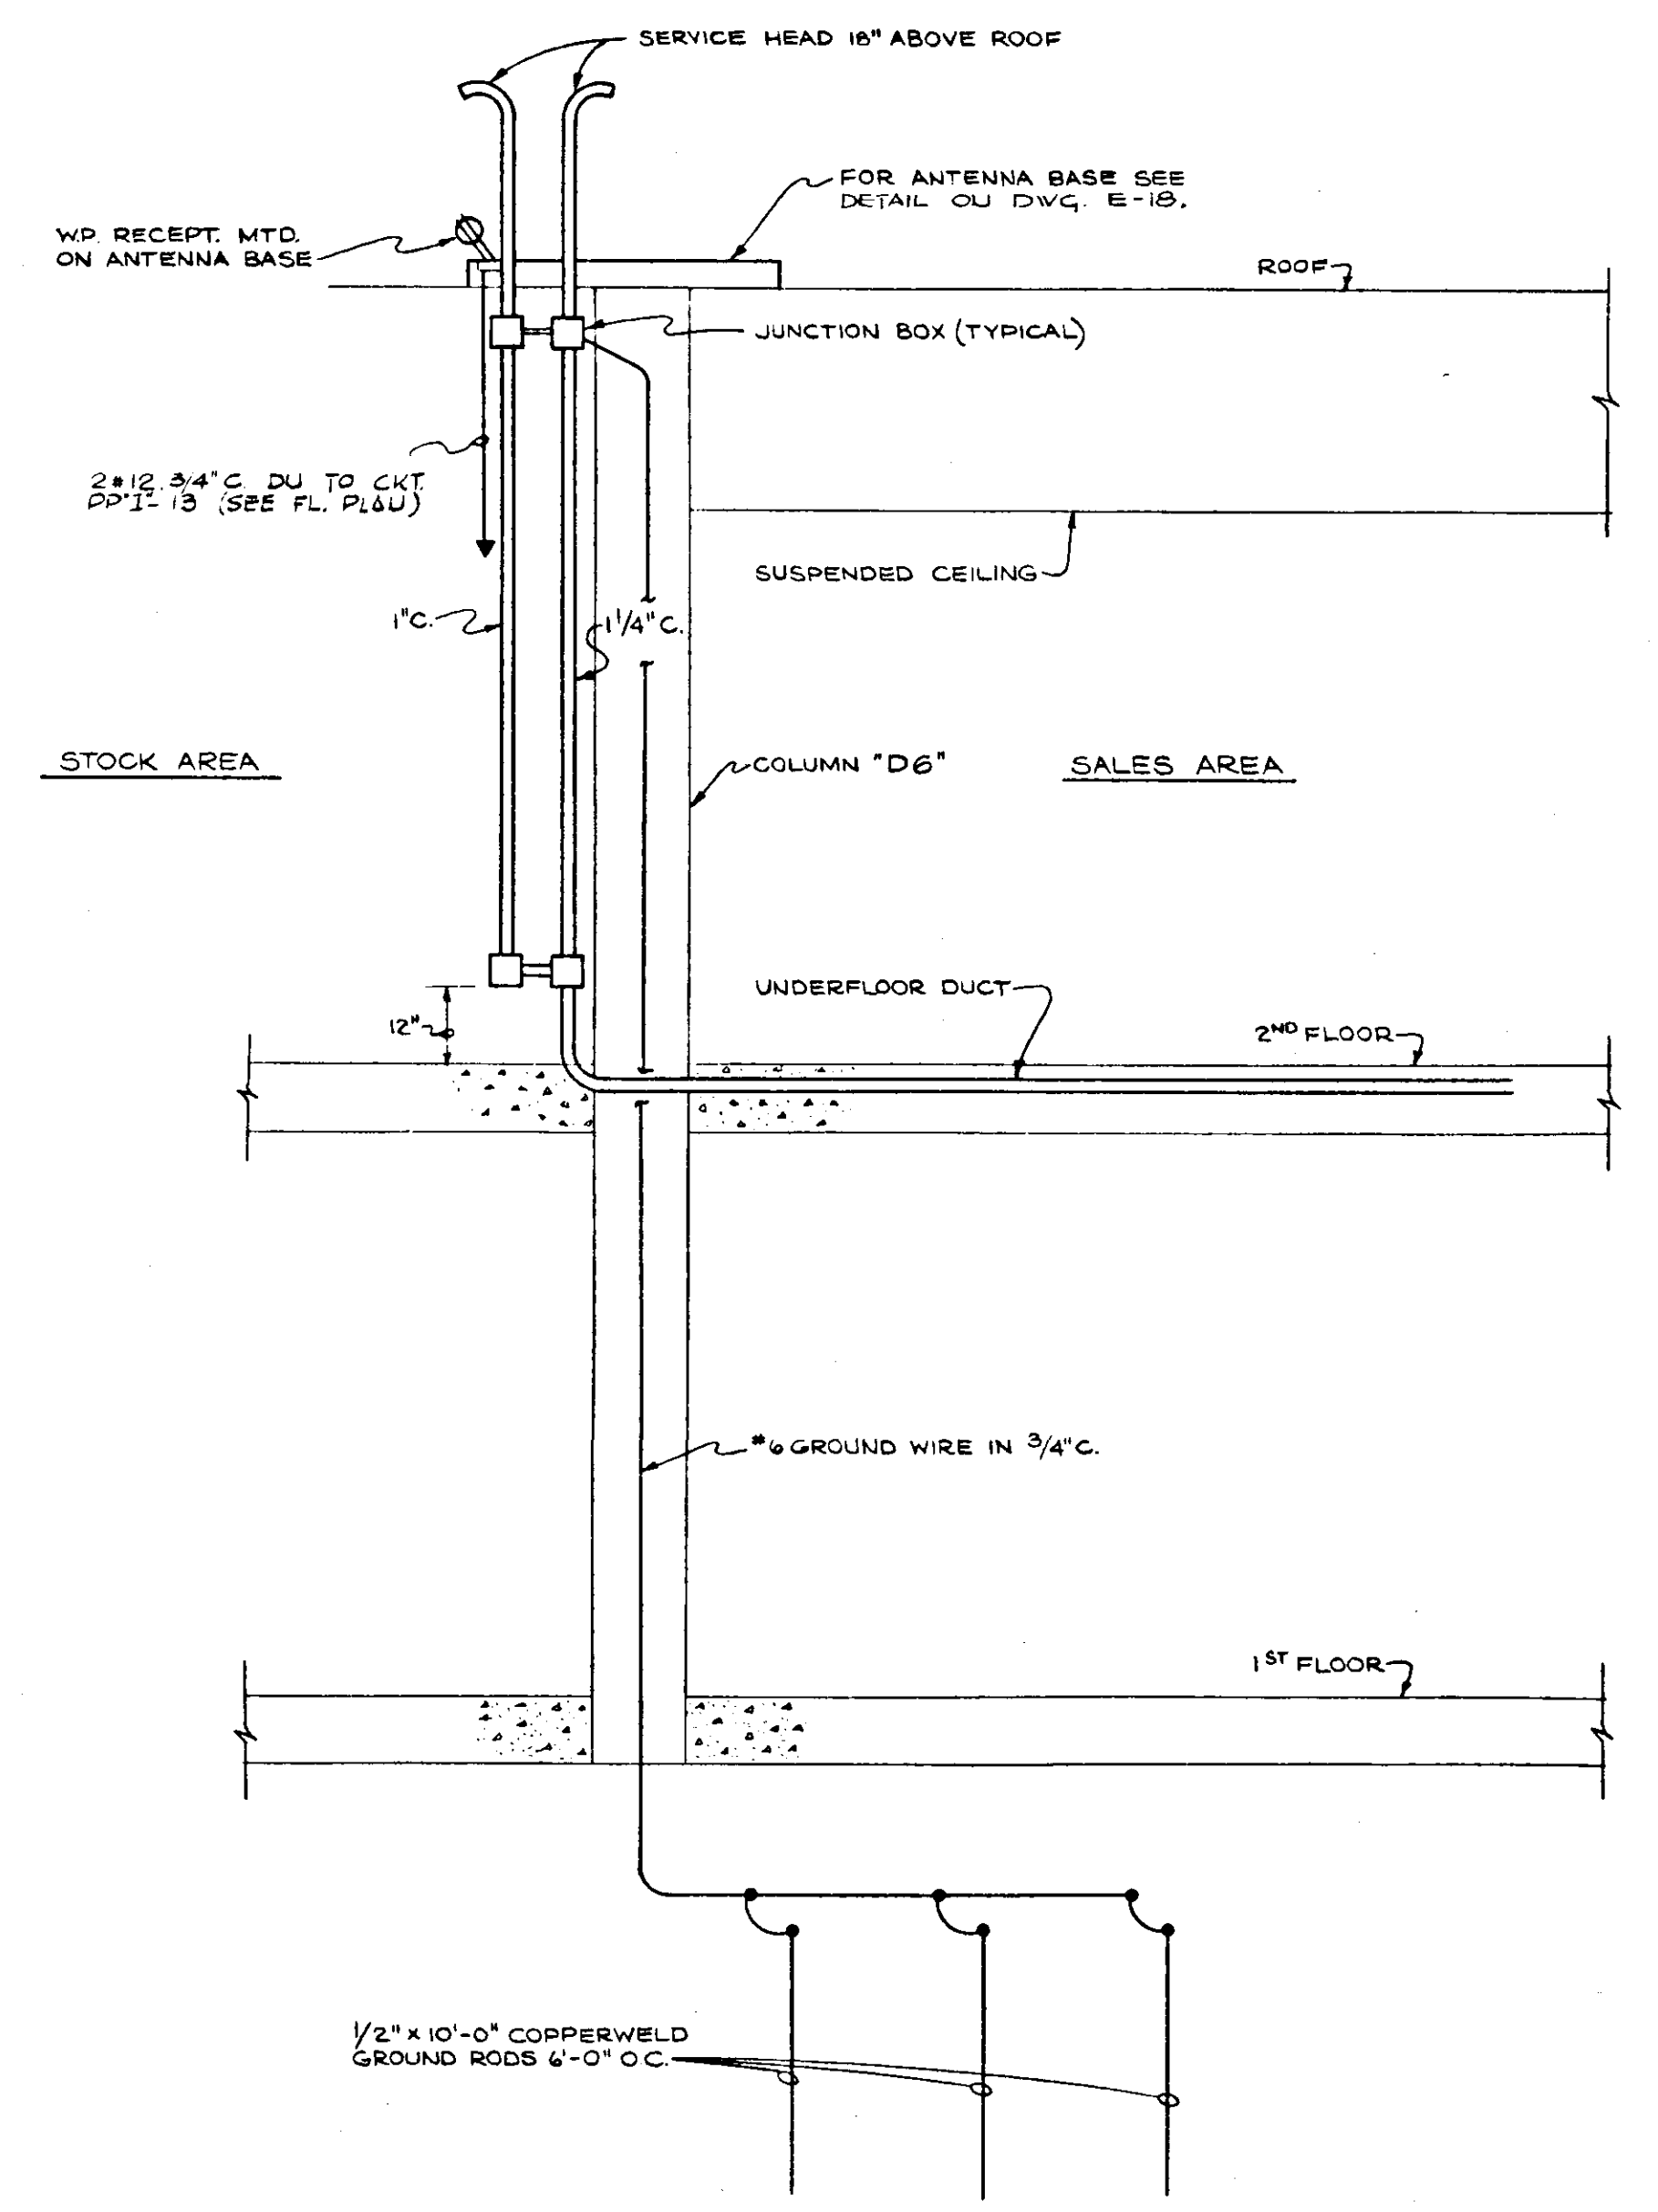


ANTENNA RISER DETAIL
 NO SCALE
 SEE ALSO DETAIL ON DWG. E-18

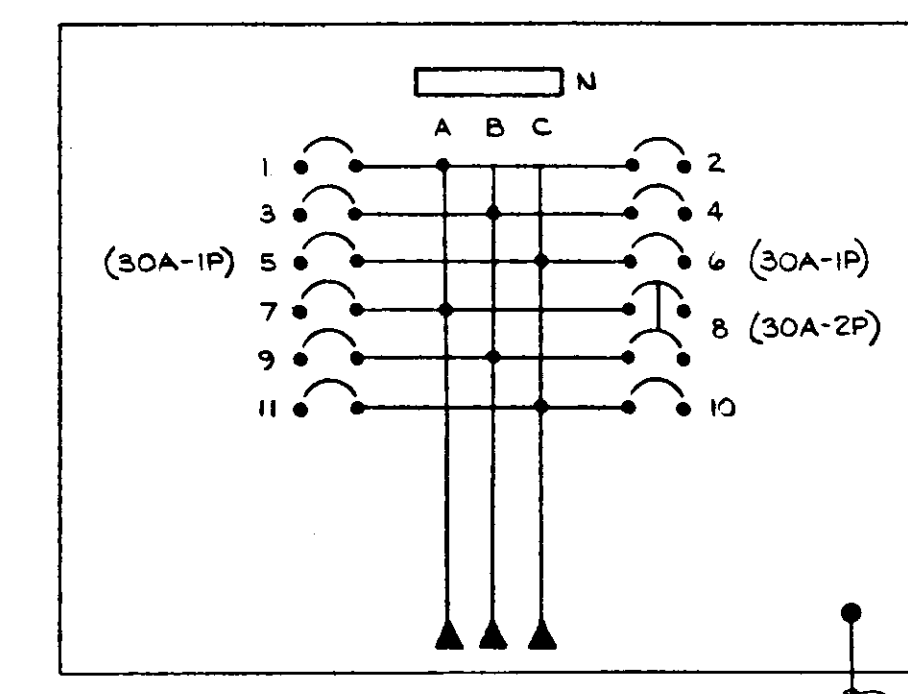

PANEL "CR"
 120/240V-3Ø-4WIRE
 RECESSED
 SEE PANELBOARD
 SCHEDULE FOR
 MAINS RATING.

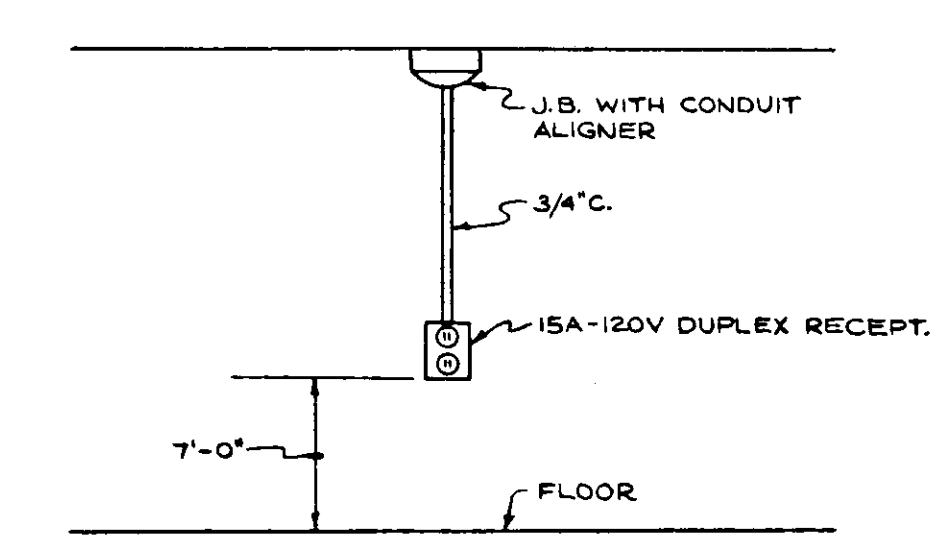

DROP RECEPTACLE DETAIL
 NO SCALE

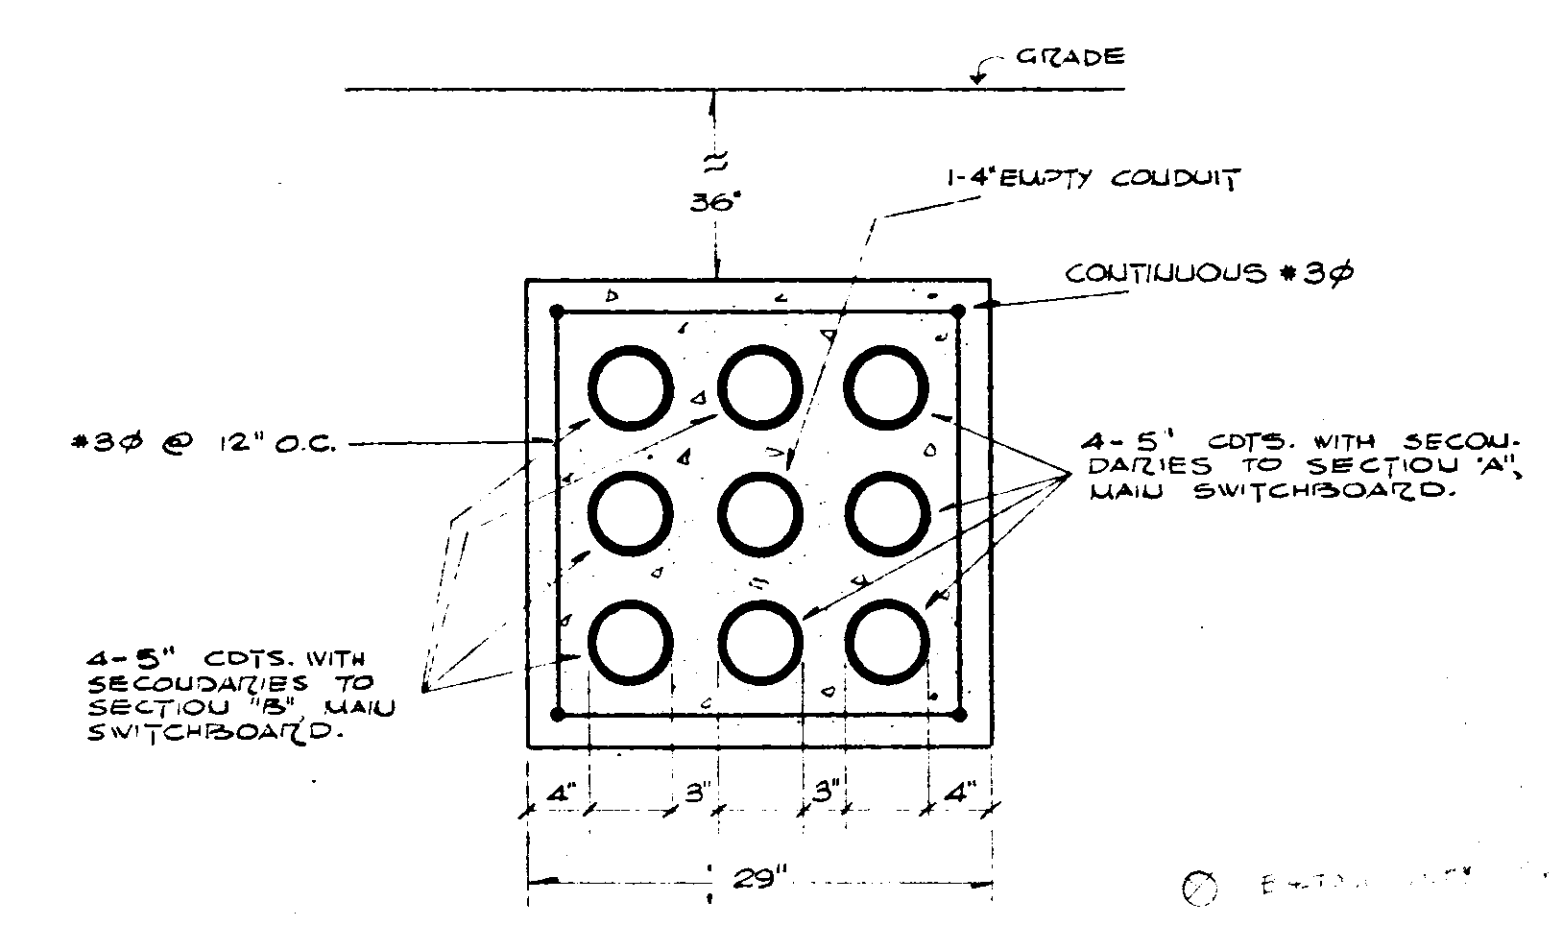

DUCTBANK DETAIL
 SCALE: 1"=1'-0"

- APRIL 18, 1972
- MARCH 7, 1972
- NOV. 1, 1971
- OCT. 1, 1971

ELECTRONIC CONTROL #
 -R1634-022-EB



ALLAN B. MITCHELL and ASSOCIATES ARCHITECTS PITTSBURGH, PA.

FIRST FLOOR - QUADRANT N° 4, LIGHTING PLAN
 RETAIL STORE and 23 CAR AUTO SERVICE
 SEARS ROEBUCK & COMPANY
 SECURITY SQUARE - BALTIMORE WEST, MARYLAND.

SCALE 1/8" = 1'-0"
 DATE AUGUST 16, 1971
 REVISED

DRAWING NUMBER
 E-8