
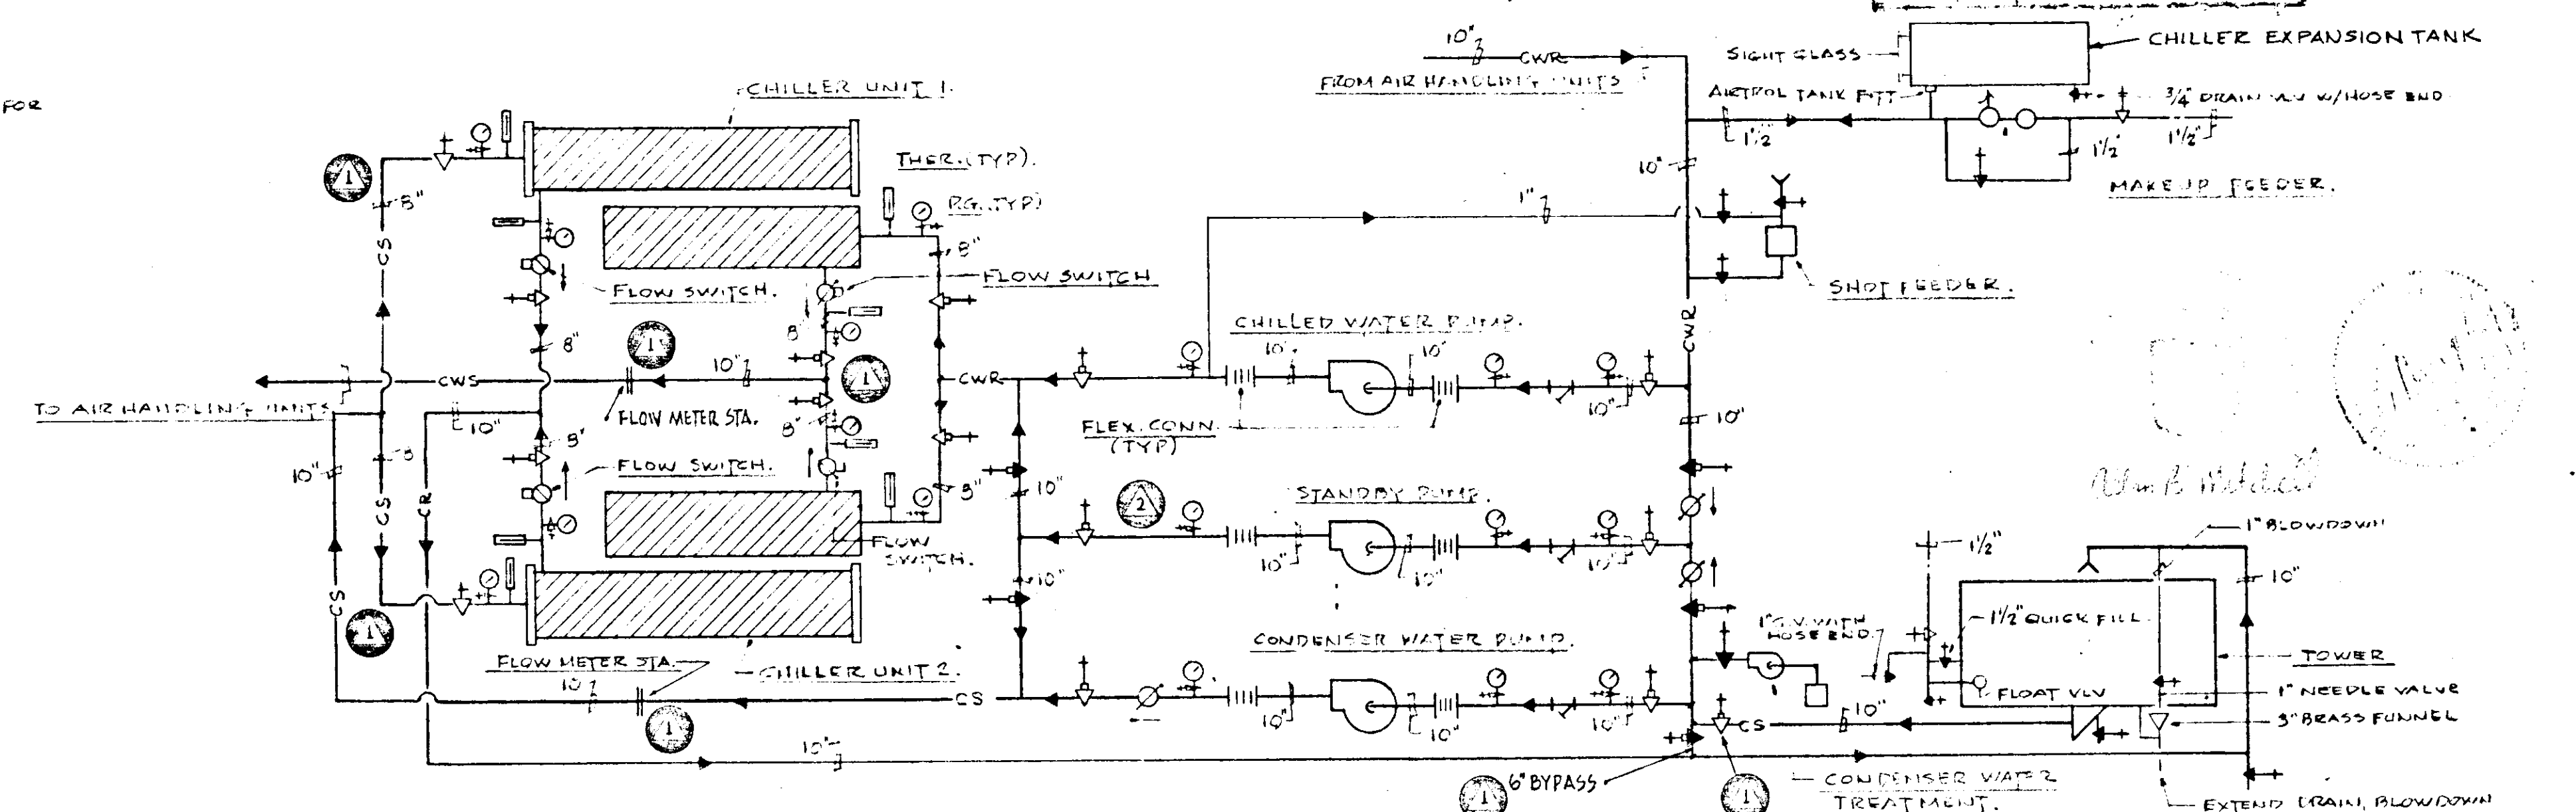
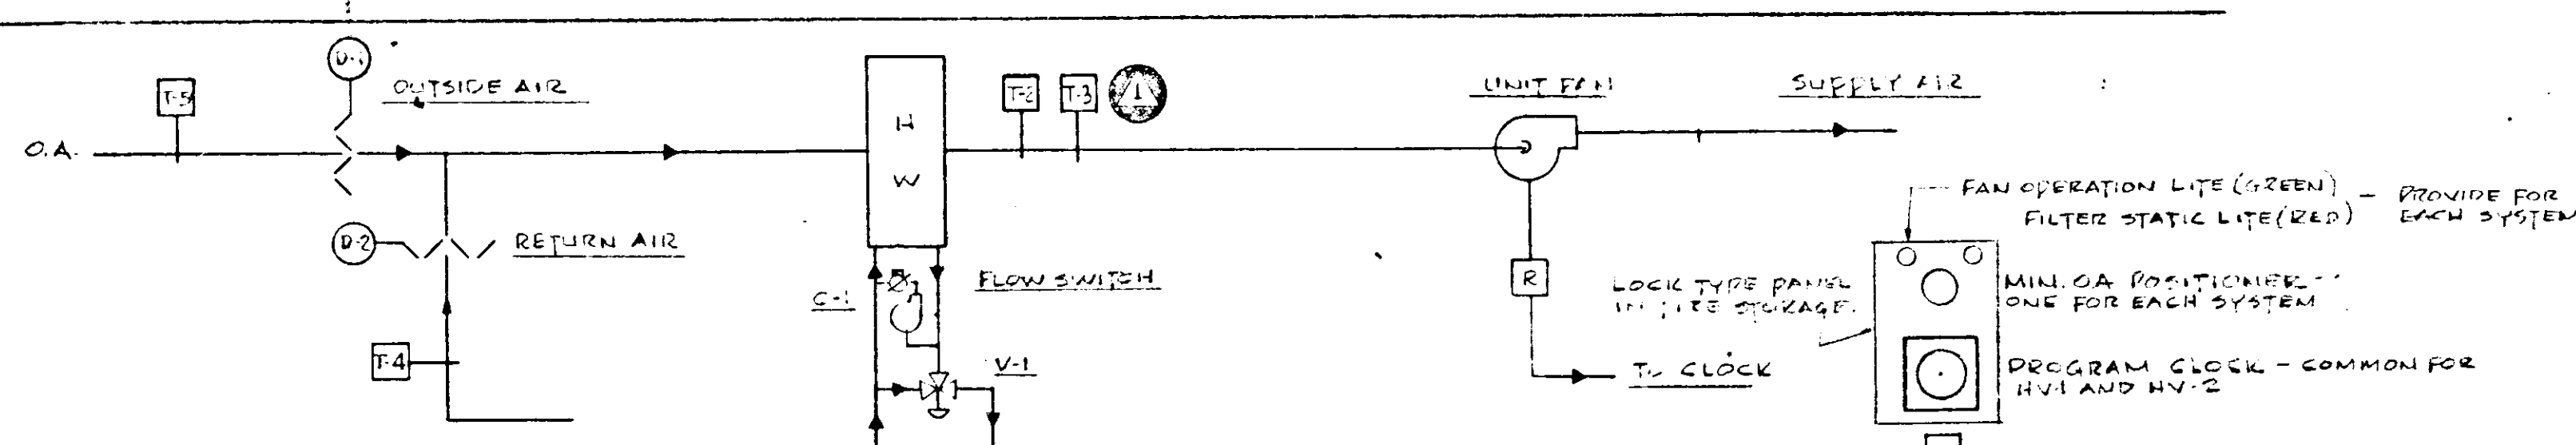
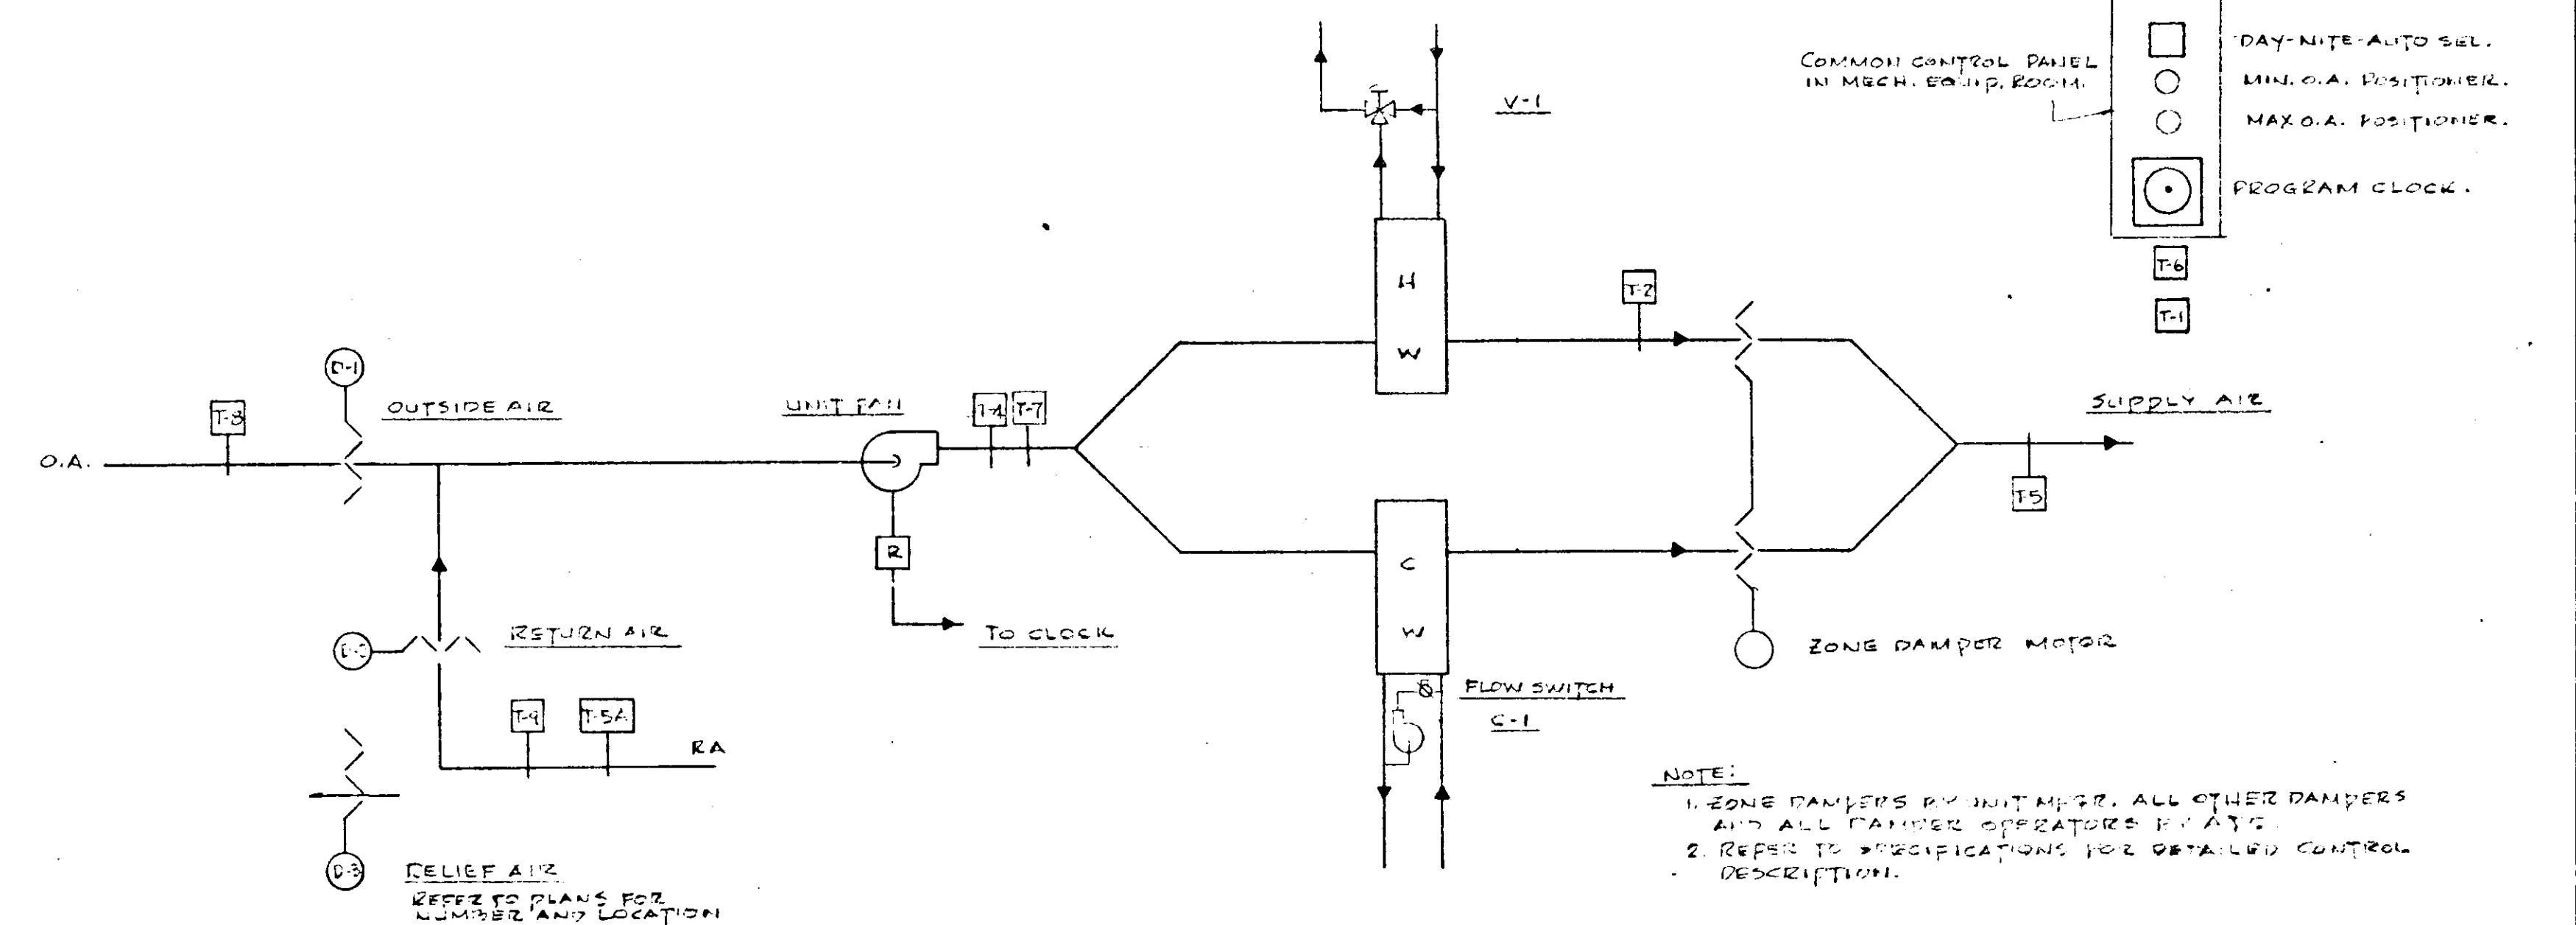
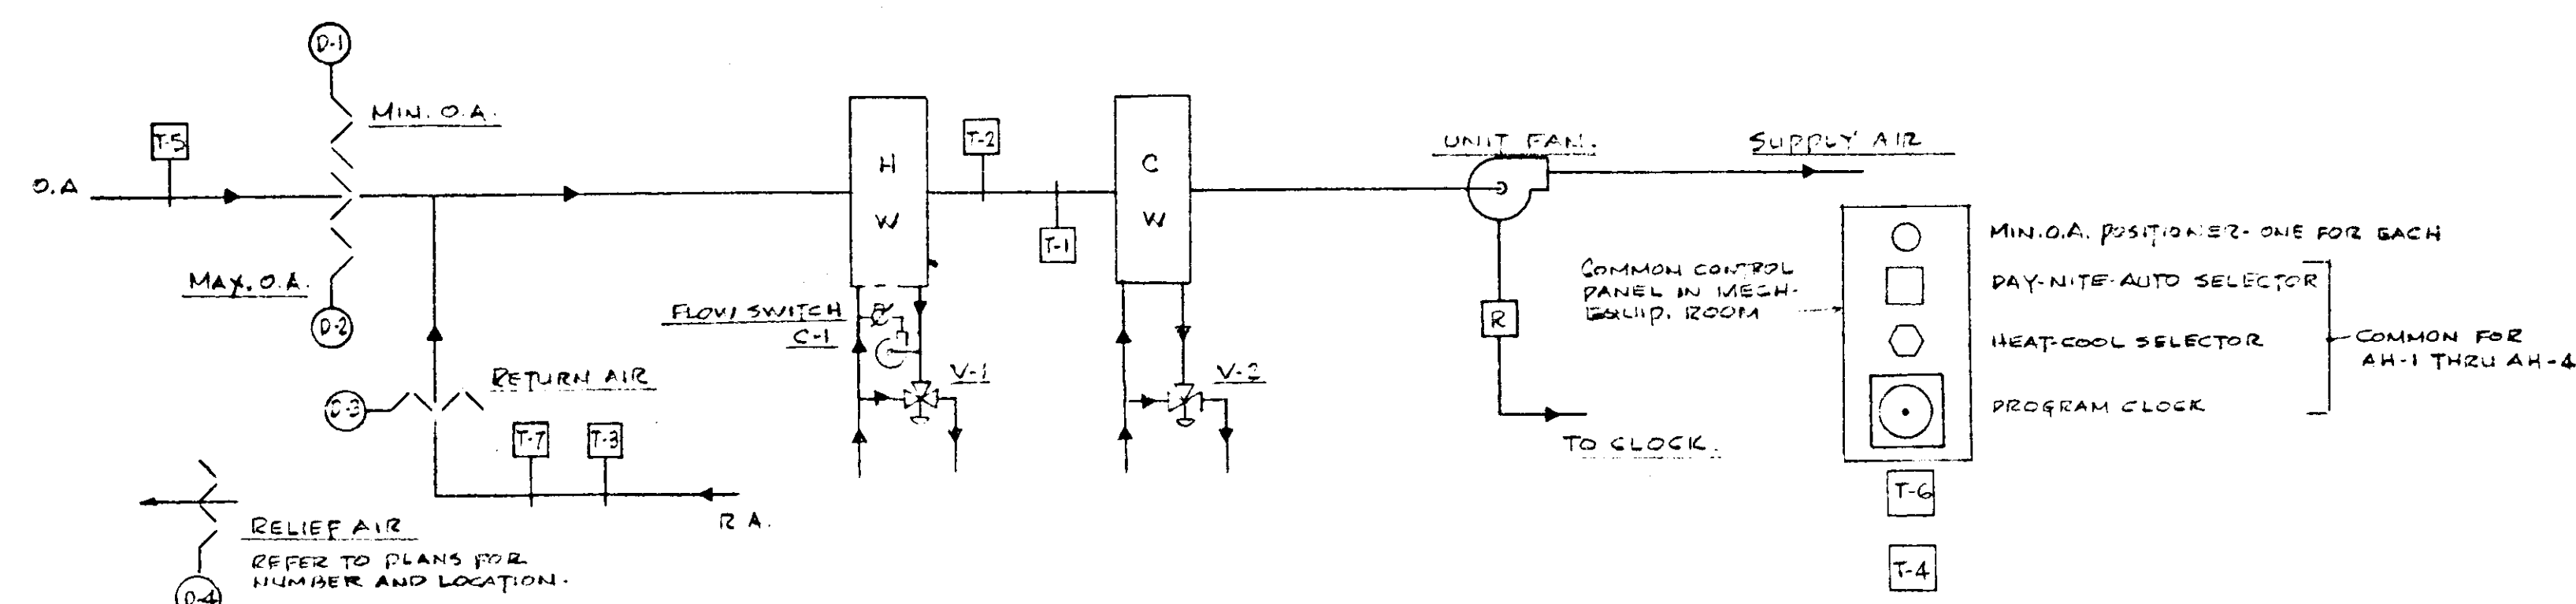


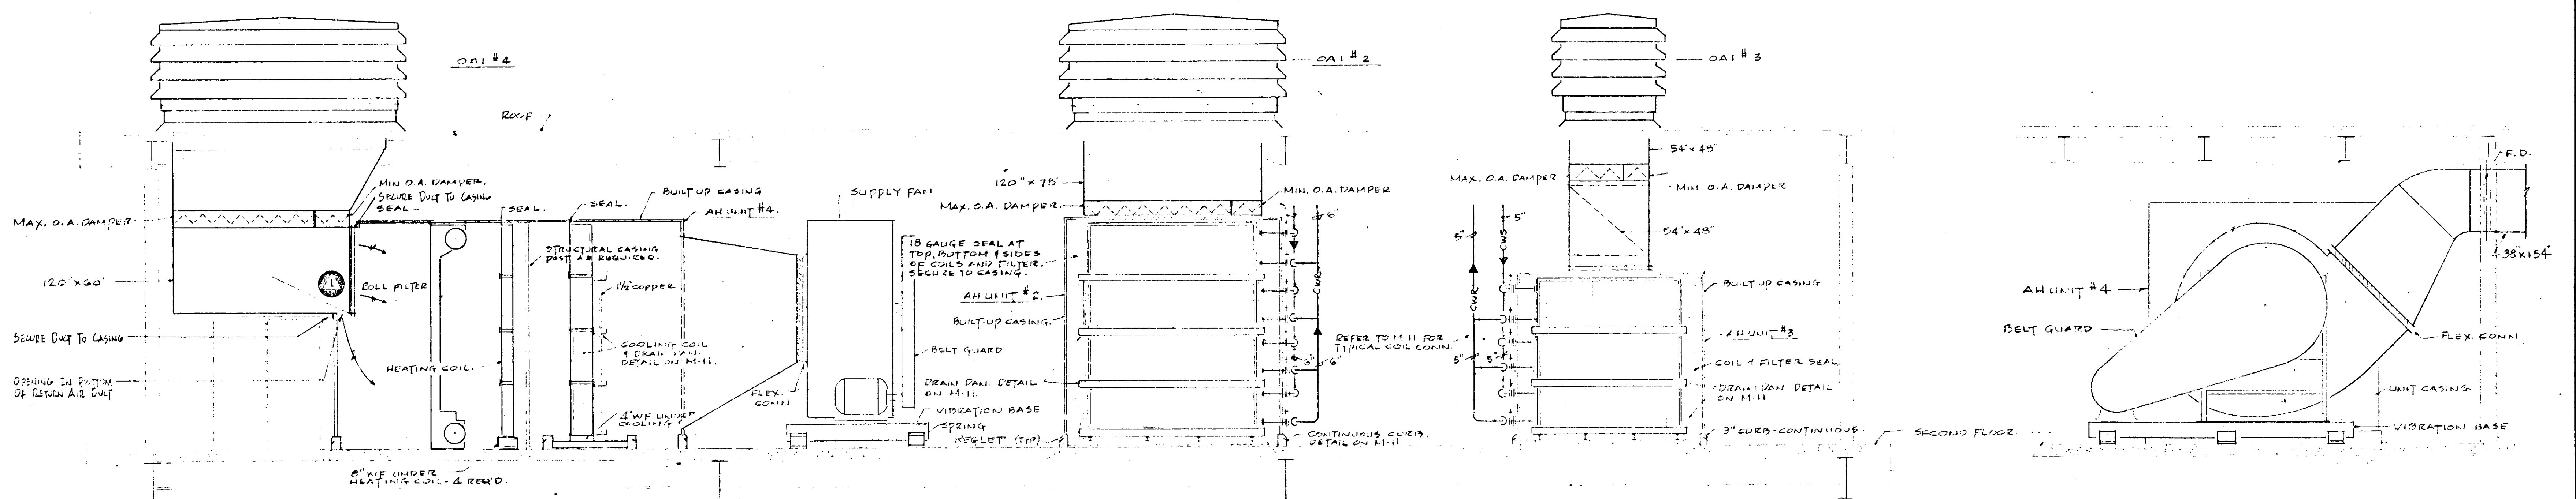

GARAGE & STORAGE UNITS - HV-1 & HV-2

SCHEMATIC CHILLED/CONDENSER WATER SYSTEM

ELECTRONIC CONTROL #
R1634 050 MID

OCT. 1, 1971 NOV. 1, 1971

MECHANICAL ROOM ELEVATION AND CONTROL DIAGRAMMATICS
RETAIL STORE and 23 CAR AUTO SERVICE
SEARS ROEBUCK & COMPANY
SECURITY SQUARE - BALTIMORE WEST, MARYLAND

SCALE AS NOTED
DATE AUG. 16, 1971
REVISED

DRAWING NUMBER
M-10