



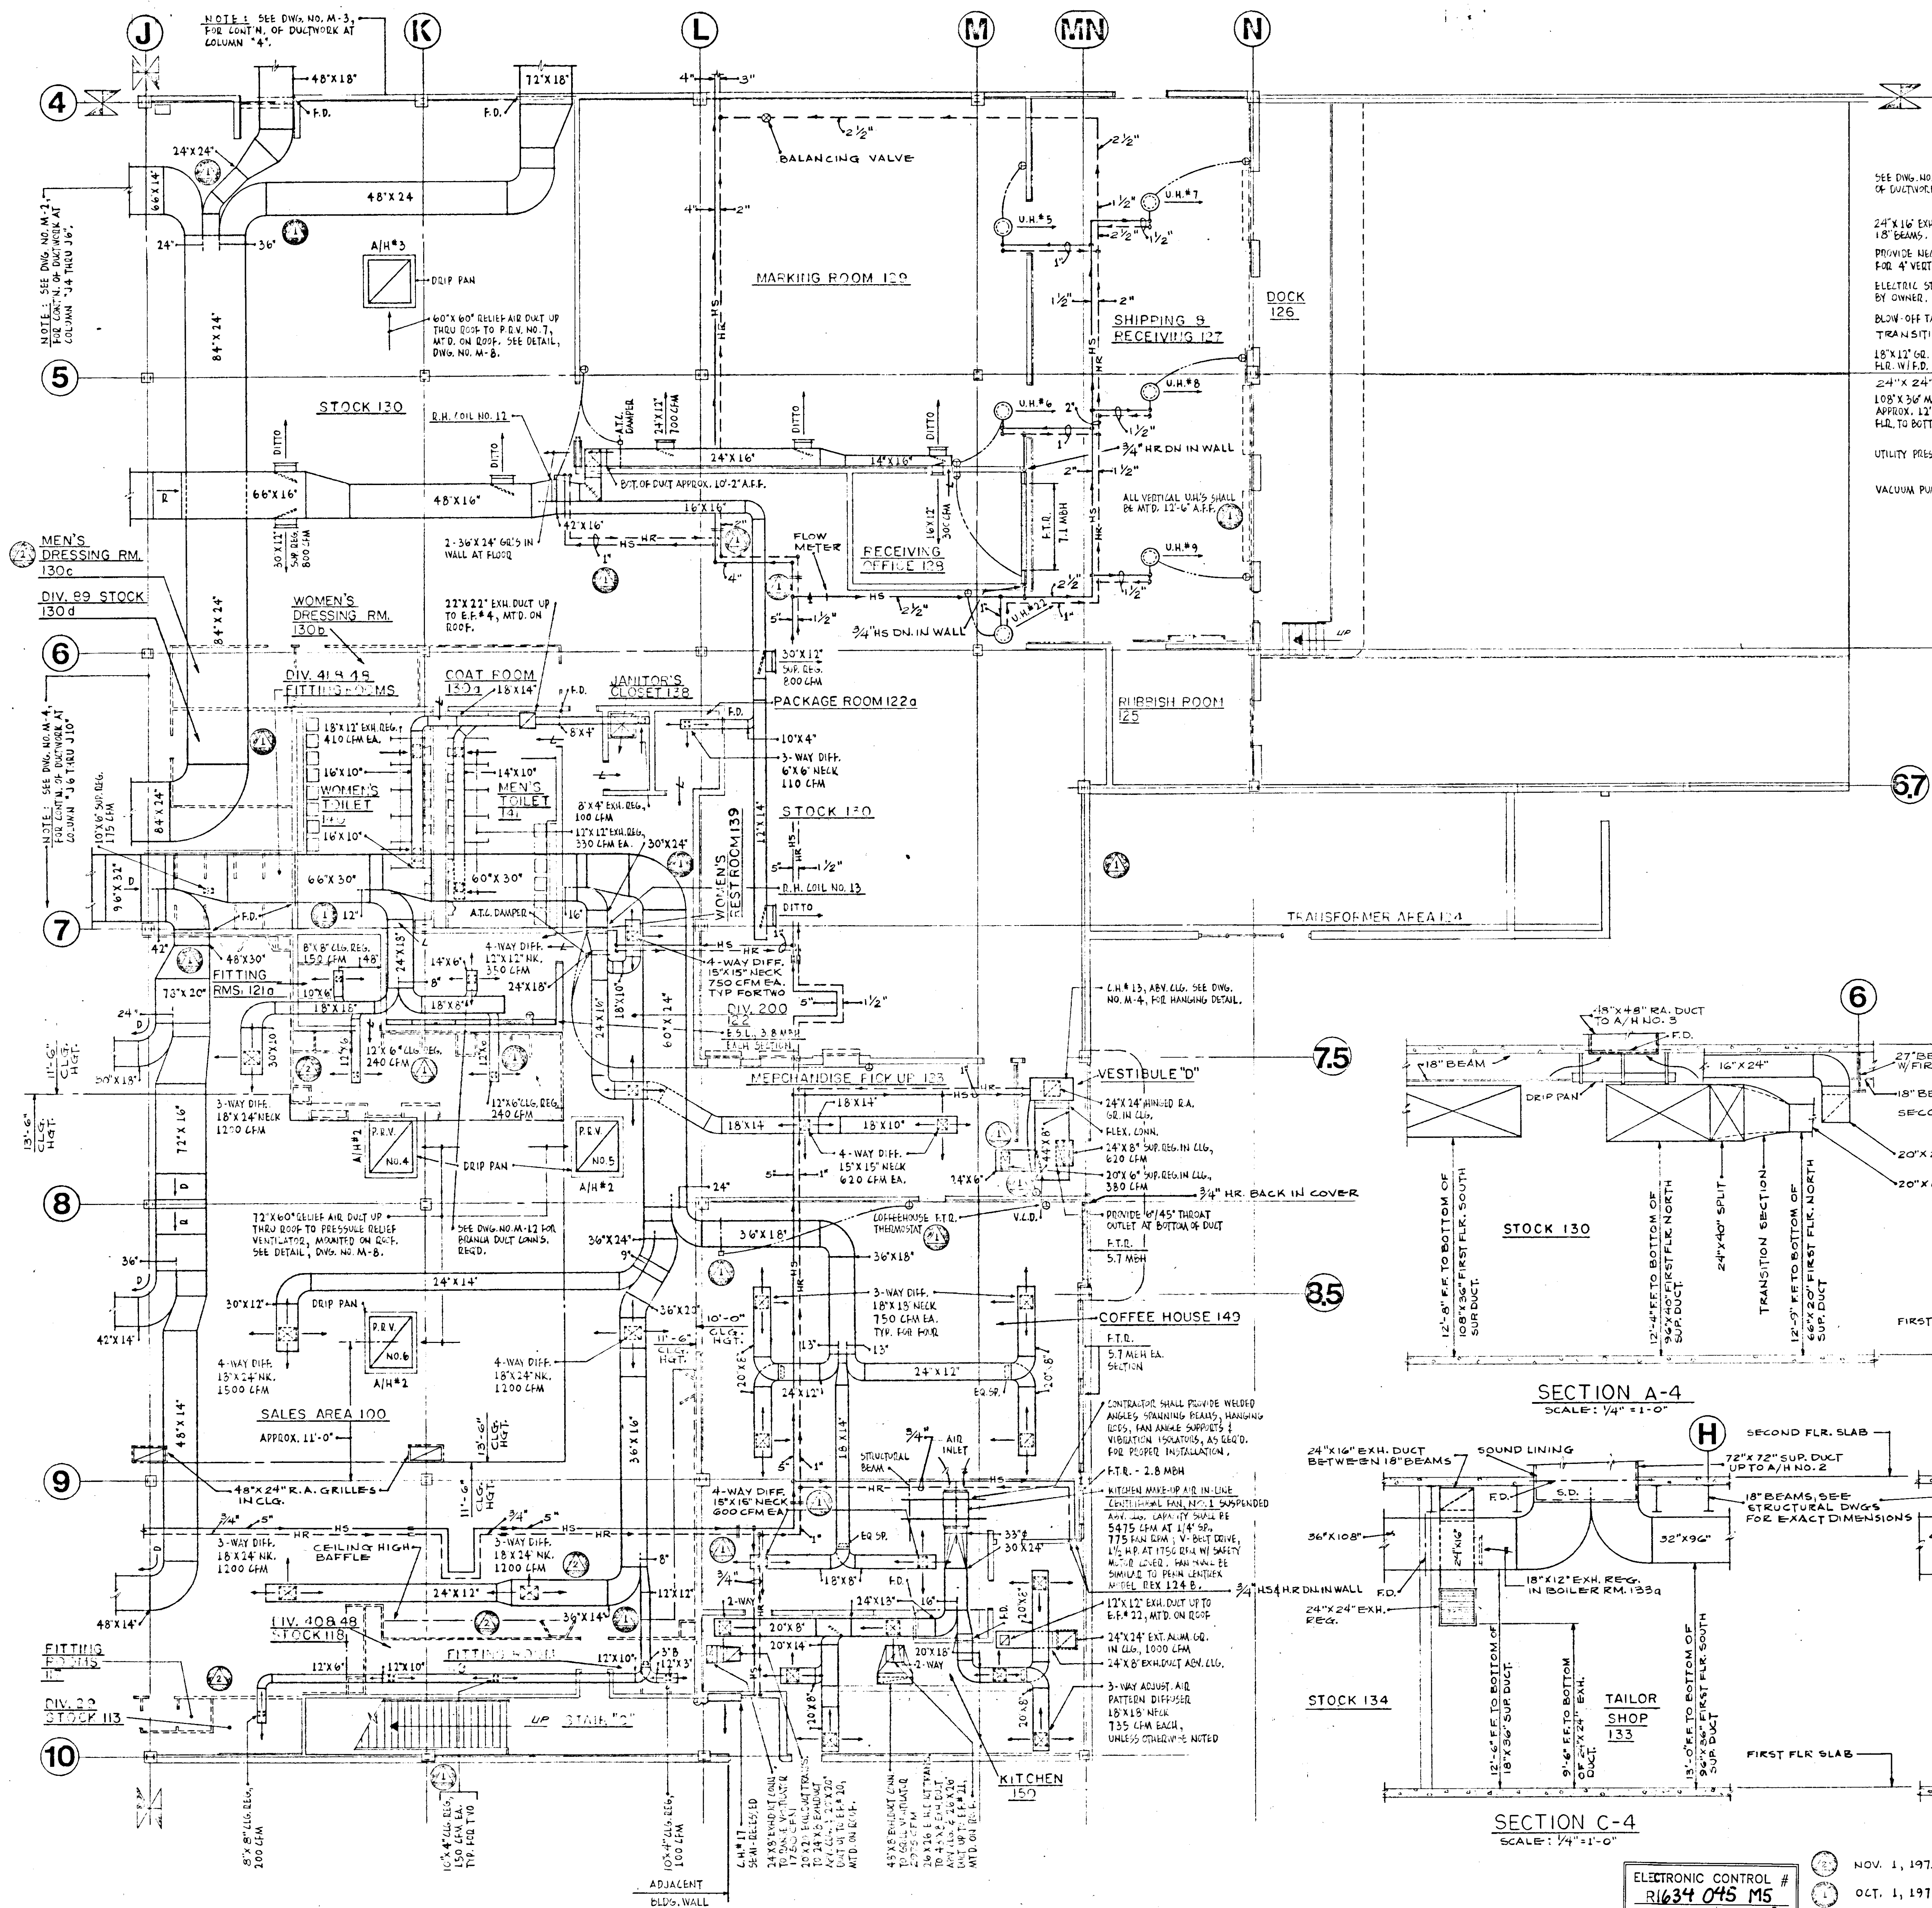

TAILOR SHOP 133 & BOILER ROOM 133A FLOOR PLAN
SCALE: 1/4" = 1'-0"

- NOTES:
- SEE DWG. NO. M-4, FOR FLOOR PLAN LOCATION OF TAILOR SHOP & BOILER RM.
 - SEE DWG. NO. M-13, FOR EXACT LOCATION OF EQUIPMENT & DIAGNOSTIC PIPING LAYOUT & PIPING SIZES.
 - SEE DWG. NO. P-4, FOR PLUMBING REQUIREMENTS.
 - SEE DWG. NOS. E-6 & E-7 FOR POWER & LIGHTING LAYOUT.
 - HVAC CONTRACTOR SHALL COORDINATE HIS WORK WITH THE OTHER TRADES. ALL EQUIPMENT SHALL BE FURNISHED BY THE OWNER, UNLESS OTHERWISE NOTED.

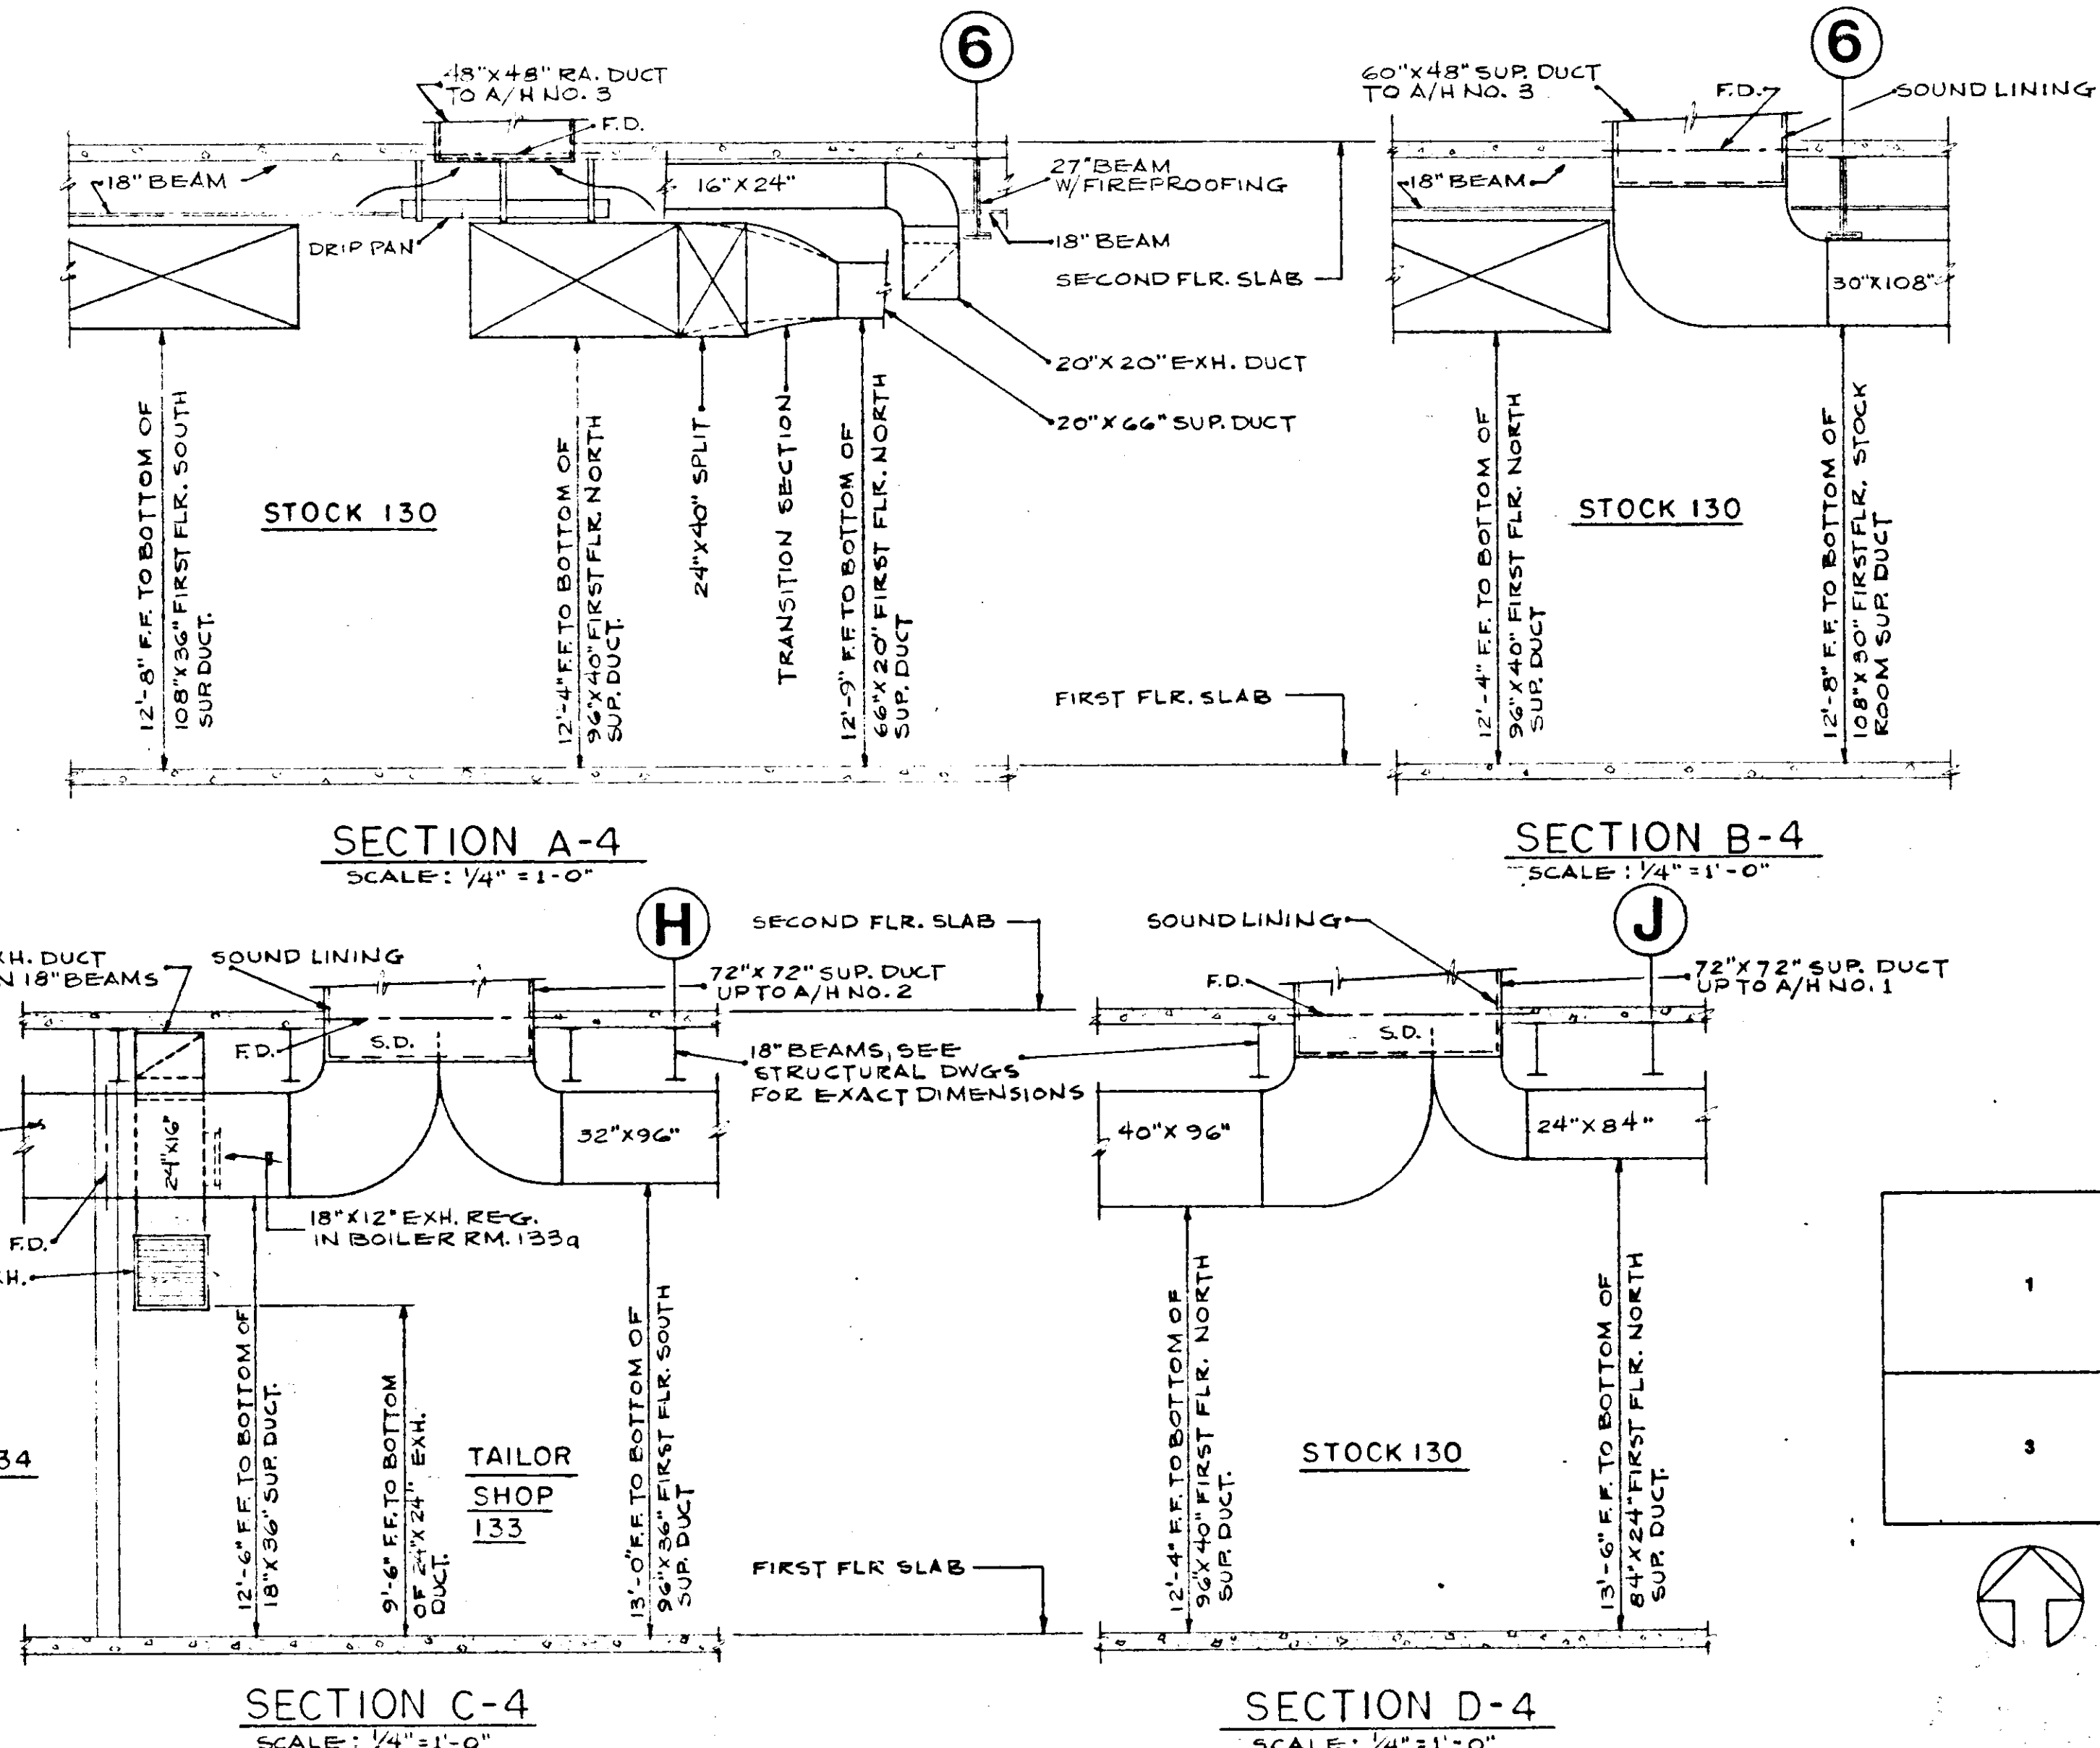

ELECTRONIC CONTROL #
R1634 045 M5

NOV. 1, 1971
OCT. 1, 1971

FIRST FLOOR-QUADRANT NO. 4
RETAIL STORE and 23 CAR AUTO SERVICE
SEARS ROEBUCK & COMPANY
SECURITY SQUARE - BALTIMORE WEST, MARYLAND

SCALE 1/8" = 1'-0"
DATE AUG. 16, 1971
REVISED

DRAWING NUMBER
M-5

ALLAN B. MITCHELL and ASSOCIATES ARCHITECTS PITTSBURGH, PA.