




NOTE:
ROOF OPENING & FLASHING BY GENERAL CONTRACTOR.
ROOF CURB CANT & COUNTER FLASHING BY H/V & AC
CONTRACTOR.

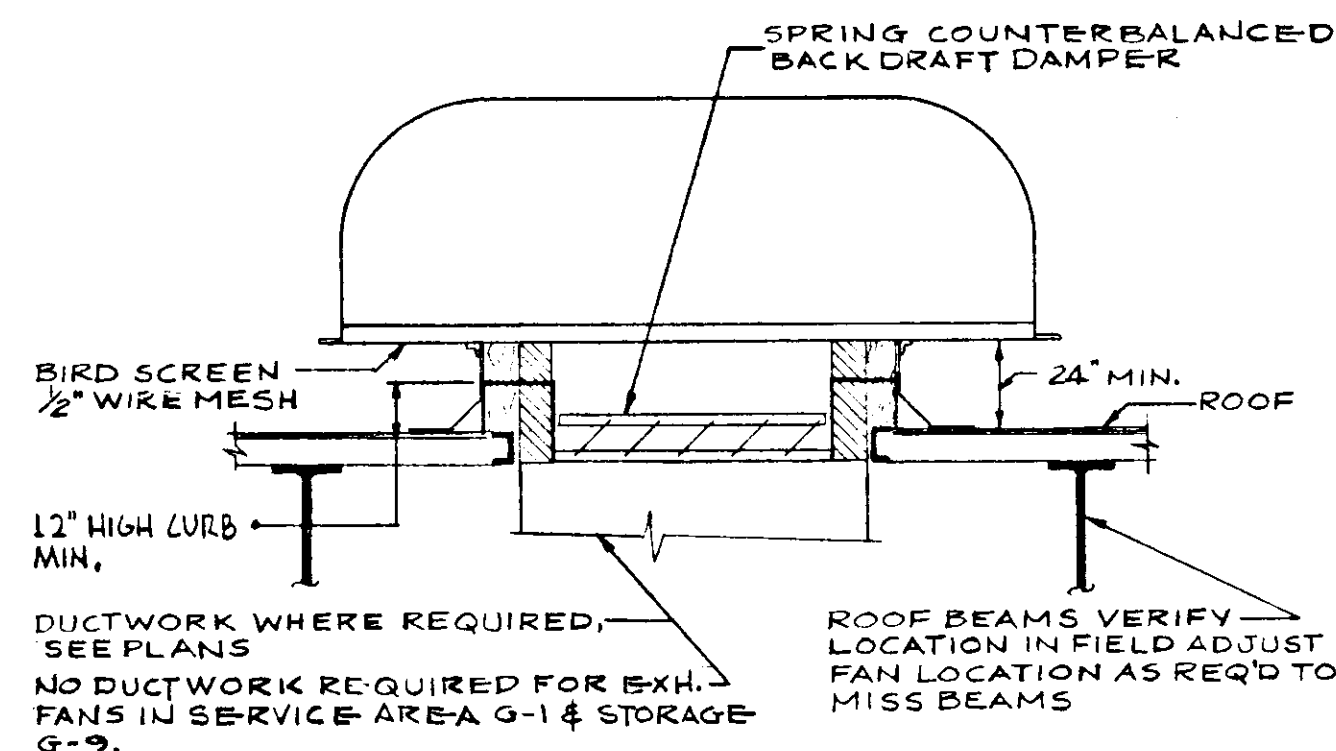

EXHAUST FAN MOUNTING DETAIL
NO SCALE

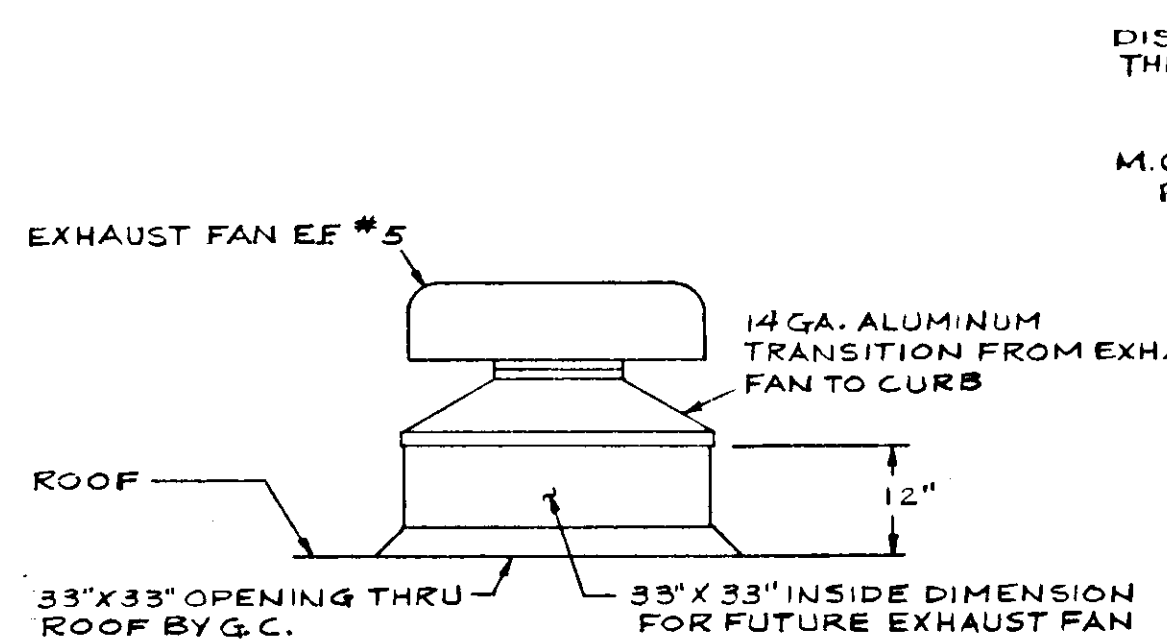


EXHAUST FAN NO. 5
MOUNTING DETAIL
NO SCALE

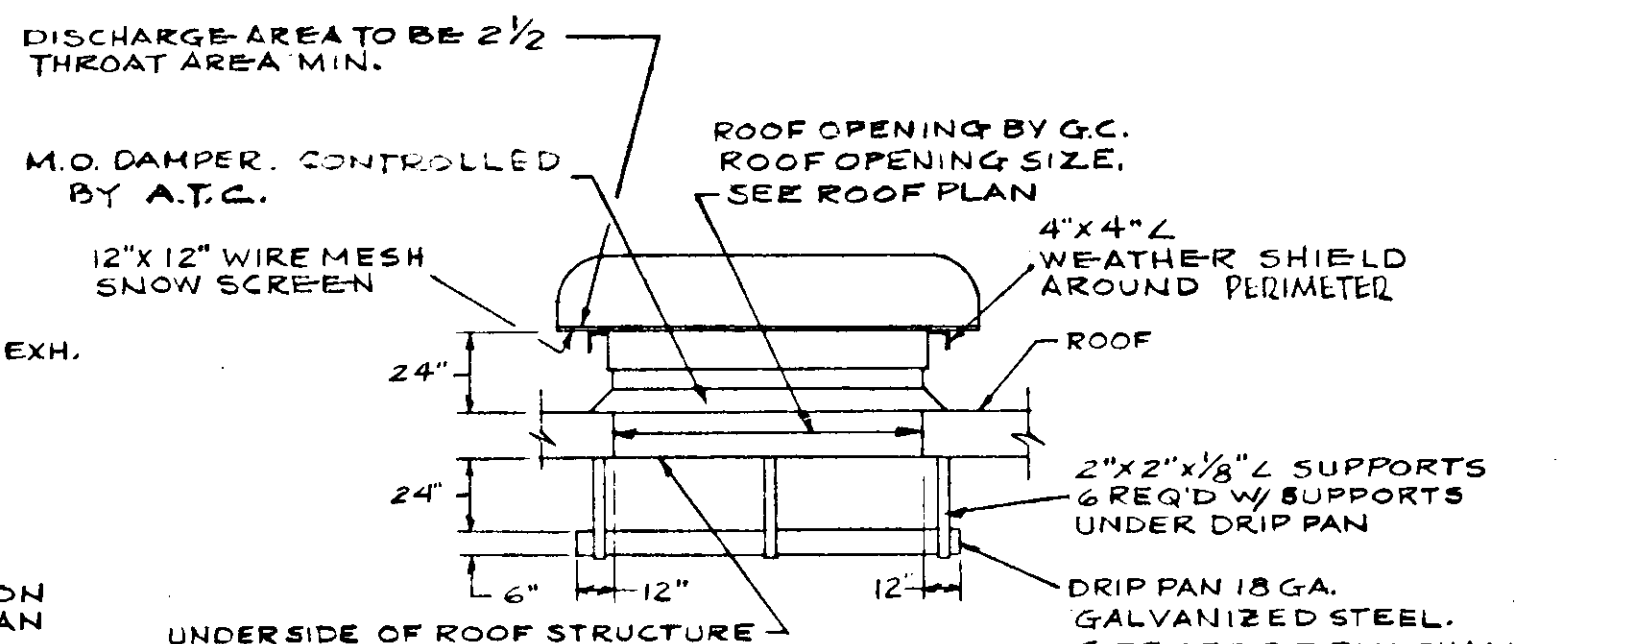

PRESSURE RELIEF VENTILATOR DETAIL

NO SCALE
NOTE: HVAC CONTRACTOR SHALL INSULATE ALL SPRINKLER MAINS &
BRANCHES WITHIN 20'-0" OF ALL PRESSURE
RELIEF VENTILATOR ROOF OPENINGS.

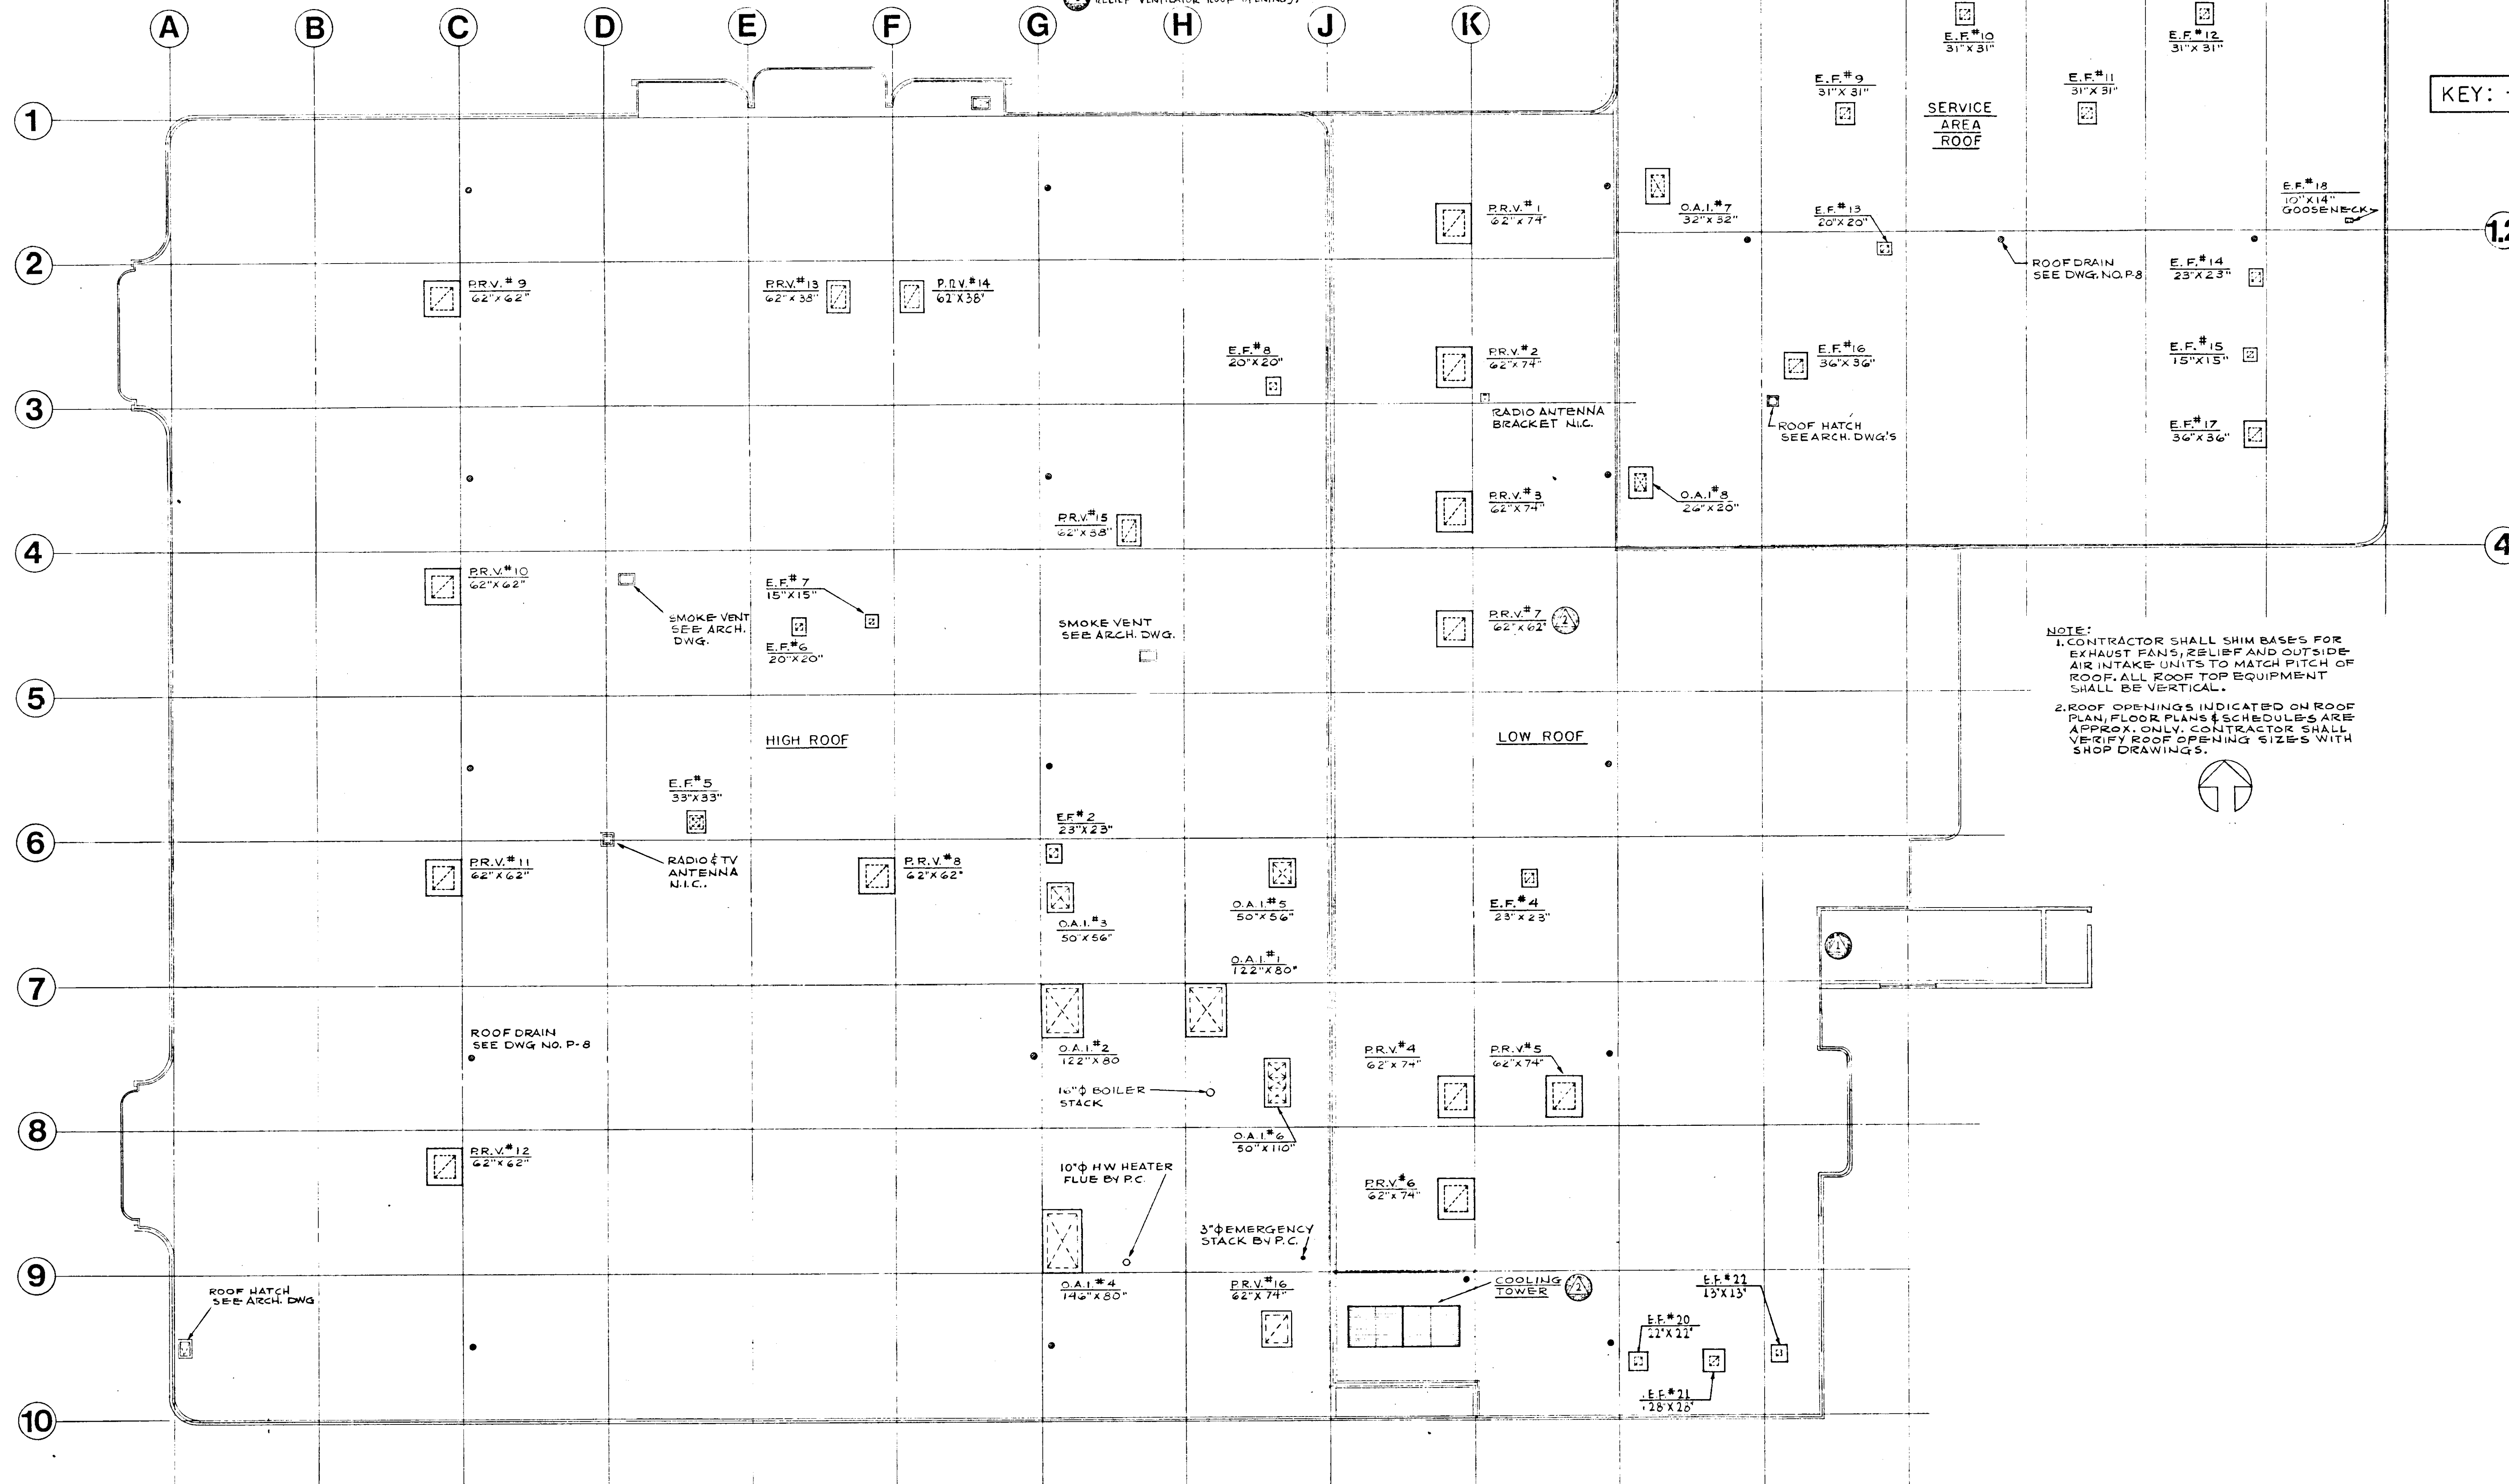

ROOF PLAN
SCALE 1/8" = 1'-0"


ELECTRONIC CONTROL #
R1634 048 MB

NOV. 1, 1971
OCT. 1, 1971

ROOF PLAN AND DETAILS
RETAIL STORE and 23 CAR AUTO SERVICE
SEARS ROEBUCK & COMPANY
SECURITY SQUARE - BALTIMORE WEST, MARYLAND

SCALE AS NOTED
DATE AUG. 16, 1971
REVISED

DRAWING NUMBER
M-8

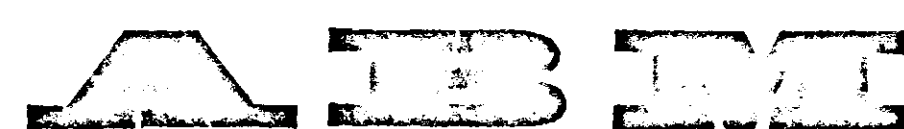

ALLAN B. MITCHELL and ASSOCIATES ARCHITECTS PITTSBURGH, PA.