




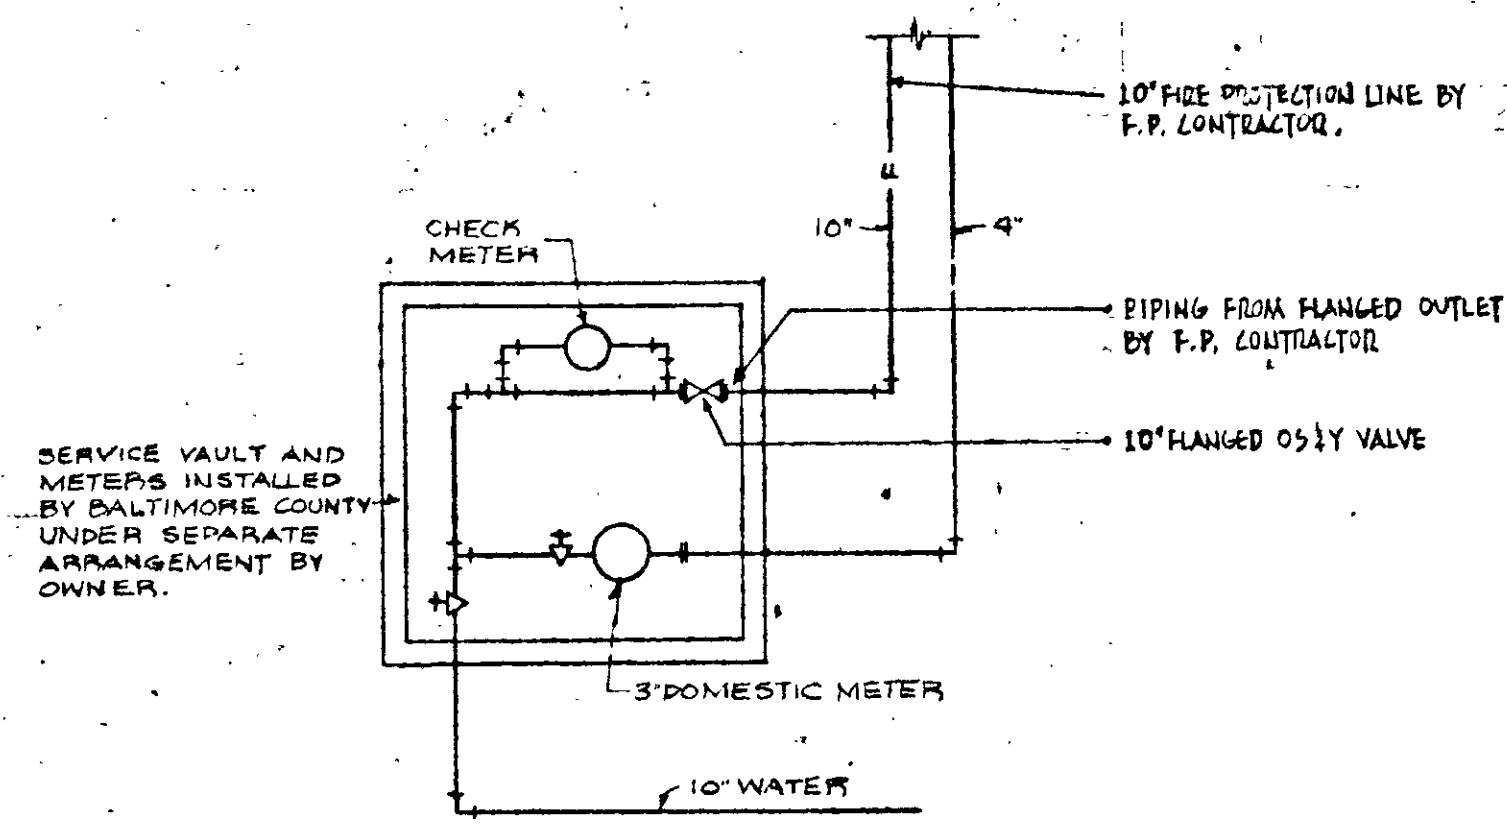

METER VAULT DETAIL
NO SCALE

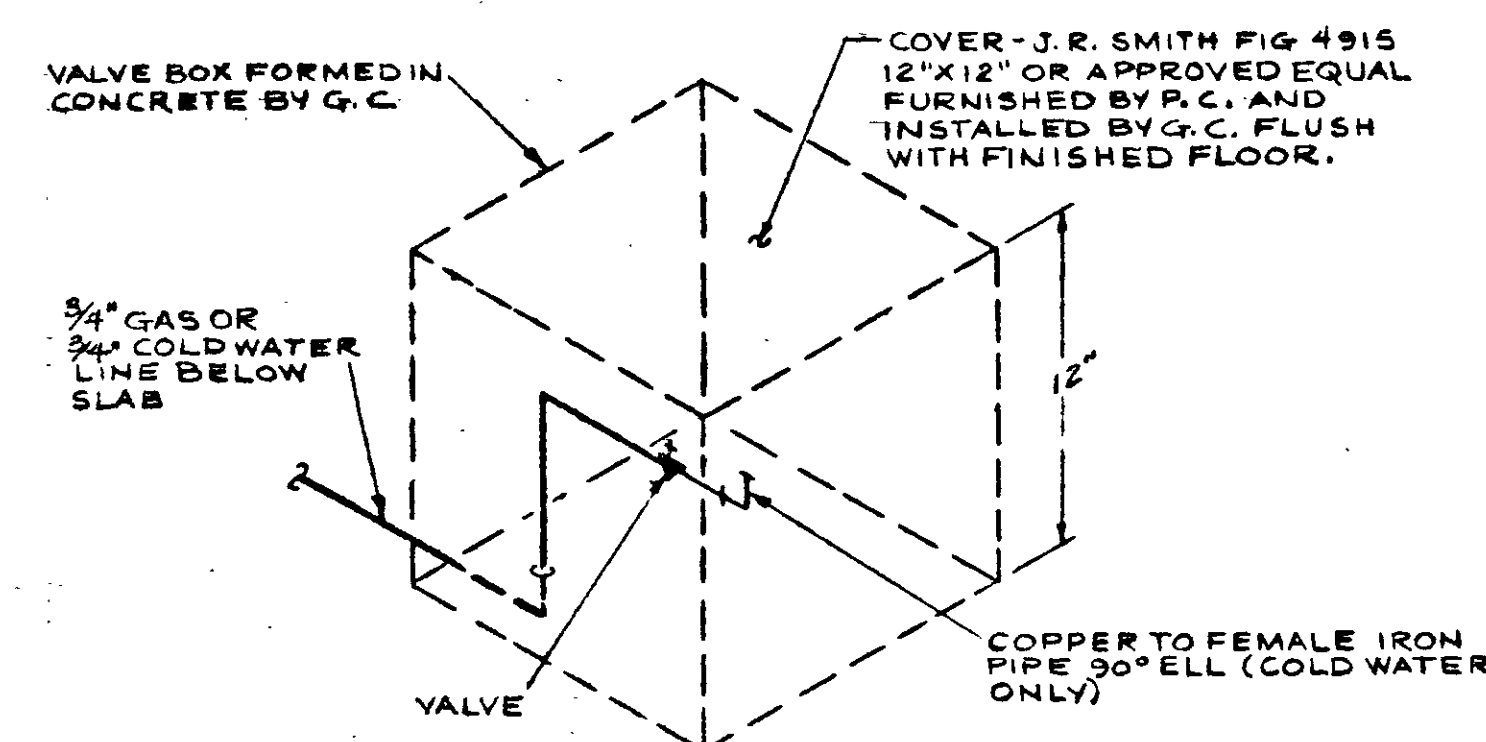

TYPICAL DETAIL - VALVE BOX IN FLOOR FOR GAS & WATER OUTLETS IN DISPLAY AREA (SEE PLAN FOR LOCATIONS)
NO SCALE

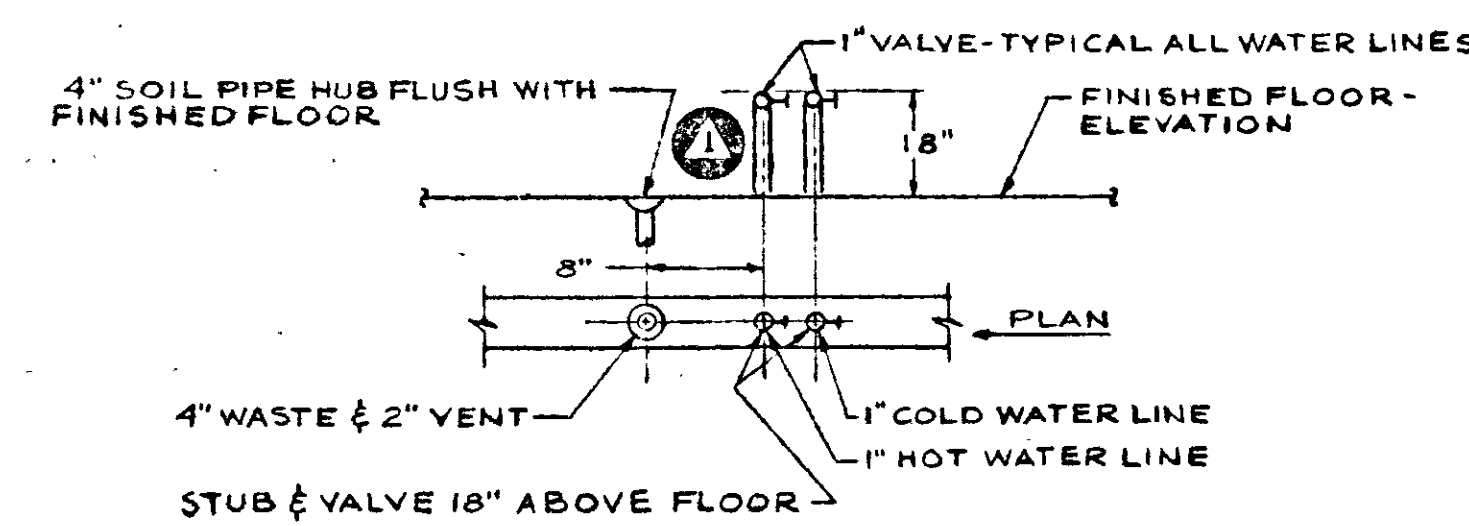


TYPICAL DETAIL - LAUNDRY DISPLAY PLUMBING
NO SCALE

PLUMBING FIXTURE SCHEDULE					
SYMBOL	DESCRIPTION	COLD WATER	HOT WATER	WASTE	VENT
WC	WATER CLOSET	1 1/4"	—	4"	2"
U	URINAL	1 1/4"	—	2"	2"
L-1	LAVATORY (TOILET ROOMS & FIRST AID)	1/2"	1/2"	1 1/2"	1 1/2"
L-2	LAVATORY (GENERAL)	1/2"	1/2"	1 1/2"	1 1/2"
SS-1	SERVICE SINK (AUTO CENTER)	1/2"	1/2"	3"	2"
SS-2	SERVICE SINK (GENERAL)	1/2"	1/2"	3"	2"
EW	ELECTRIC WATER COOLER	1/2"	—	1 1/2"	1 1/2"
FT	FLUSH TANK (AUTO CENTER)	1/2"	—	—	—
S	SHOWER	1/2"	1/2"	2"	1 1/2"
WF	WASH FOUNTAIN	1"	1"	2"	2"
FS-1	FLOOR SINK	3/4"	3/4"	3"	2"

PLUMBING LEGEND

- SANITARY
- VENT PIPE AT CEILING
- STORM WATER
- COLD WATER
- HOT WATER
- 180° HOT WATER
- RECIRCULATED WATER
- TEMPERED WATER
- GAS
- ANCHOR
- ALIGNMENT GUIDE
- F.D. FLOOR DRAIN
- F.S. FLOOR SINK
- R.D. ROOF DRAIN
- BWV BACK WATER VALVE
- H.W. WALL HYDRANT (MOUNT 2'-0" ABOVE FINISH GRADE)
- H.B. HOSE BIBB (MOUNT 2'-0" ABOVE FINISHED FLOOR)
- GATE VALVE
- CLEAN OUT
- BALANCING COCK
- SHOWER HEAD
- HT HIGH TEST
- RL RAIN LEADER
- V VENT
- VTR VENT THRU ROOF
- AP ACCESS PANEL

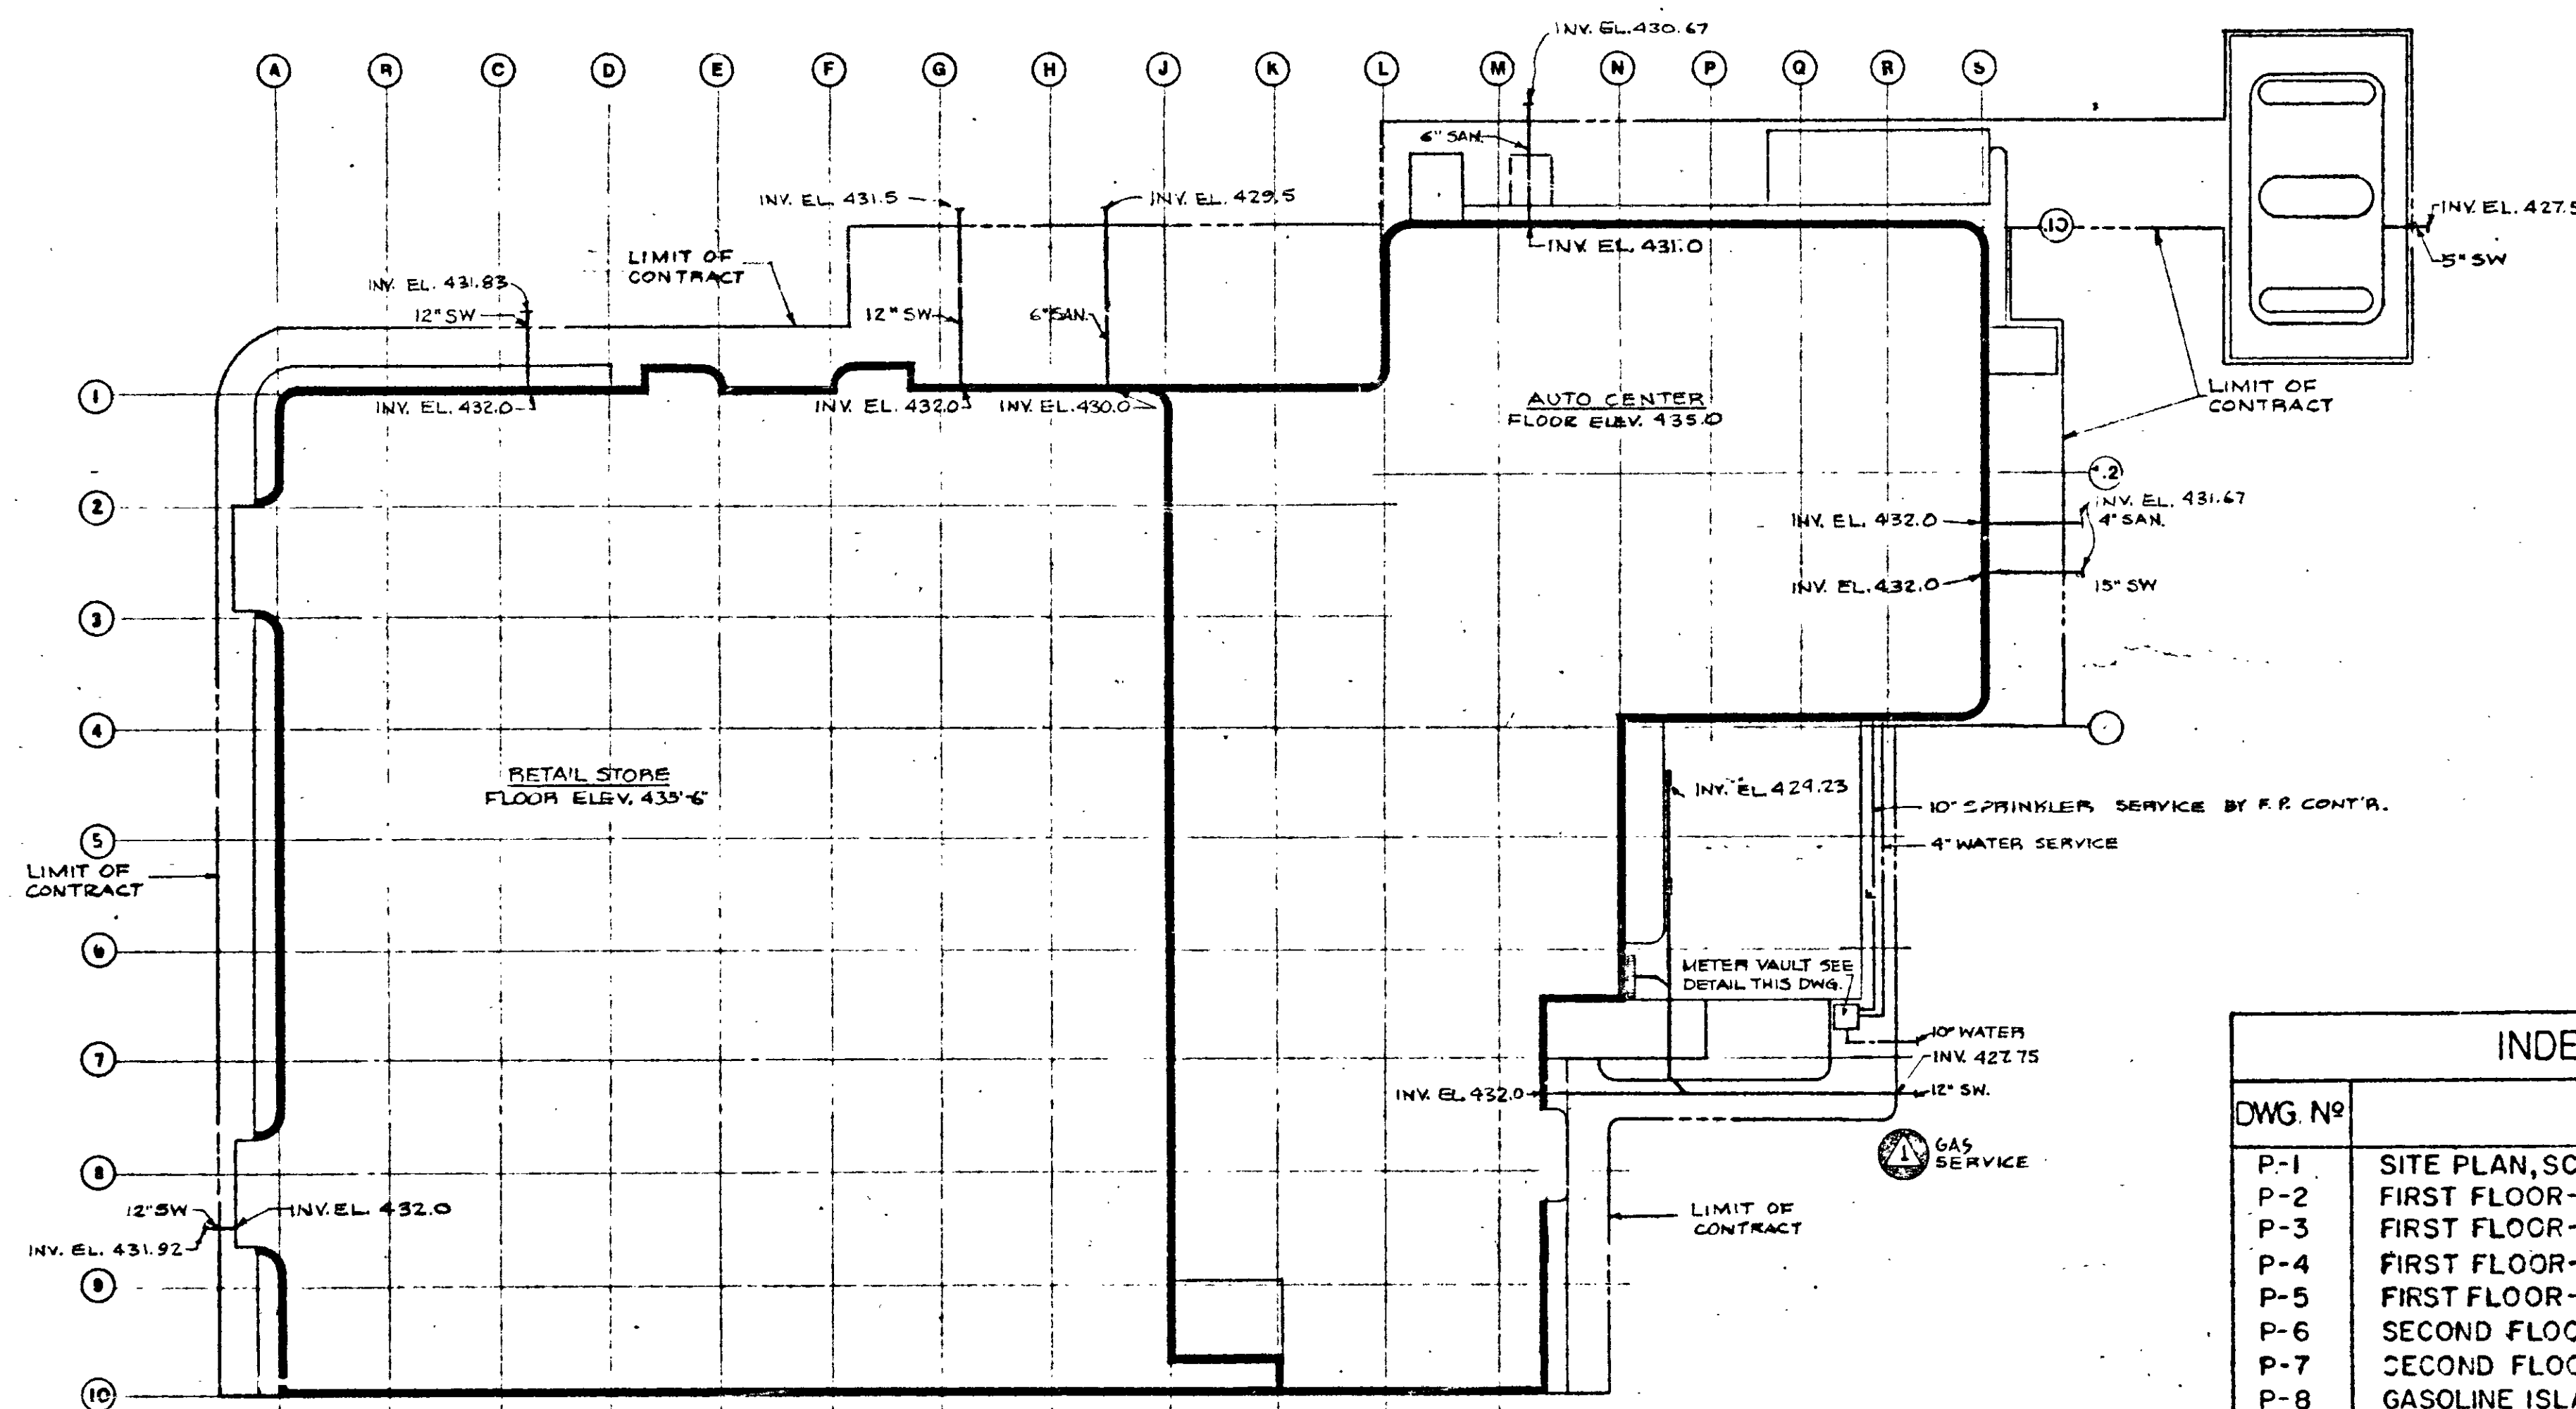

SITE PLAN
SCALE: 1/4" = 1'-0"

INDEX OF PLUMBING DRAWINGS	
DWG. NO.	TITLE
P-1	SITE PLAN, SCHEDULE, DETAILS AND LEGEND
P-2	FIRST FLOOR - QUADRANT NO. 1
P-3	FIRST FLOOR - QUADRANT NO. 2
P-4	FIRST FLOOR - QUADRANT NO. 3
P-5	FIRST FLOOR - QUADRANT NO. 4
P-6	SECOND FLOOR - QUADRANT NO. 5
P-7	SECOND FLOOR - QUADRANT NO. 6
P-8	GASOLINE ISLAND AND STORAGE TANKS PLAN AND DETAILS
P-9	ROOF PLAN
P-10	TOILET ROOM PLANS - DETAILS AND RISERS
P-11	KITCHEN PLAN AND SCHEDULE
P-12	AUTOMOTIVE CENTER DETAILS

ELECTRONIC CONTROL #
R1634053 P1

OCT. 1, 1971