




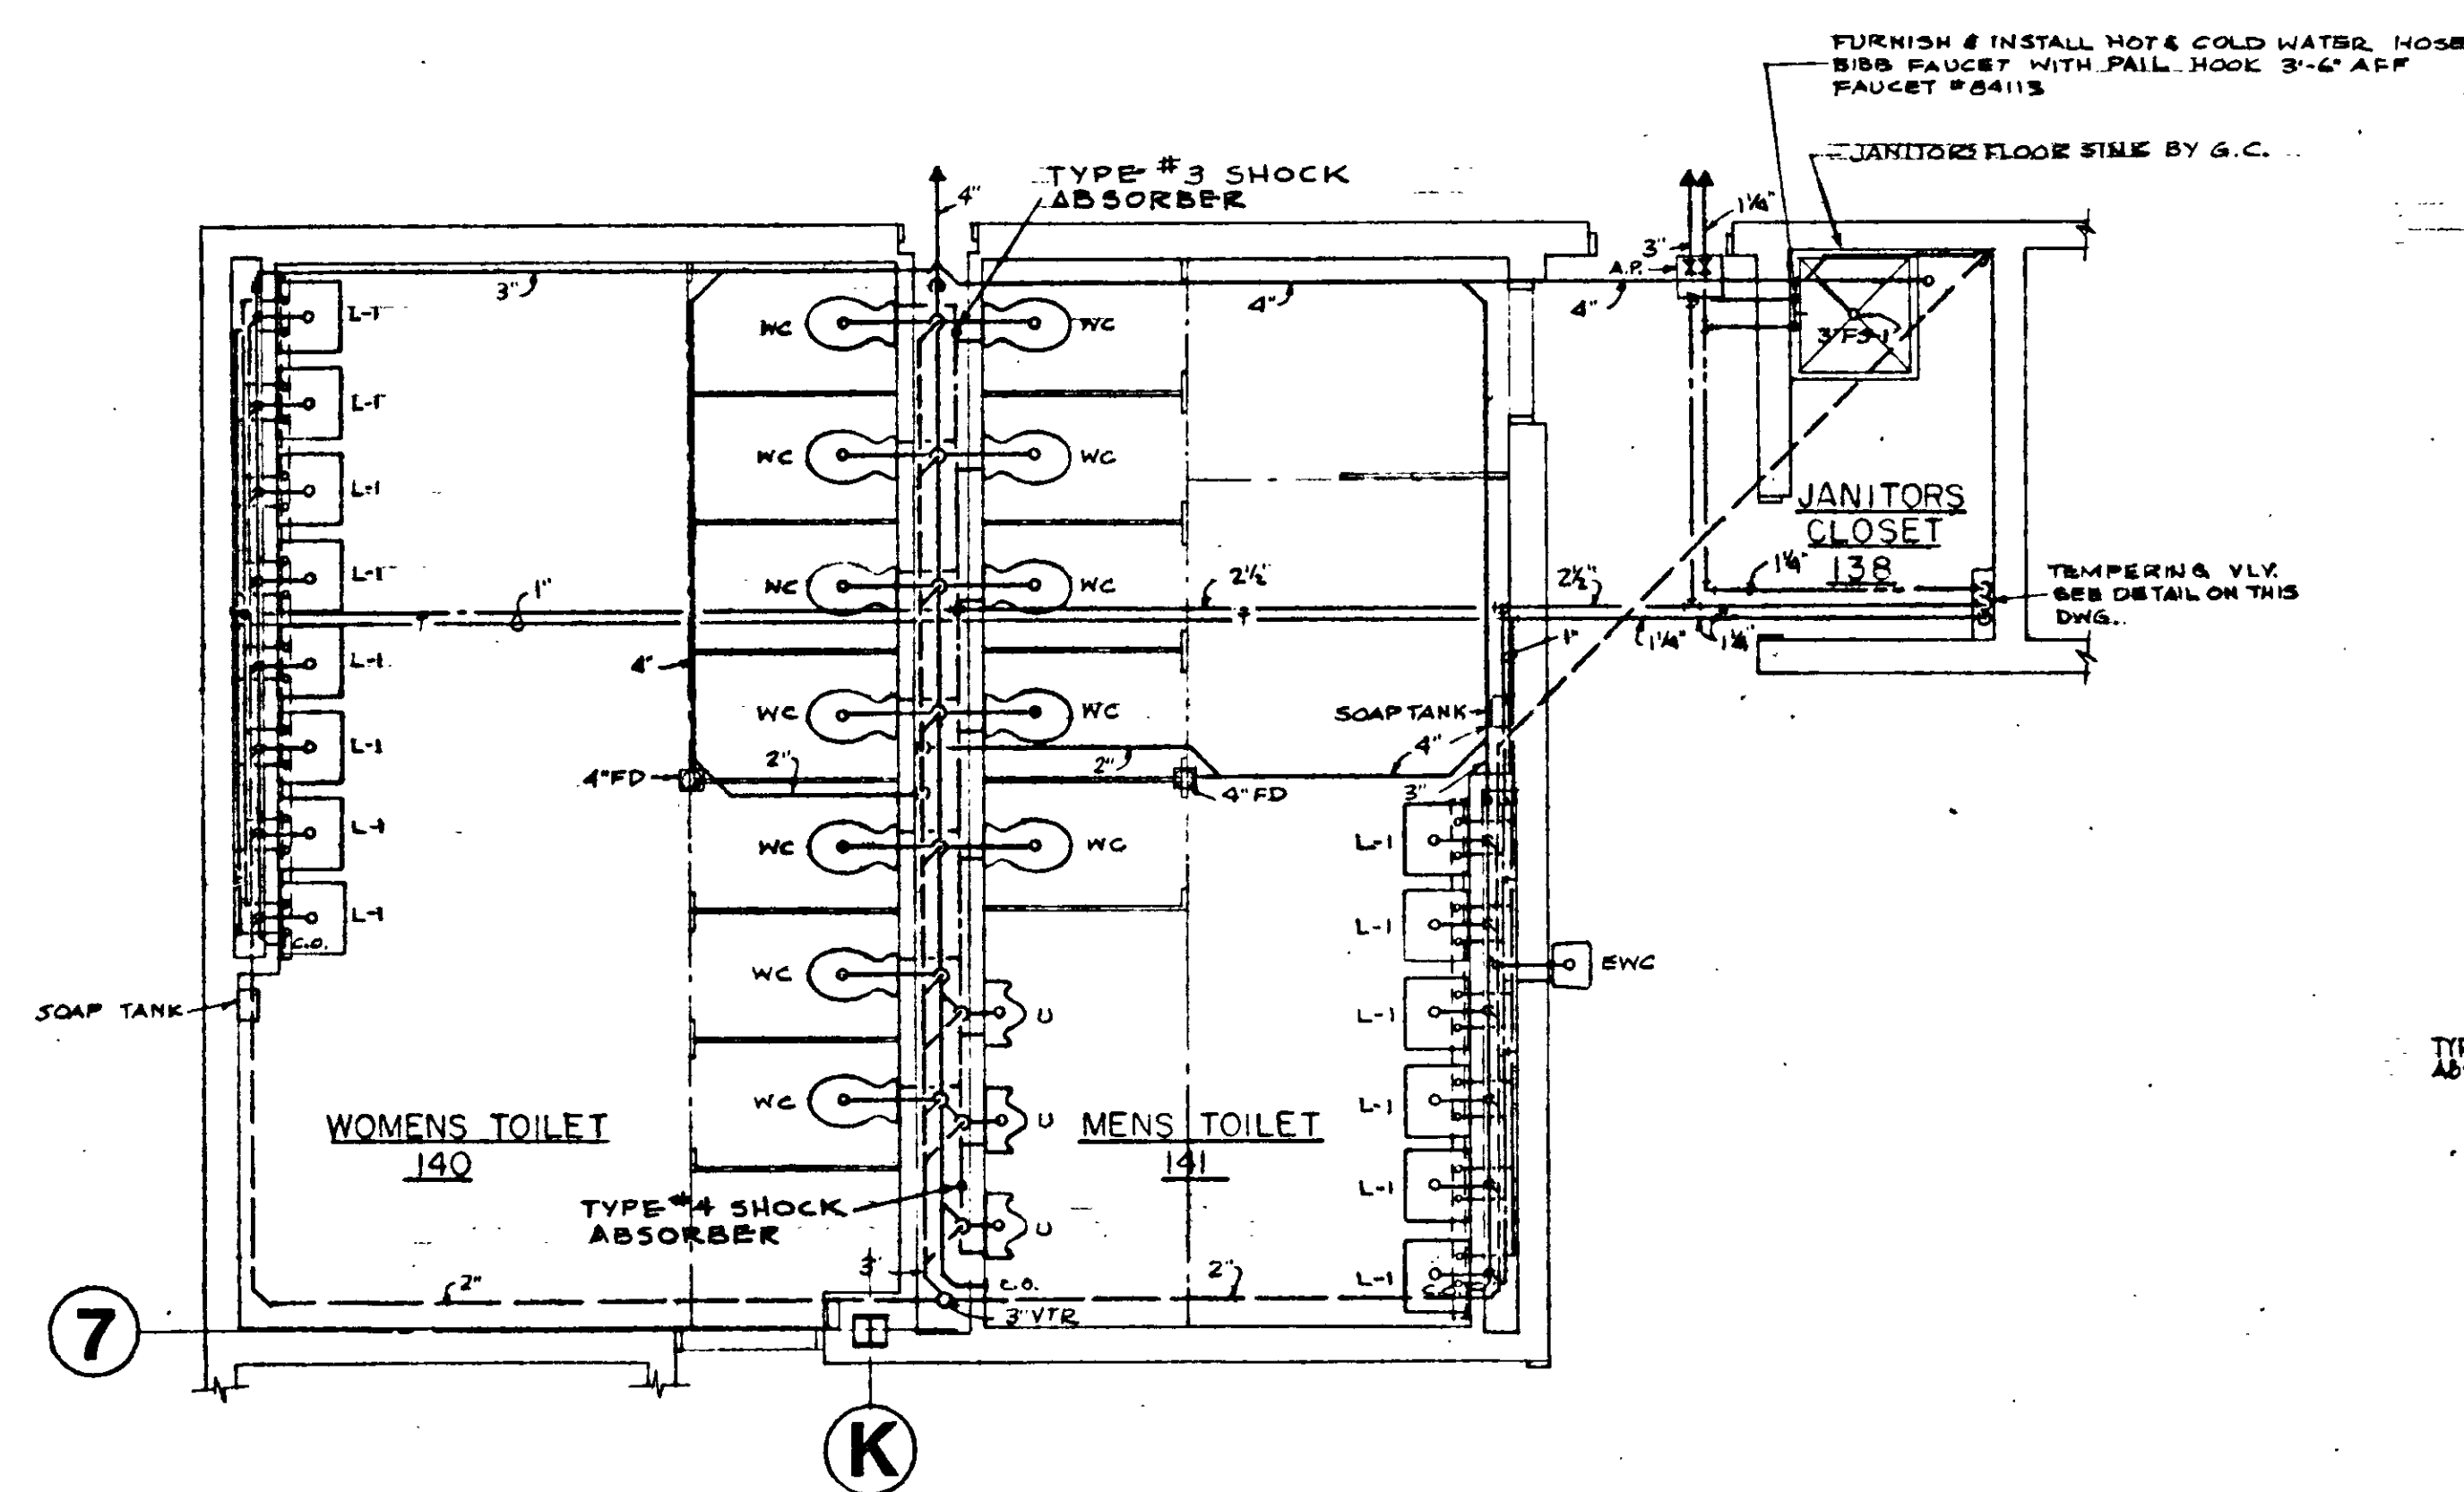


TOILET ROOM PLAN
FIRST FLOOR RETAIL STORE
SCALE: 1/4"=1'-0"

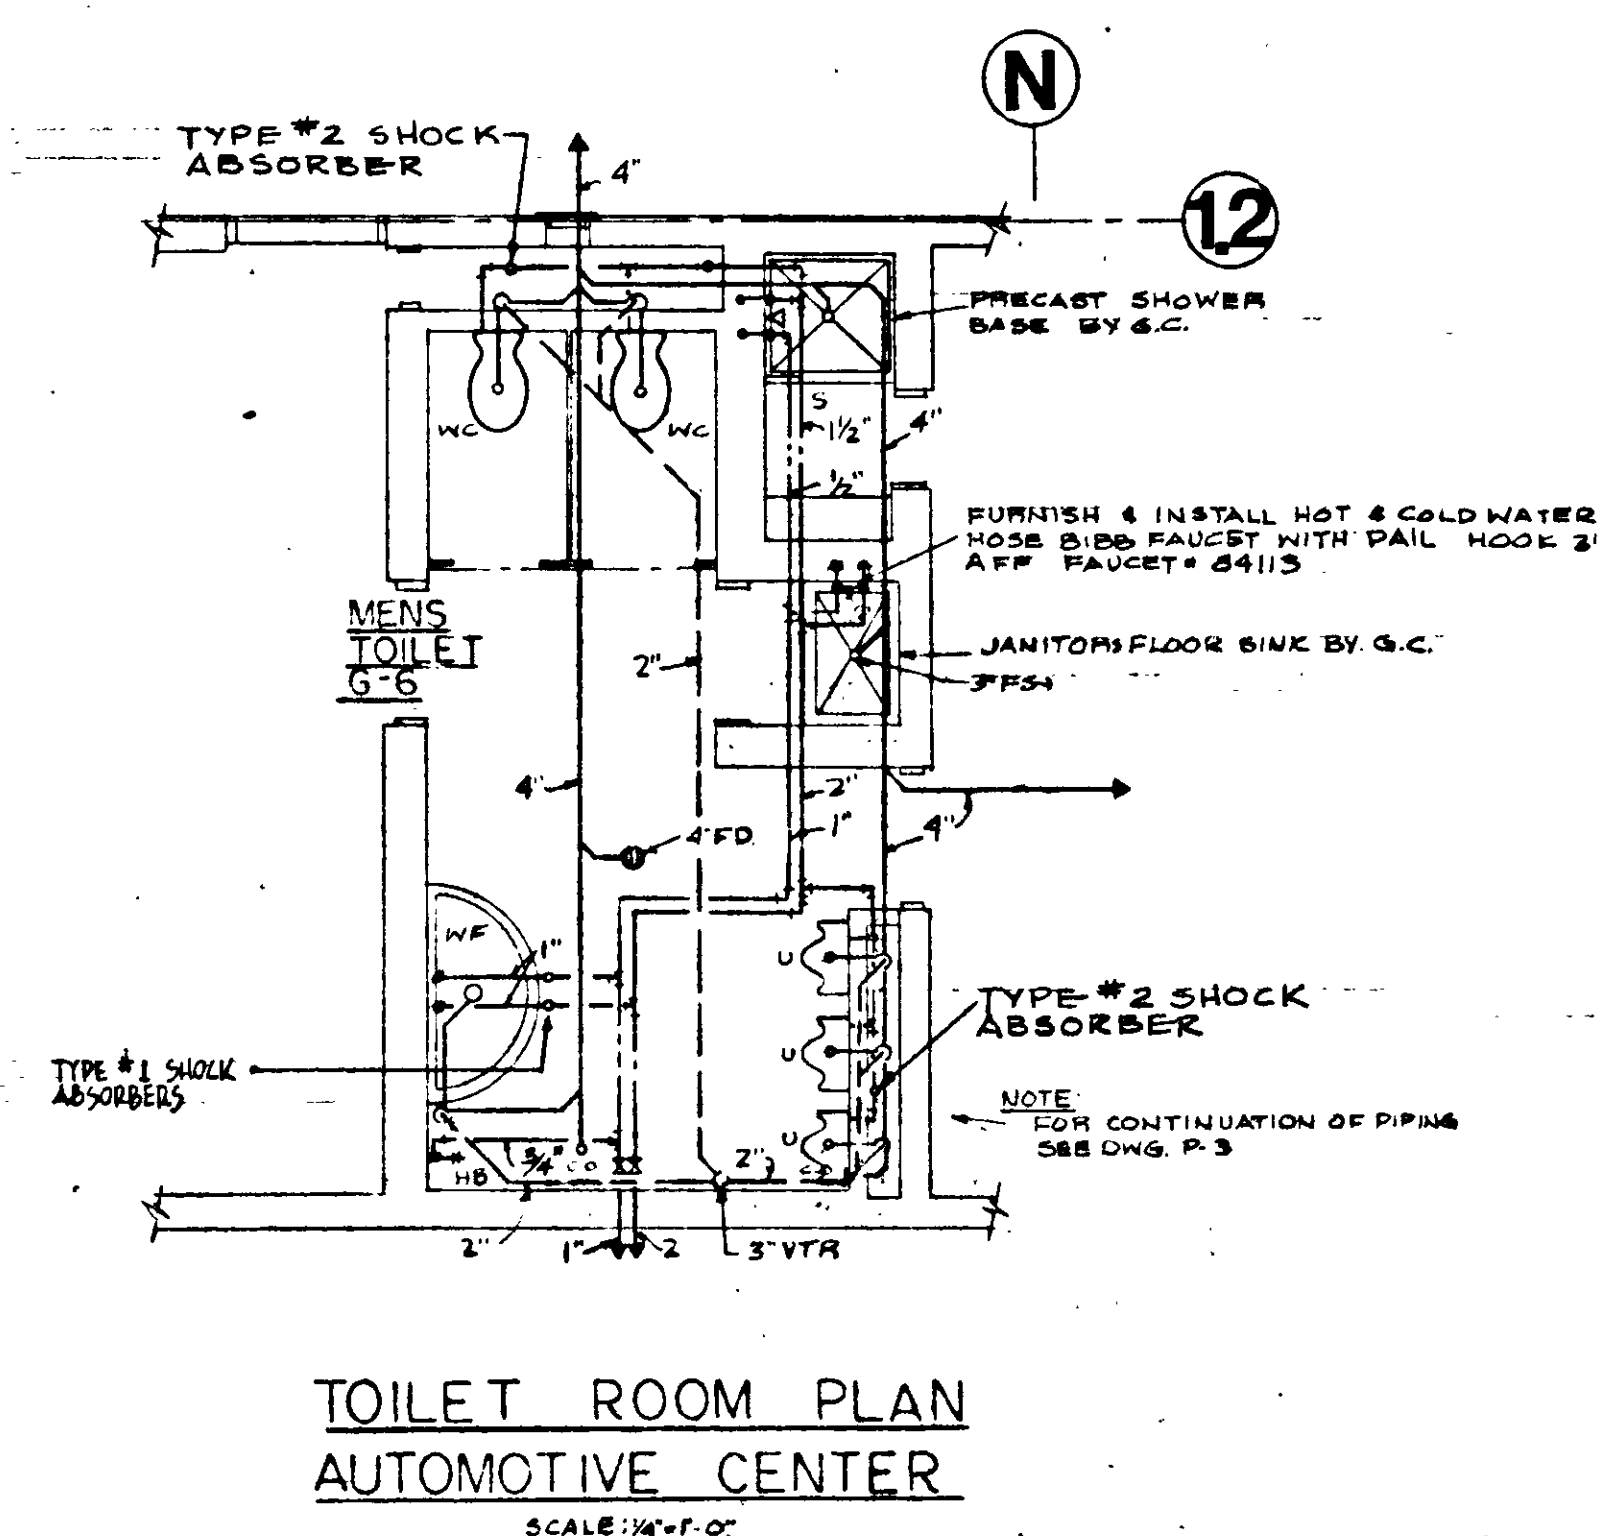


TOILET ROOM PLAN
AUTOMOTIVE CENTER
SCALE: 1/4"=1'-0"

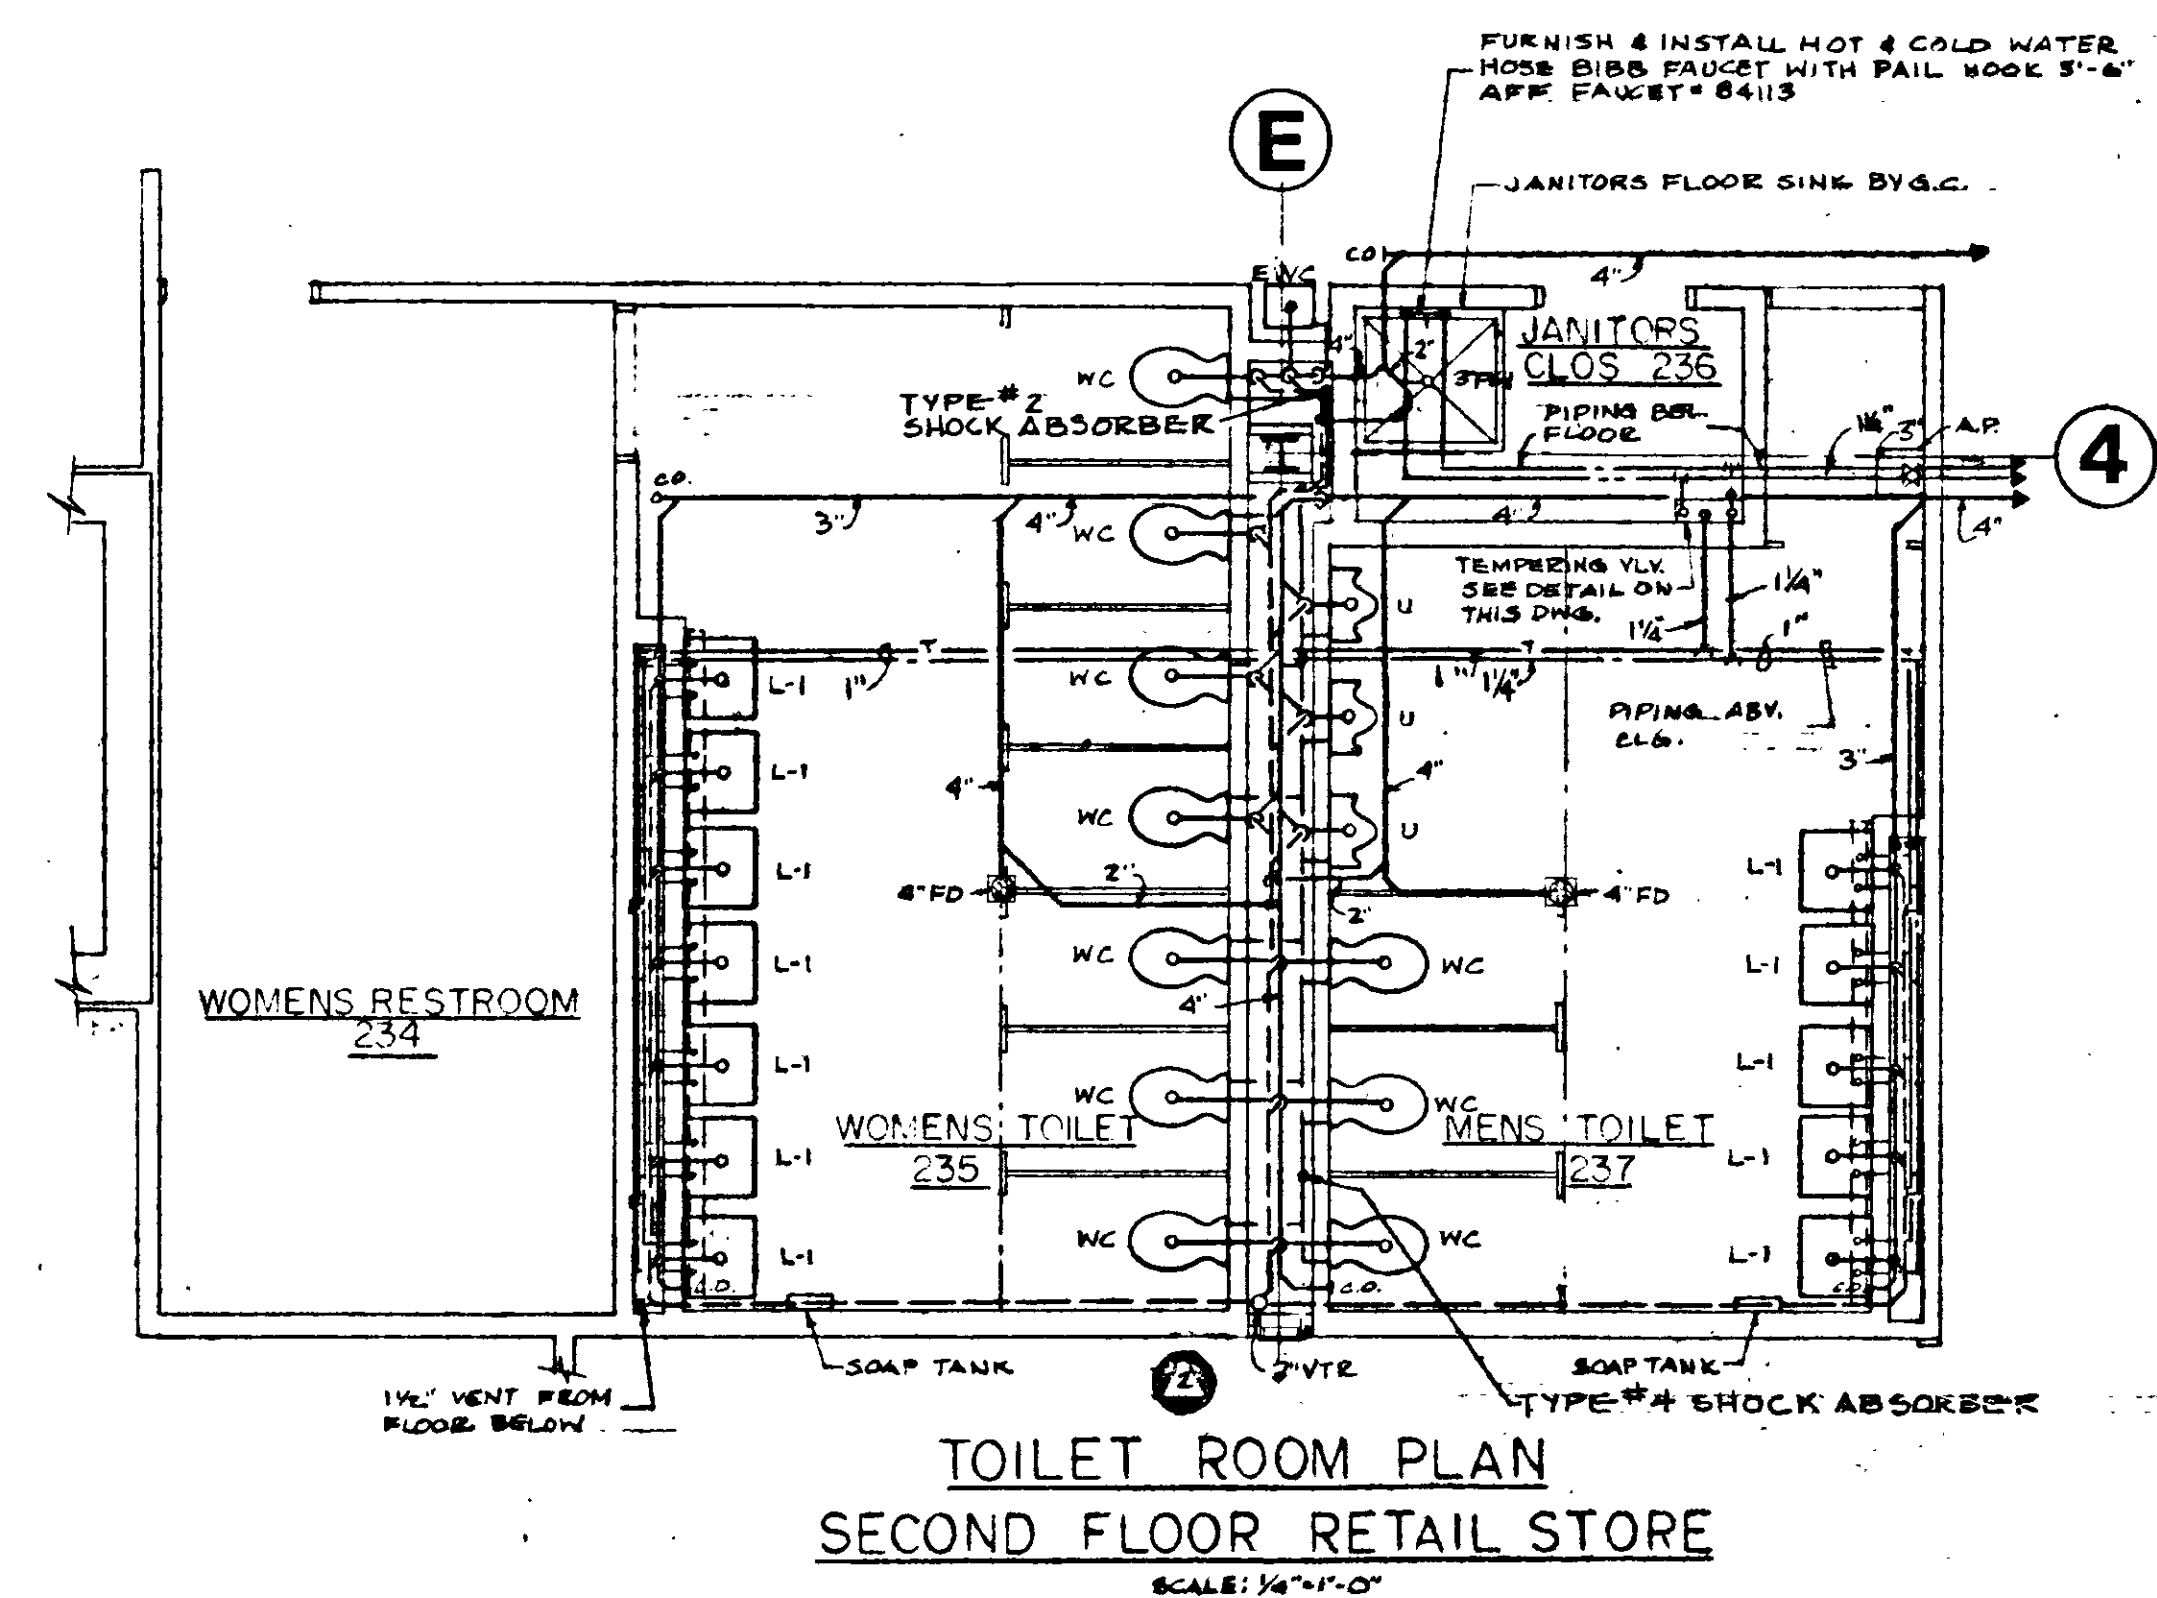

TOILET ROOM PLAN
SECOND FLOOR RETAIL STORE
SCALE: 1/4"=1'-0"

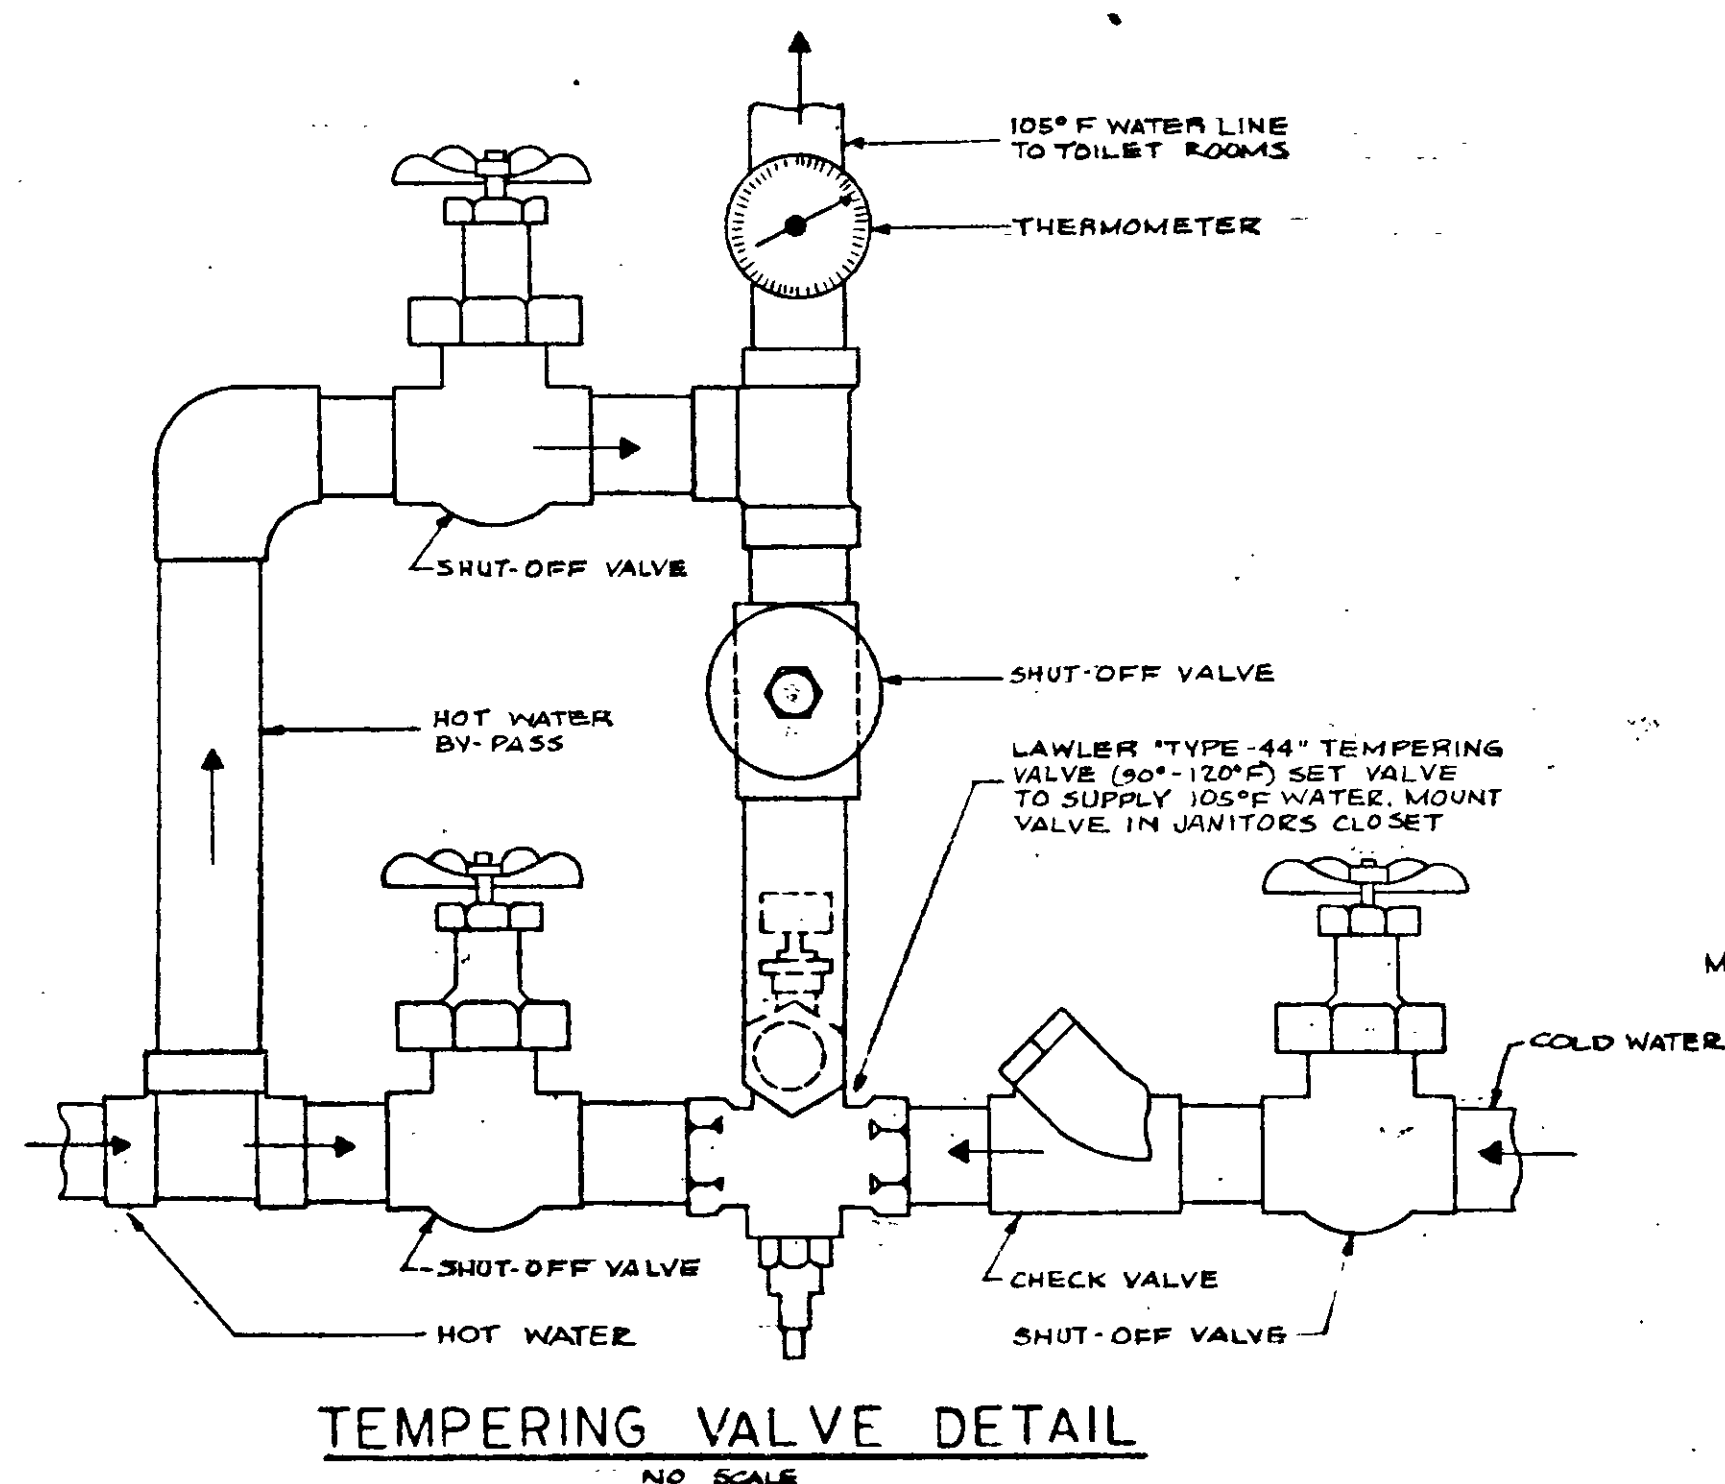


TEMPERING VALVE DETAIL
NO SCALE

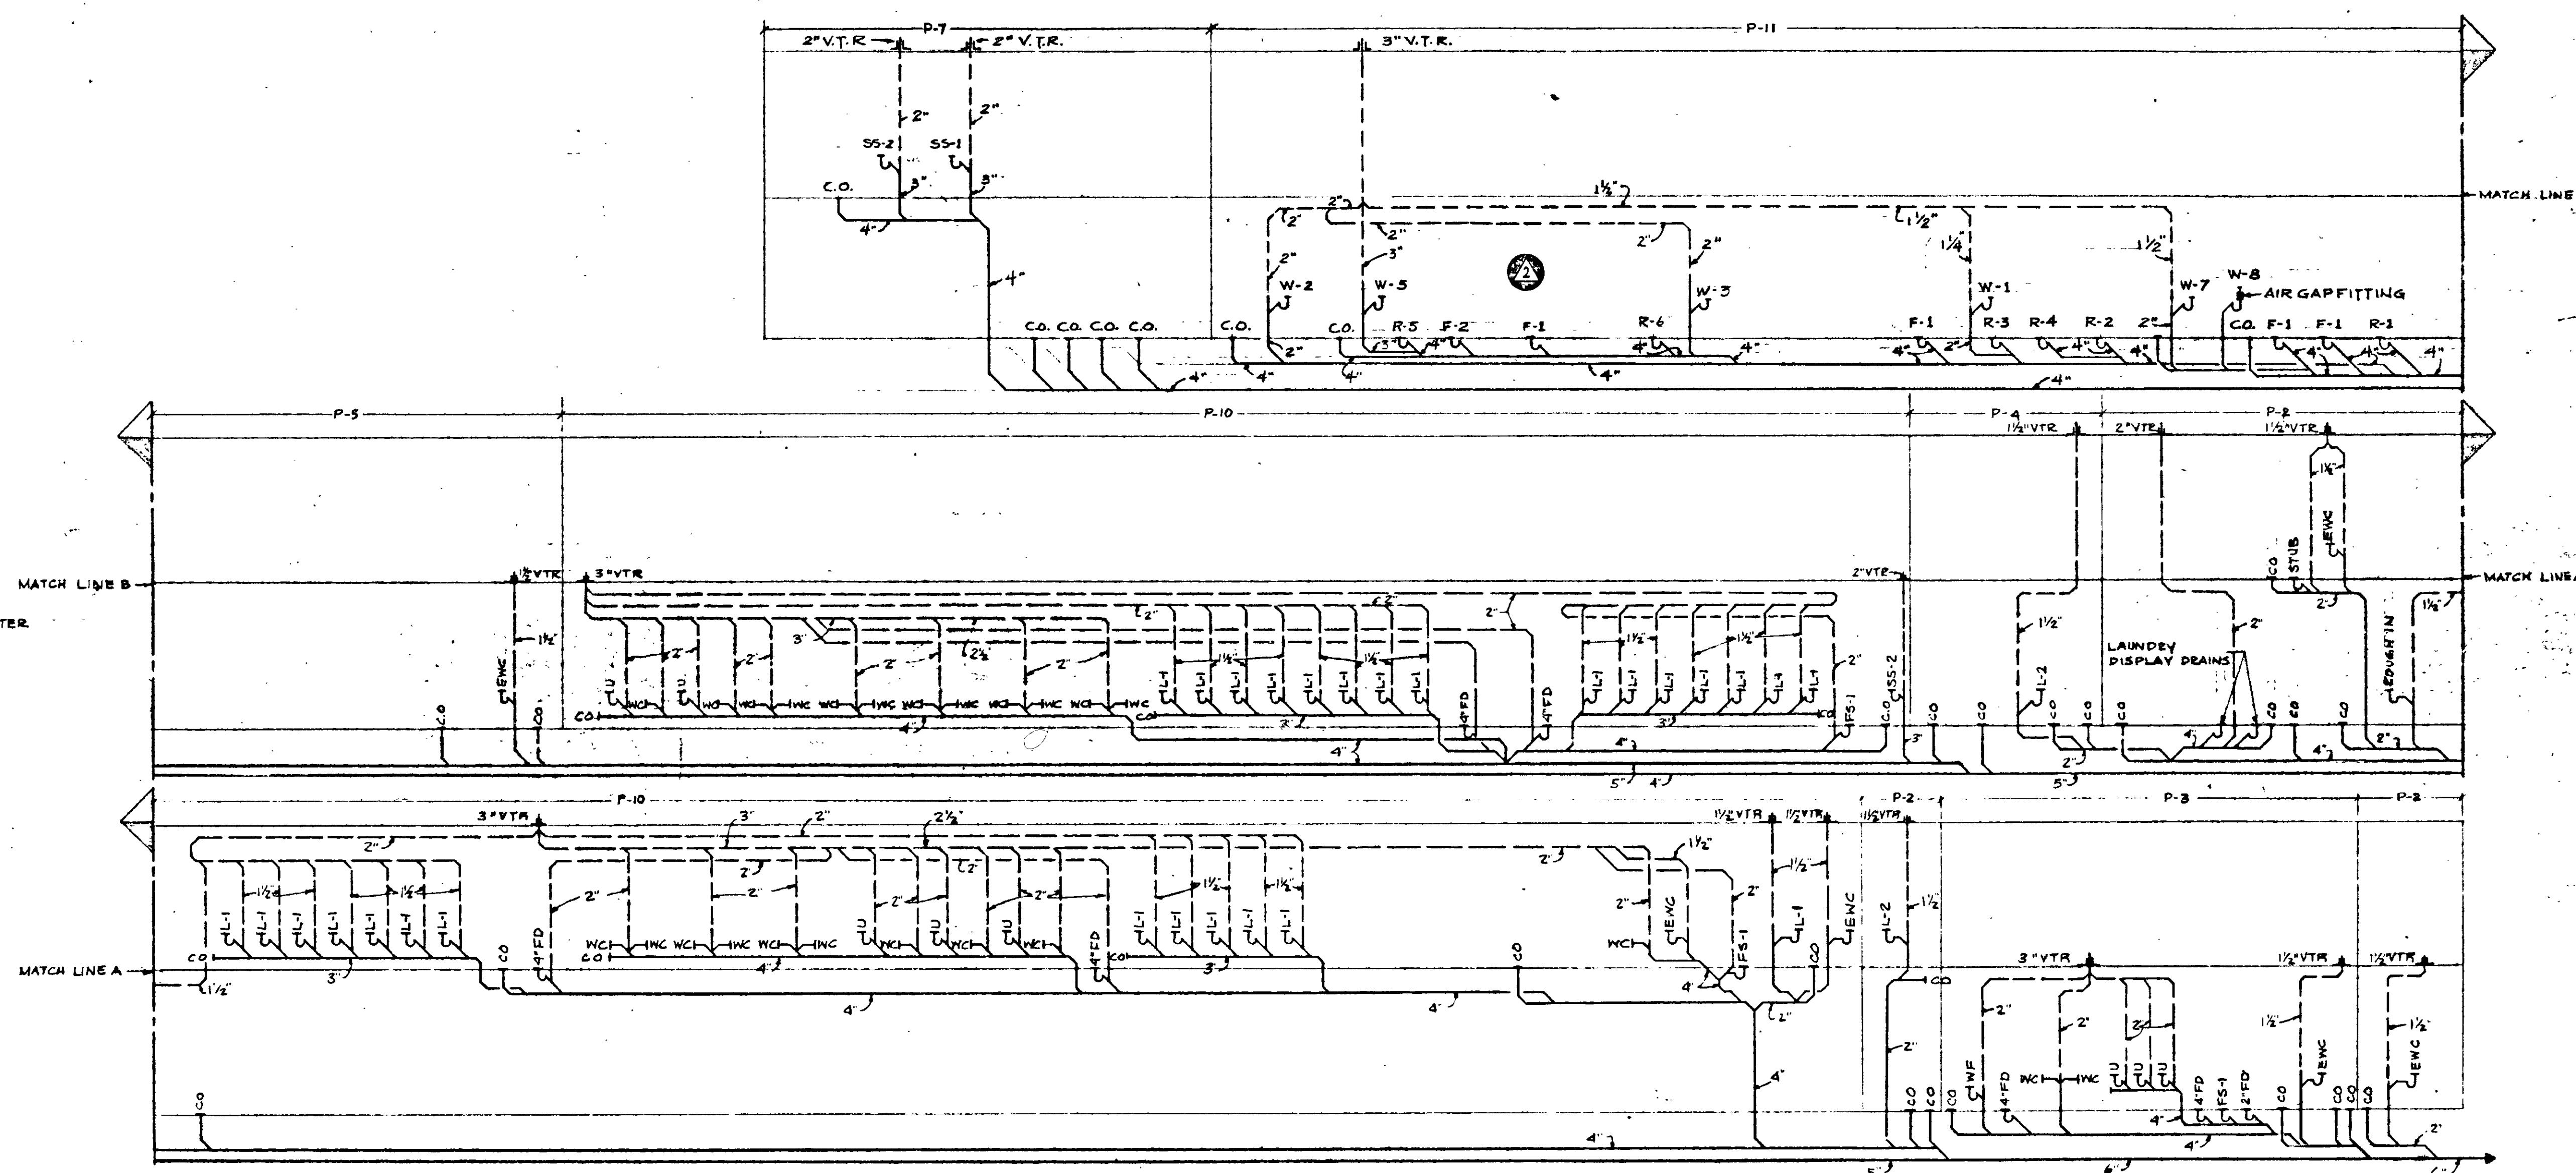


SANITARY RISER DIAGRAM
NO SCALE


SHOCK ABSORBER SCHEDULE			
TYPE	JOSAM	JAY R. SMITH	ZURN
1	1485-1	5005	*100
2	1485-2	5010	*200
3	1485-3	5020	*300
4	1485-4	5030	*400
5	1485-5	5040	*500
6	1485-6	5050	*600

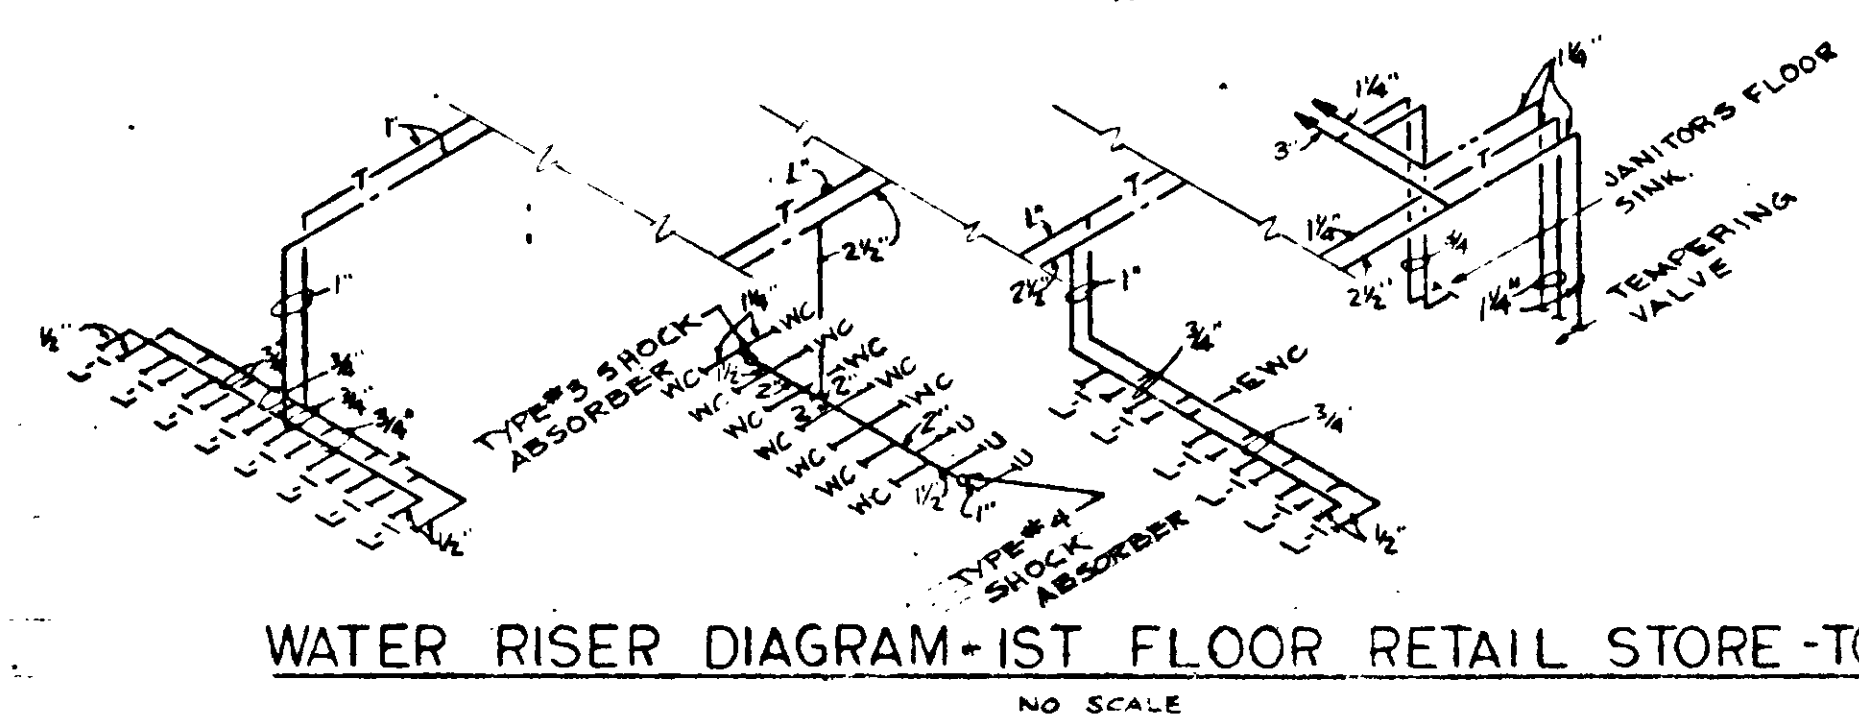

WATER RISER DIAGRAM-1ST FLOOR RETAIL STORE-TOILET RMS.
NO SCALE

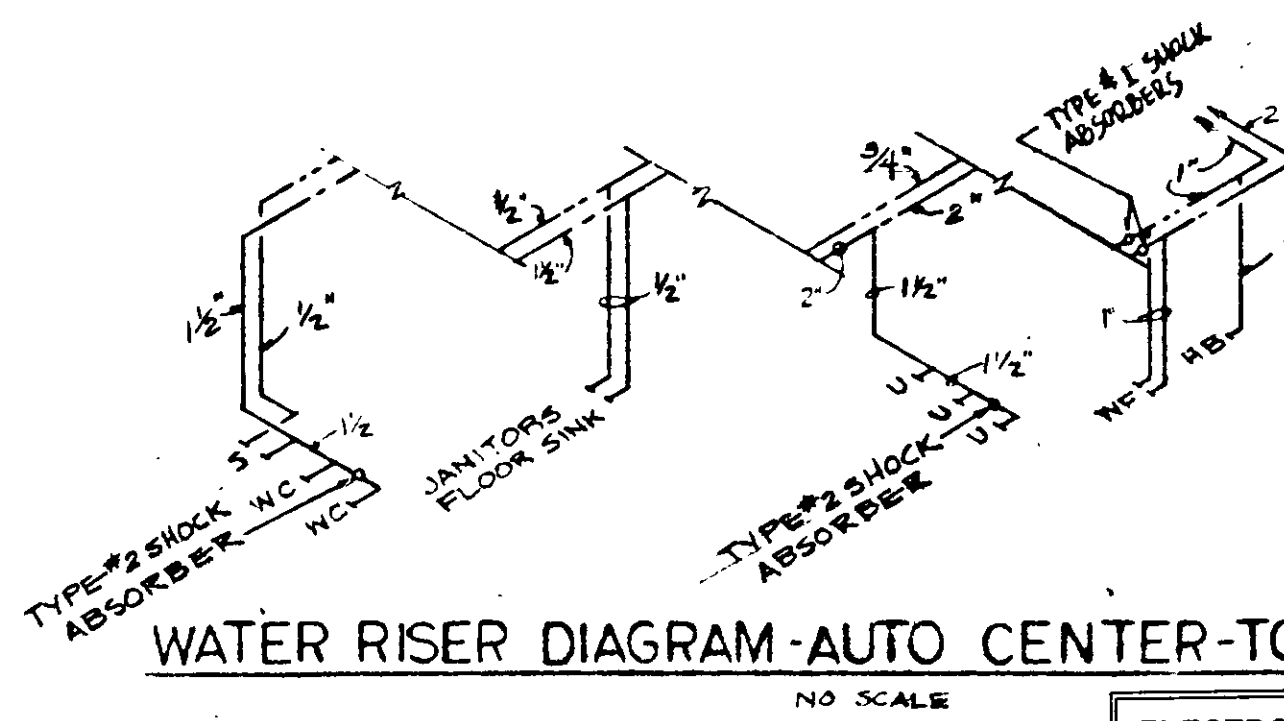

WATER RISER DIAGRAM-AUTO CENTER-TOILET RM.
NO SCALE

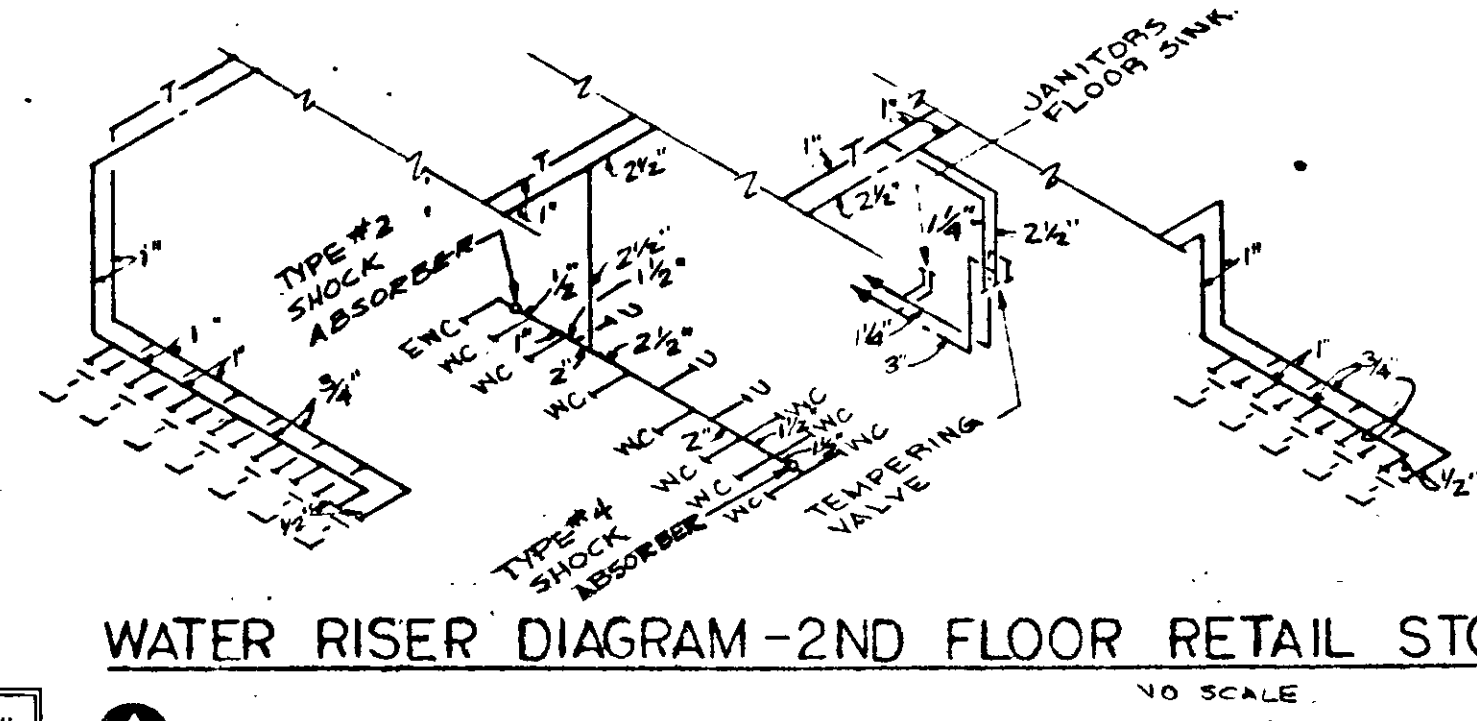

WATER RISER DIAGRAM-2ND FLOOR RETAIL STORE-TOILET RMS.
NO SCALE