


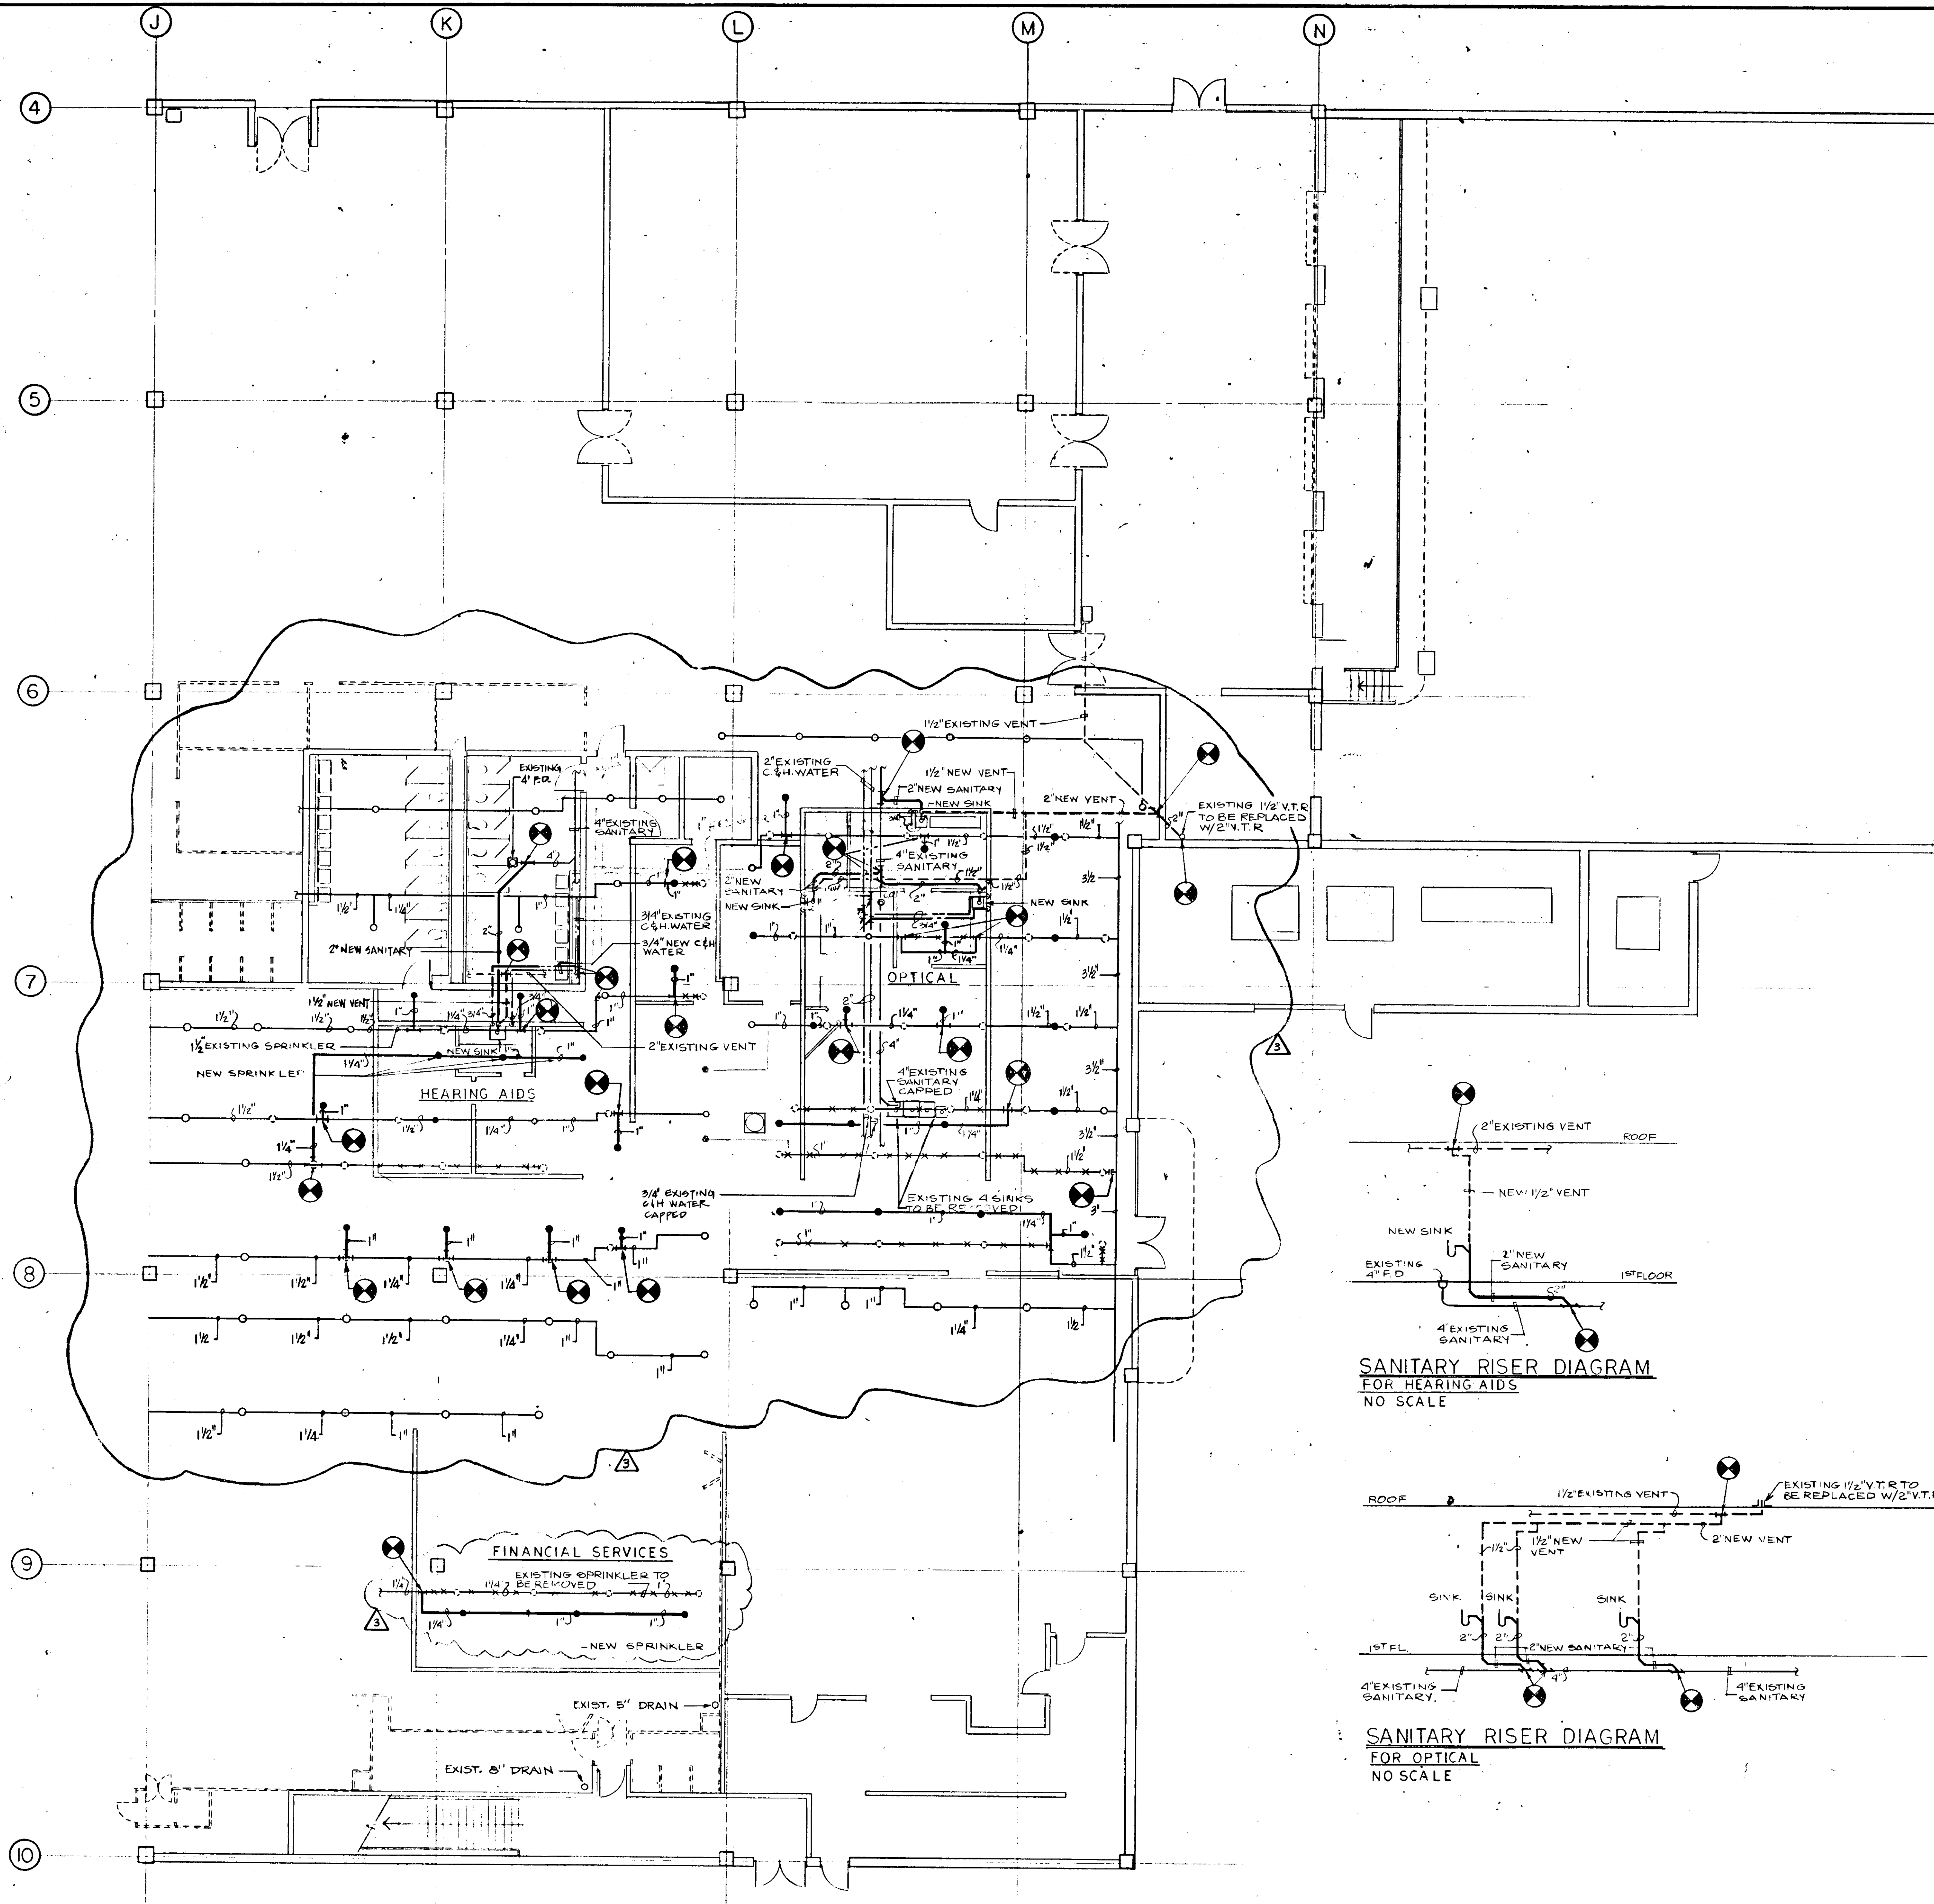

FIRST FLOOR
SCALE: 1/8"=1'-0"

GENERAL NOTES

1. VERIFY ALL EXISTING PIPING LOCATIONS PRIOR TO START OF NEW WORK.
2. SCHEDULE NEW WORK TO BE DONE WITH MINIMUM SYSTEM INTERRUPTIONS.
3. INSTALL SANITARY PIPING BELOW FLOOR SLAB WITH MINIMUM SLOPE OF 1/4" PER FOOT.
4. VENT THRU ROOF PENETRATION SHALL BE MADE WATERTIGHT BY USE OF APPROVED FLASHING MATERIALS. VENT PIPE SHALL EXTEND MINIMUM HEIGHT ABOVE ROOF IN ACCORDANCE WITH LOCAL CODES.


SPECIFICATIONS

1. WATER DISTRIBUTION PIPING SHALL BE TYPE "L" COPPER WATER TUBING WITH COPPER OR BRONZE SOLDER JOINT PRESSURE FITTINGS.
2. INTERIOR WASTE AND VENT PIPING SHALL BE OF HUBLESS CAST IRON SOIL PIPE AND FITTINGS. UNDERGROUND WASTE PIPING SHALL BE SERVICE CAST IRON SOIL PIPE AND FITTINGS.
3. VALVES SHALL BE EQUAL TO NIBCO S-113.
4. WATER PIPING INSULATION SHALL BE 1/2" THICK FIBERGLASS PIPE INSULATION WITH VAPOR BARRIER.
5. NEW SINKS FOR HEARING AID AND OPTICAL DEPT. SHALL BE FURNISHED BY SEARS. PLUMBING CONTRACTOR SHALL MAKE ROUGH-IN FINAL CONNECTION & PROVIDE TRIM FOR THE SINK.




PLUMBING SYMBOL LIST



- EXISTING COLD WATER PIPING
- EXISTING HOT WATER PIPING
- EXISTING SANITARY PIPING
- EXISTING VENT PIPING
- NEW COLD WATER PIPING
- NEW HOT WATER PIPING
- NEW SANITARY PIPING
- NEW VENT PIPING
- GATE VALVE
- NEW SPRINKLER
- EXISTING SPRINKLER TO BE REMOVED
- EXISTING SPRINKLER
- POINT OF CONNECTION TO EXISTING
- NEW SPRINKLER PIPE
- NEW CLEANOUT
- EXISTING CLEANOUT
- EXISTING SPRINKLER TO BE REMOVED
- CAPPED PIPE

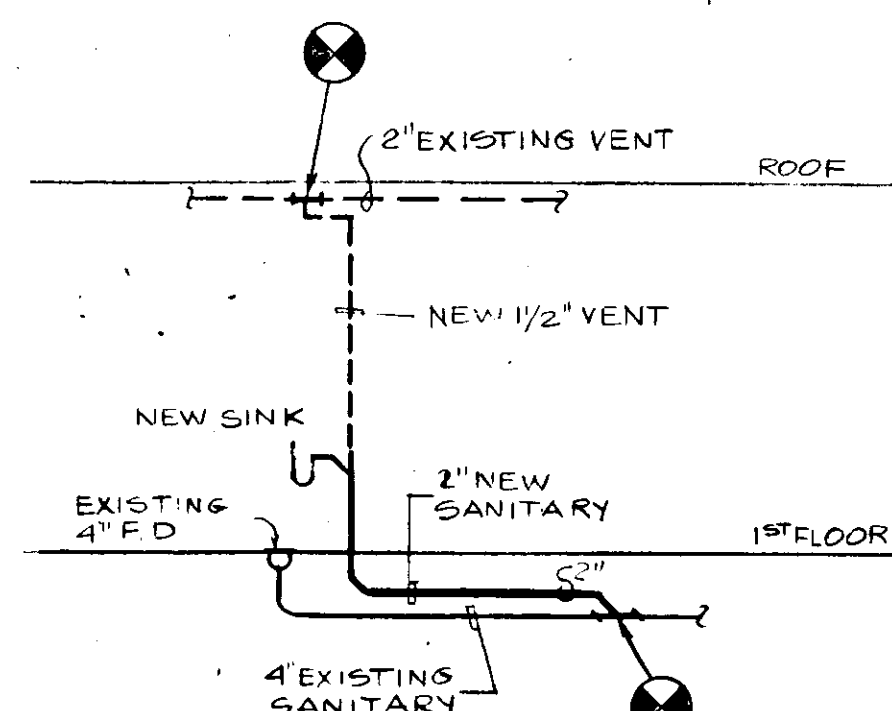

SANITARY RISER DIAGRAM
FOR HEARING AIDS
NO SCALE

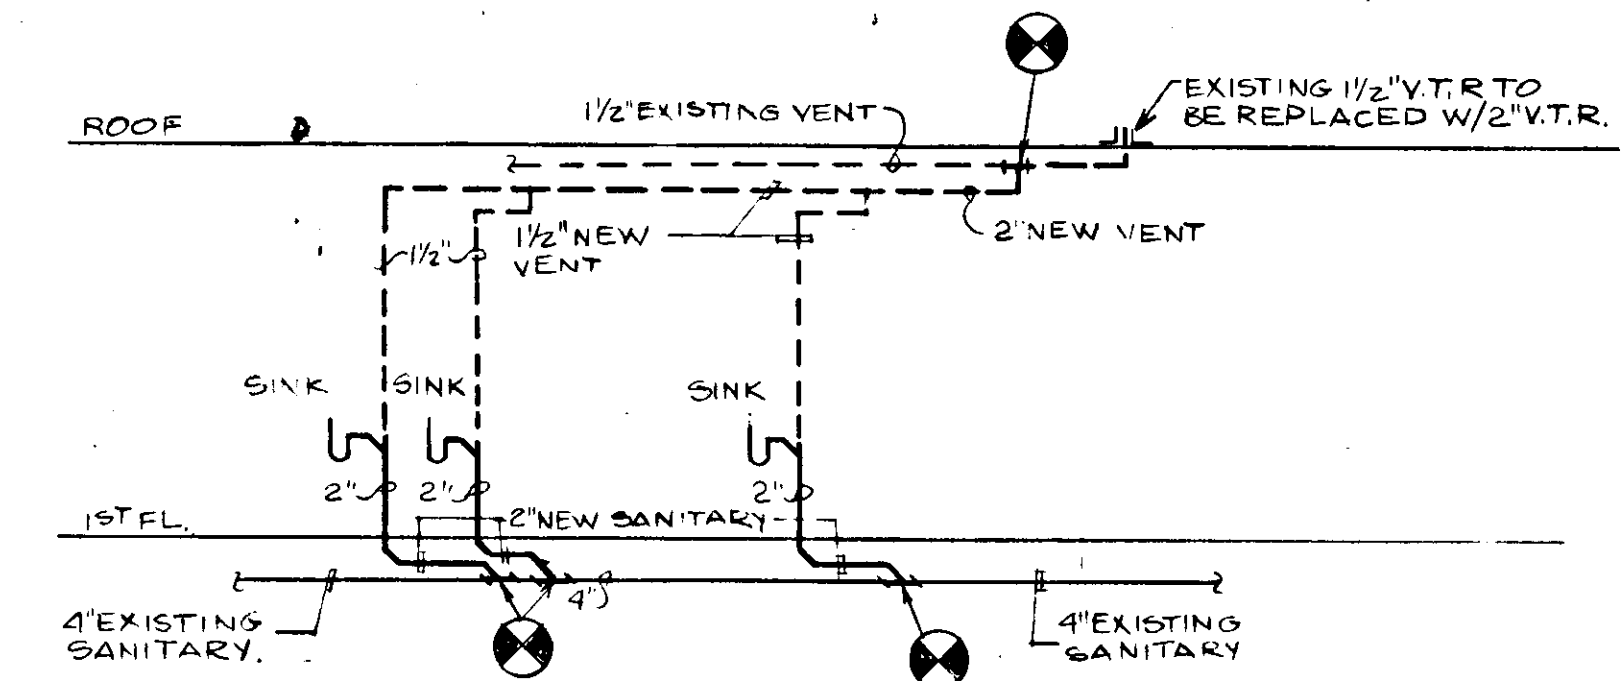

SANITARY RISER DIAGRAM
FOR OPTICAL
NO SCALE

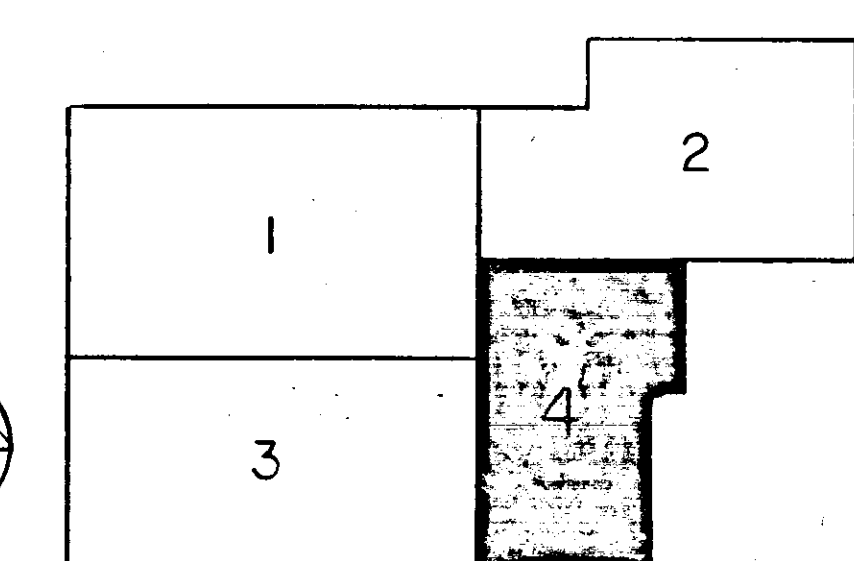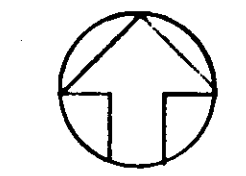

ISSUED		REVISIONS		SHEET NO.	
1	11-85	1	11-85	1	11-85
2	11-85	2	11-85	2	11-85
3	11-85	3	11-85	3	11-85
100	11-85	100	11-85	100	11-85

SEARS, ROEBUCK AND CO.
ALTERATIONS AND ADDITIONS TO
RETAIL STORE
SECURITY SQUARE, BALTIMORE, MD.

FEDCO SYSTEMS INC.
10903 FT. WASHINGTON ROAD
FORT WASHINGTON MARYLAND 20744
292-3900 645-3337
ARCHITECTS - ENGINEERS - PLANNERS - SURVEYORS

RSI
SHEET NO.
P-2
PROJECT NO. 531-2

ELECTRONIC CONTROL
R1634.1.LB.P2