




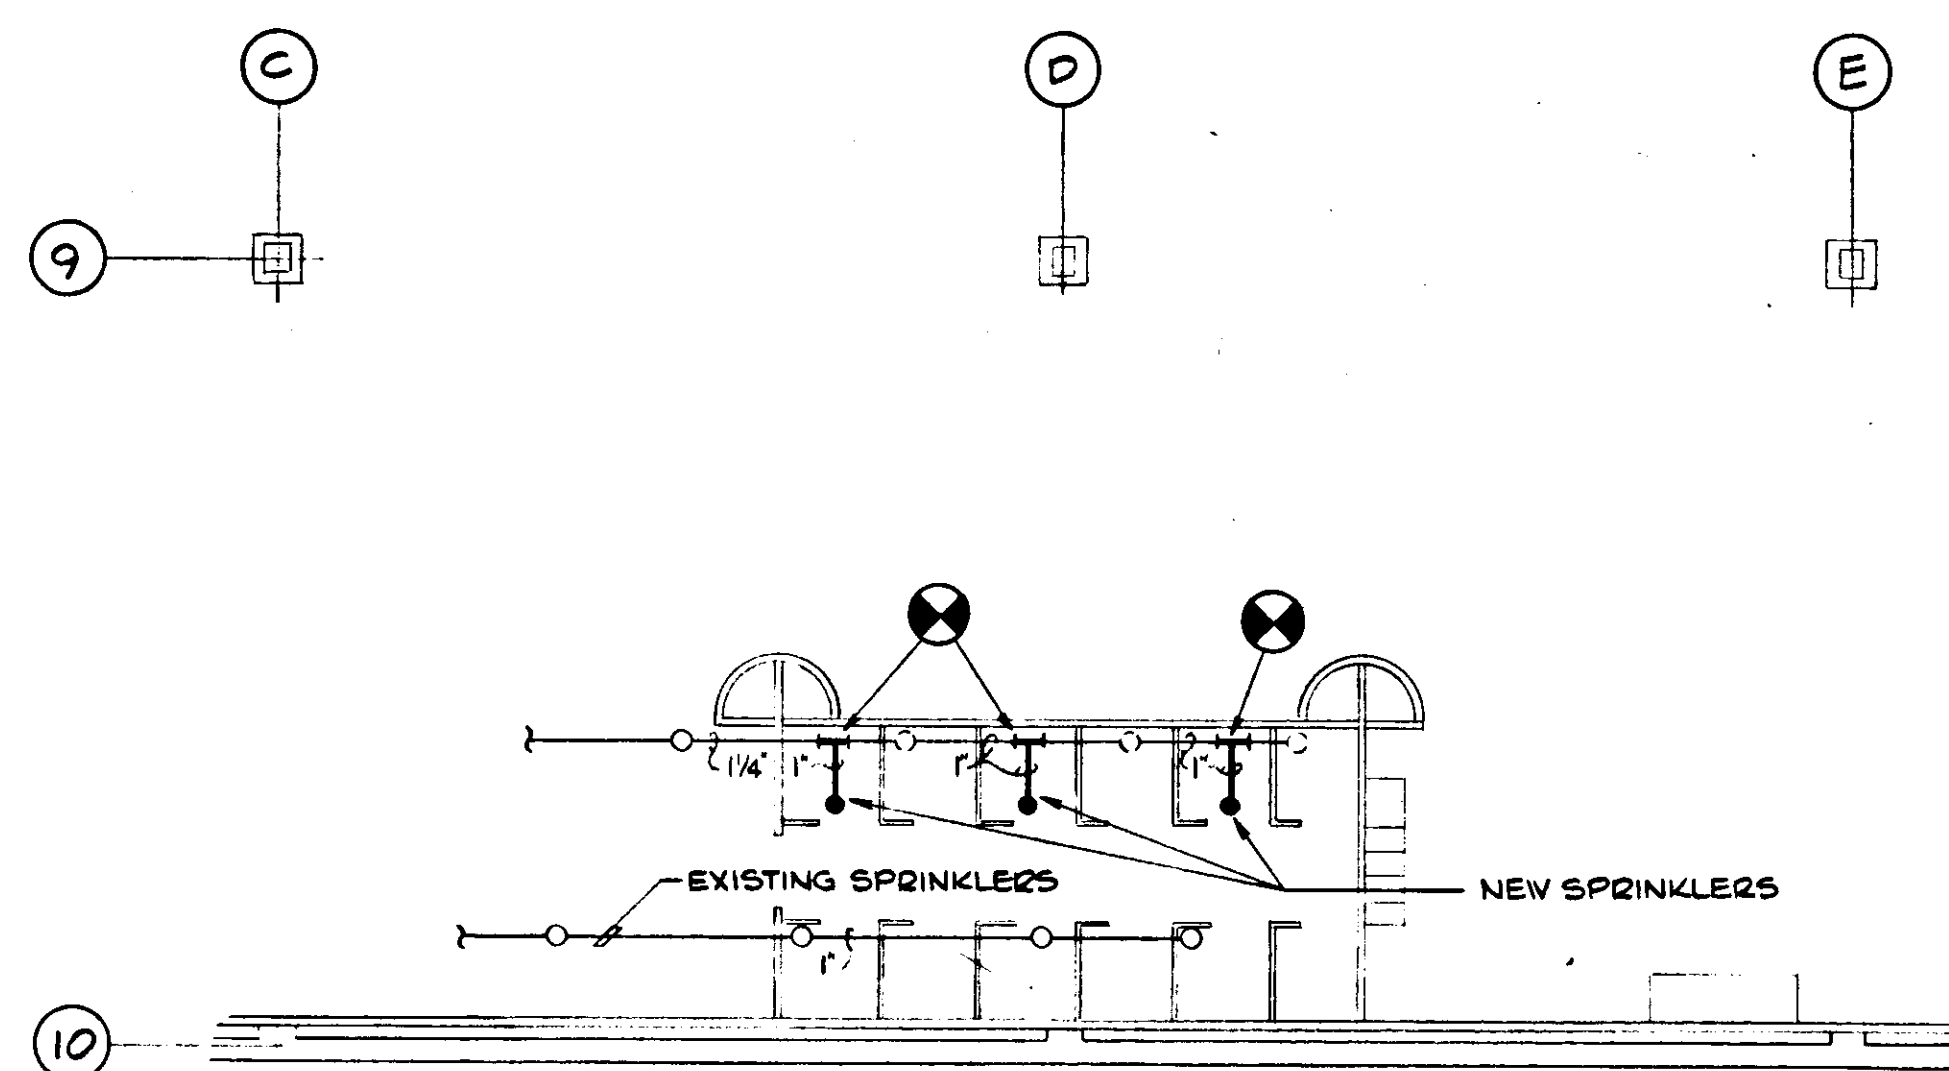


PARTIAL PLAN# 1 - FIRST FLOOR  
SCALE: 1/8" = 1'-0"

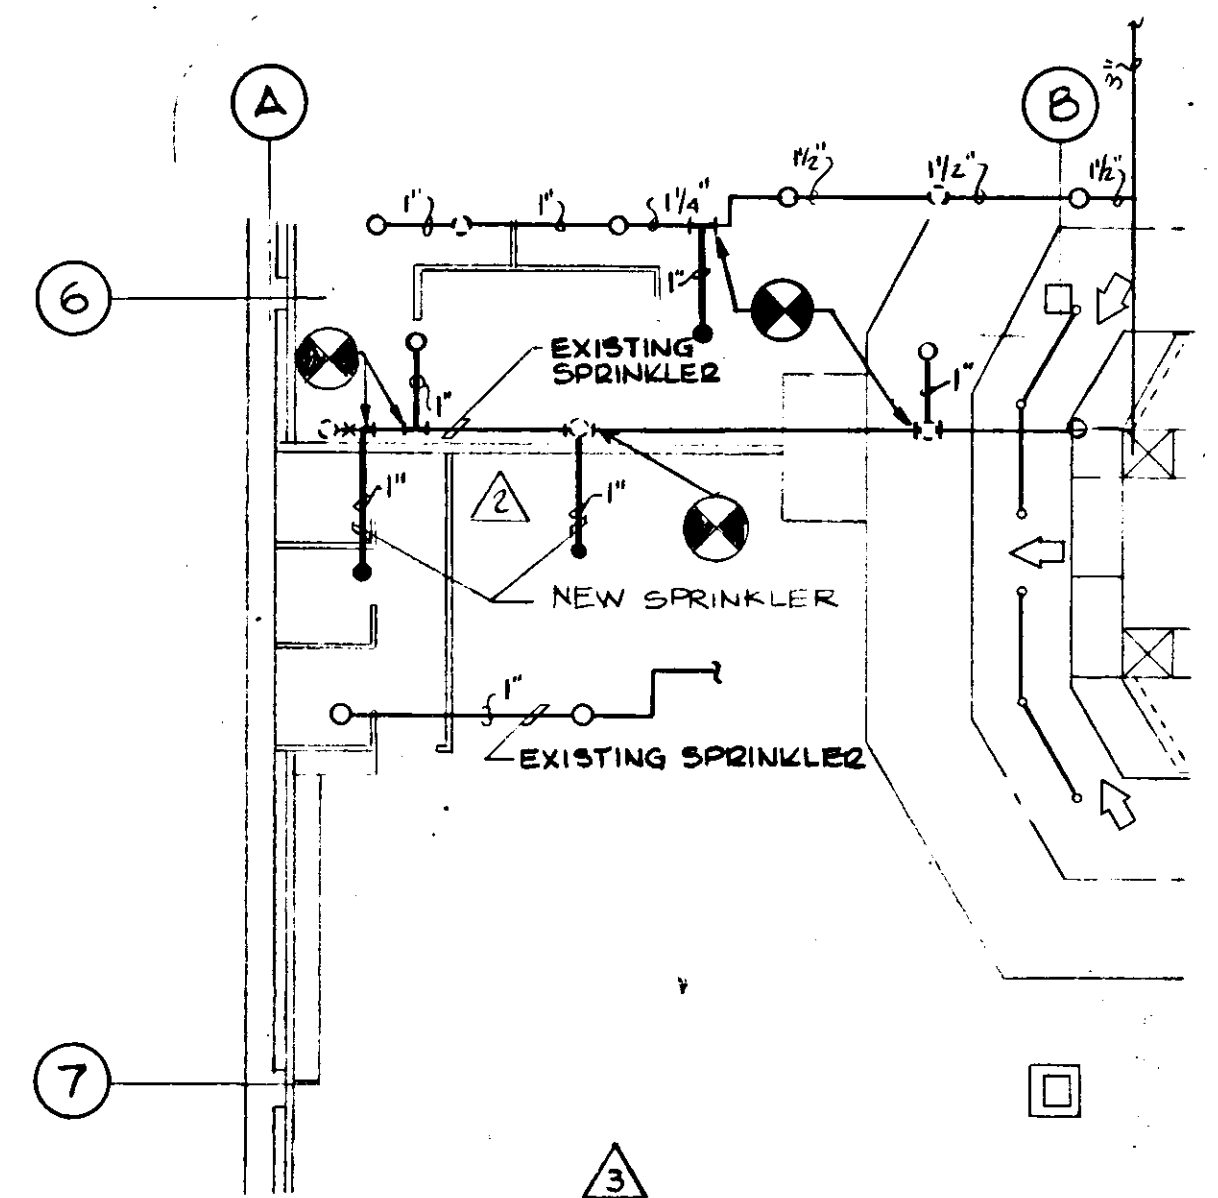


PARTIAL PLAN# 2 - FIRST FLOOR  
SCALE: 1/8" = 1'-0"

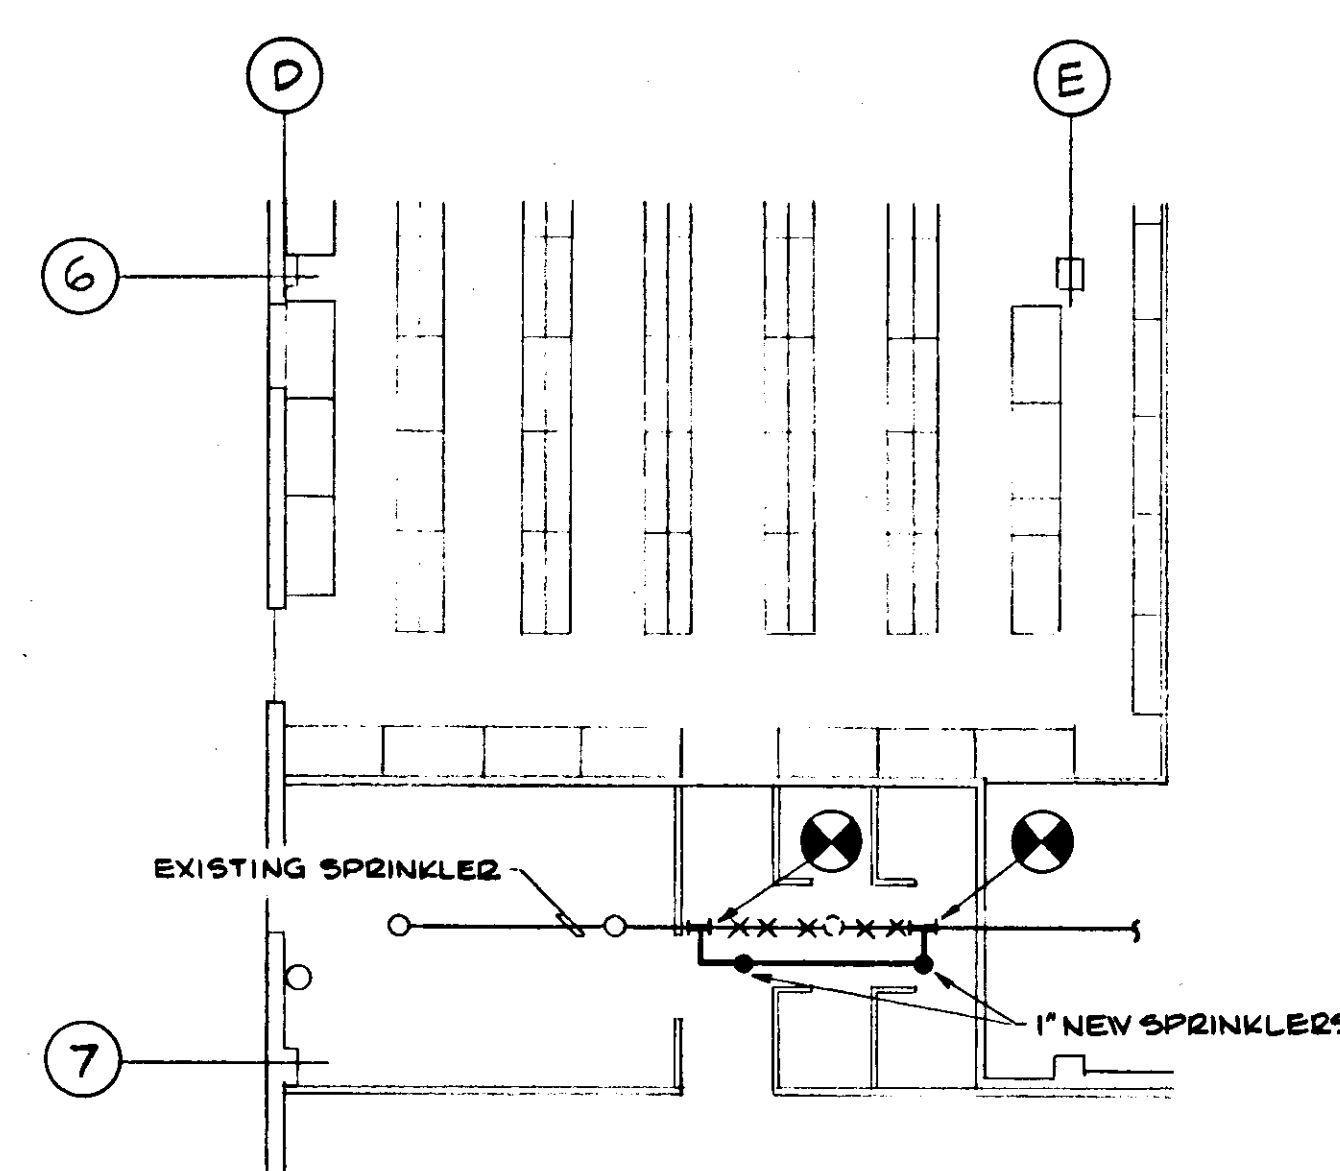


PARTIAL PLAN# 3 - FIRST FLOOR  
SCALE: 1/8" = 1'-0"

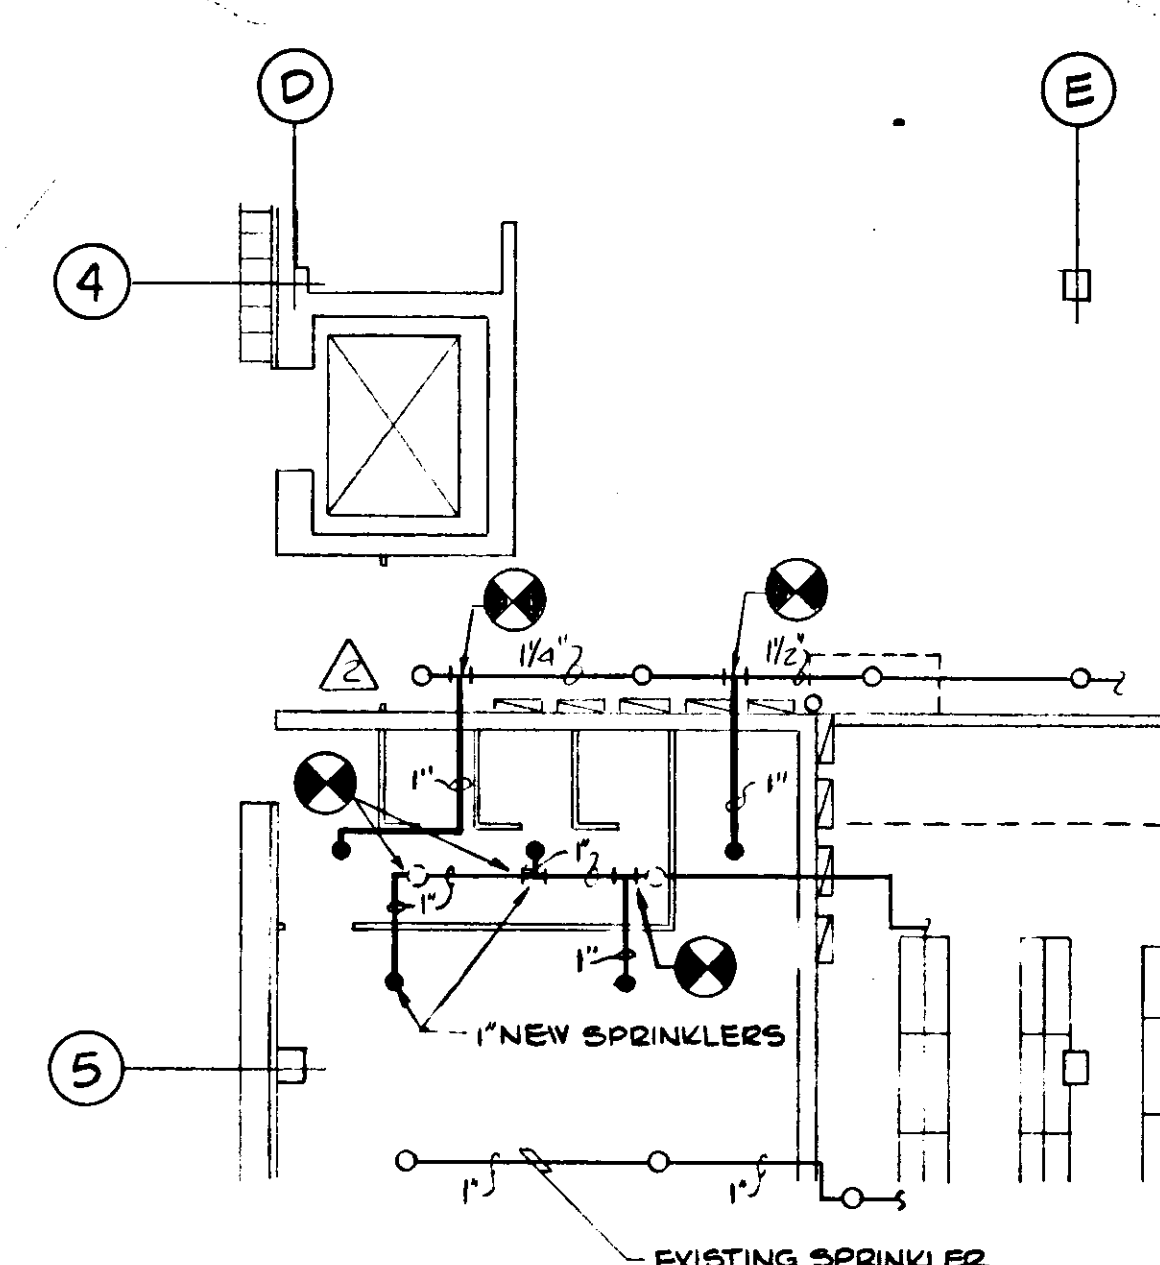


PARTIAL PLAN# 4 - FIRST FLOOR  
SCALE: 1/8" = 1'-0"

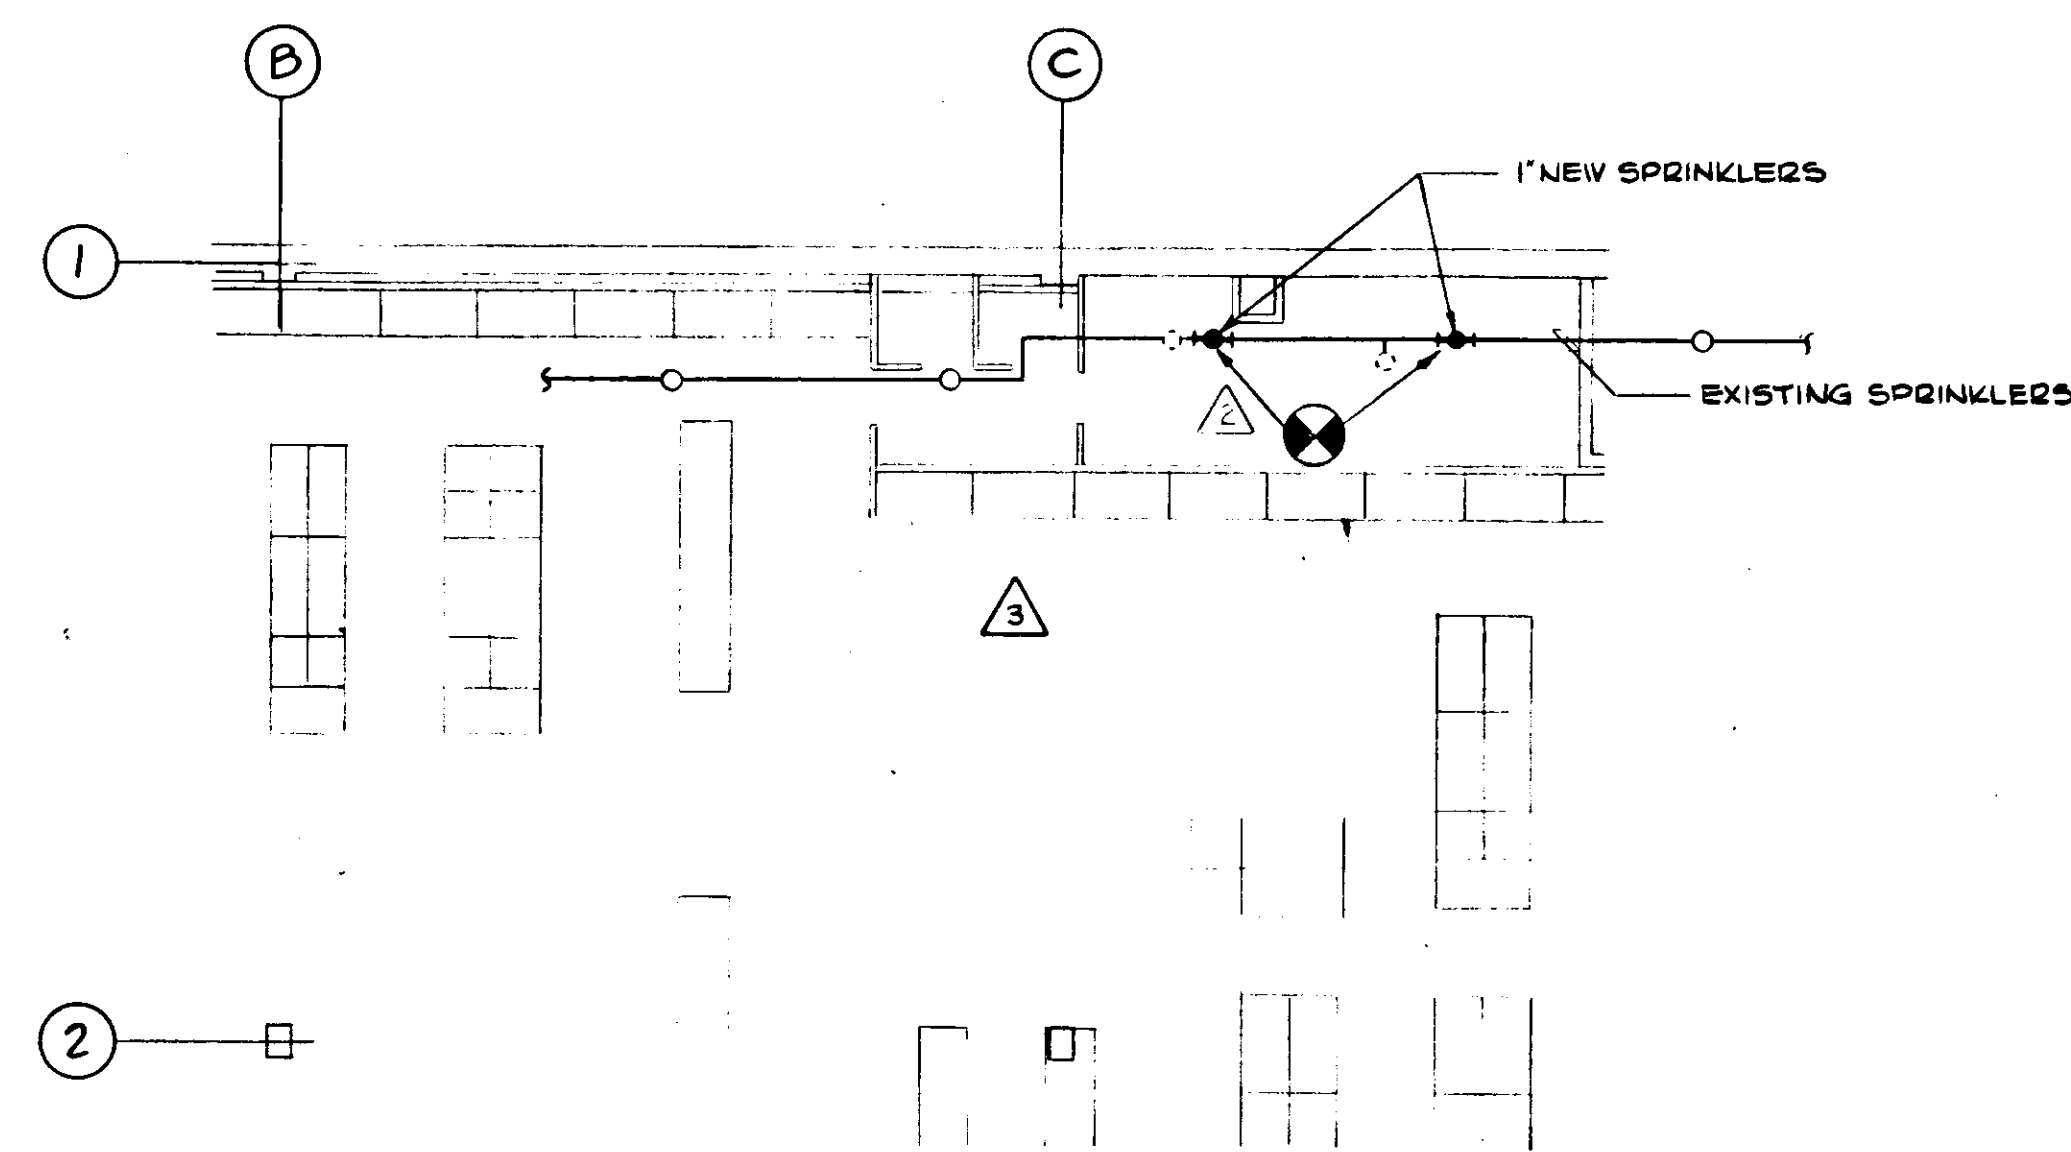


PARTIAL PLAN# 5 - FIRST FLOOR  
SCALE: 1/8" = 1'-0"

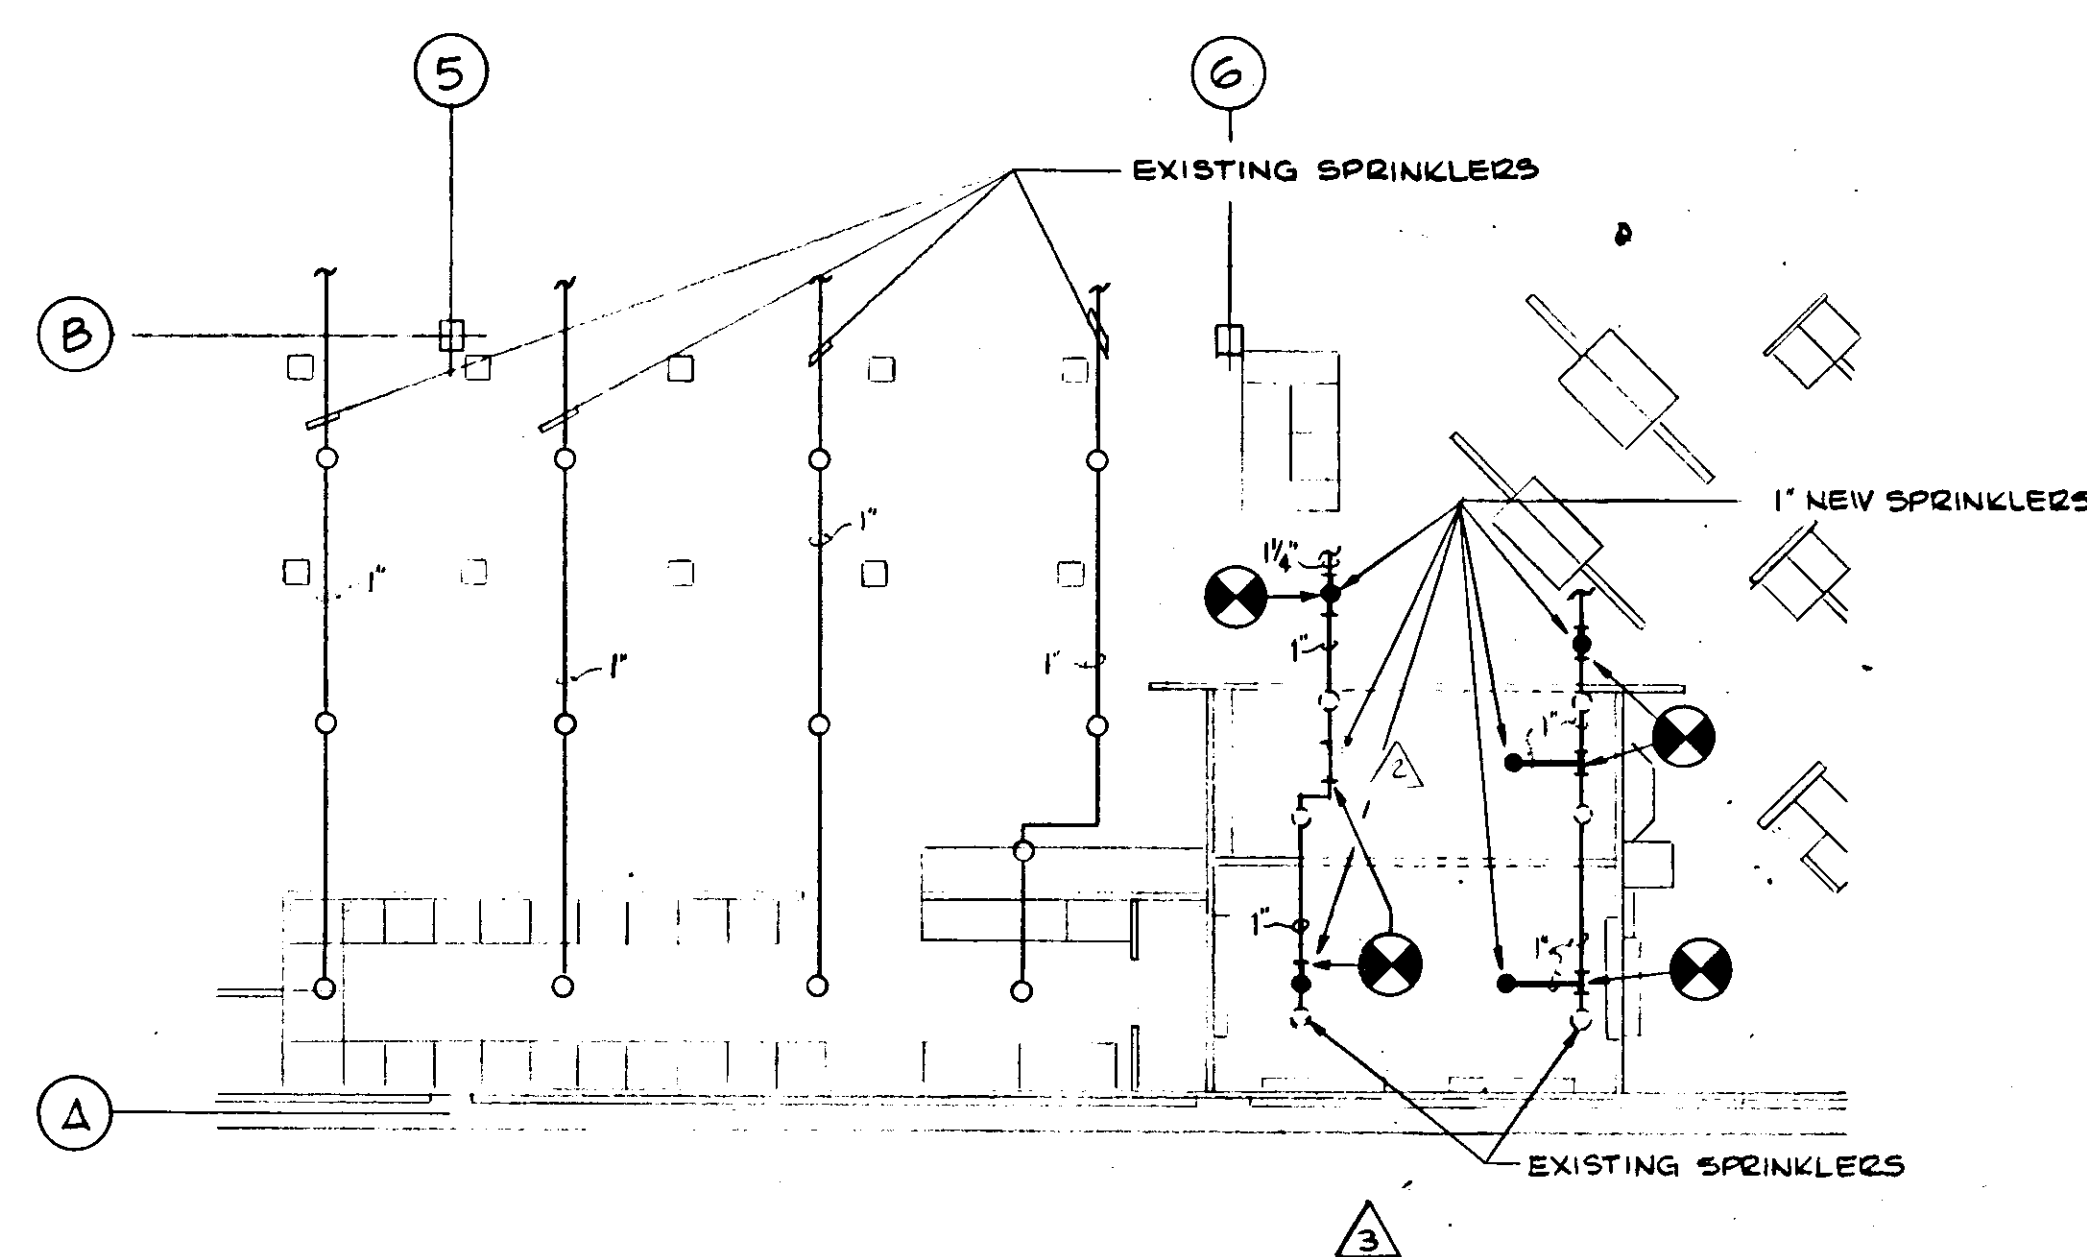


PARTIAL PLAN# 6 - SECOND FLOOR  
SCALE: 1/8" = 1'-0"

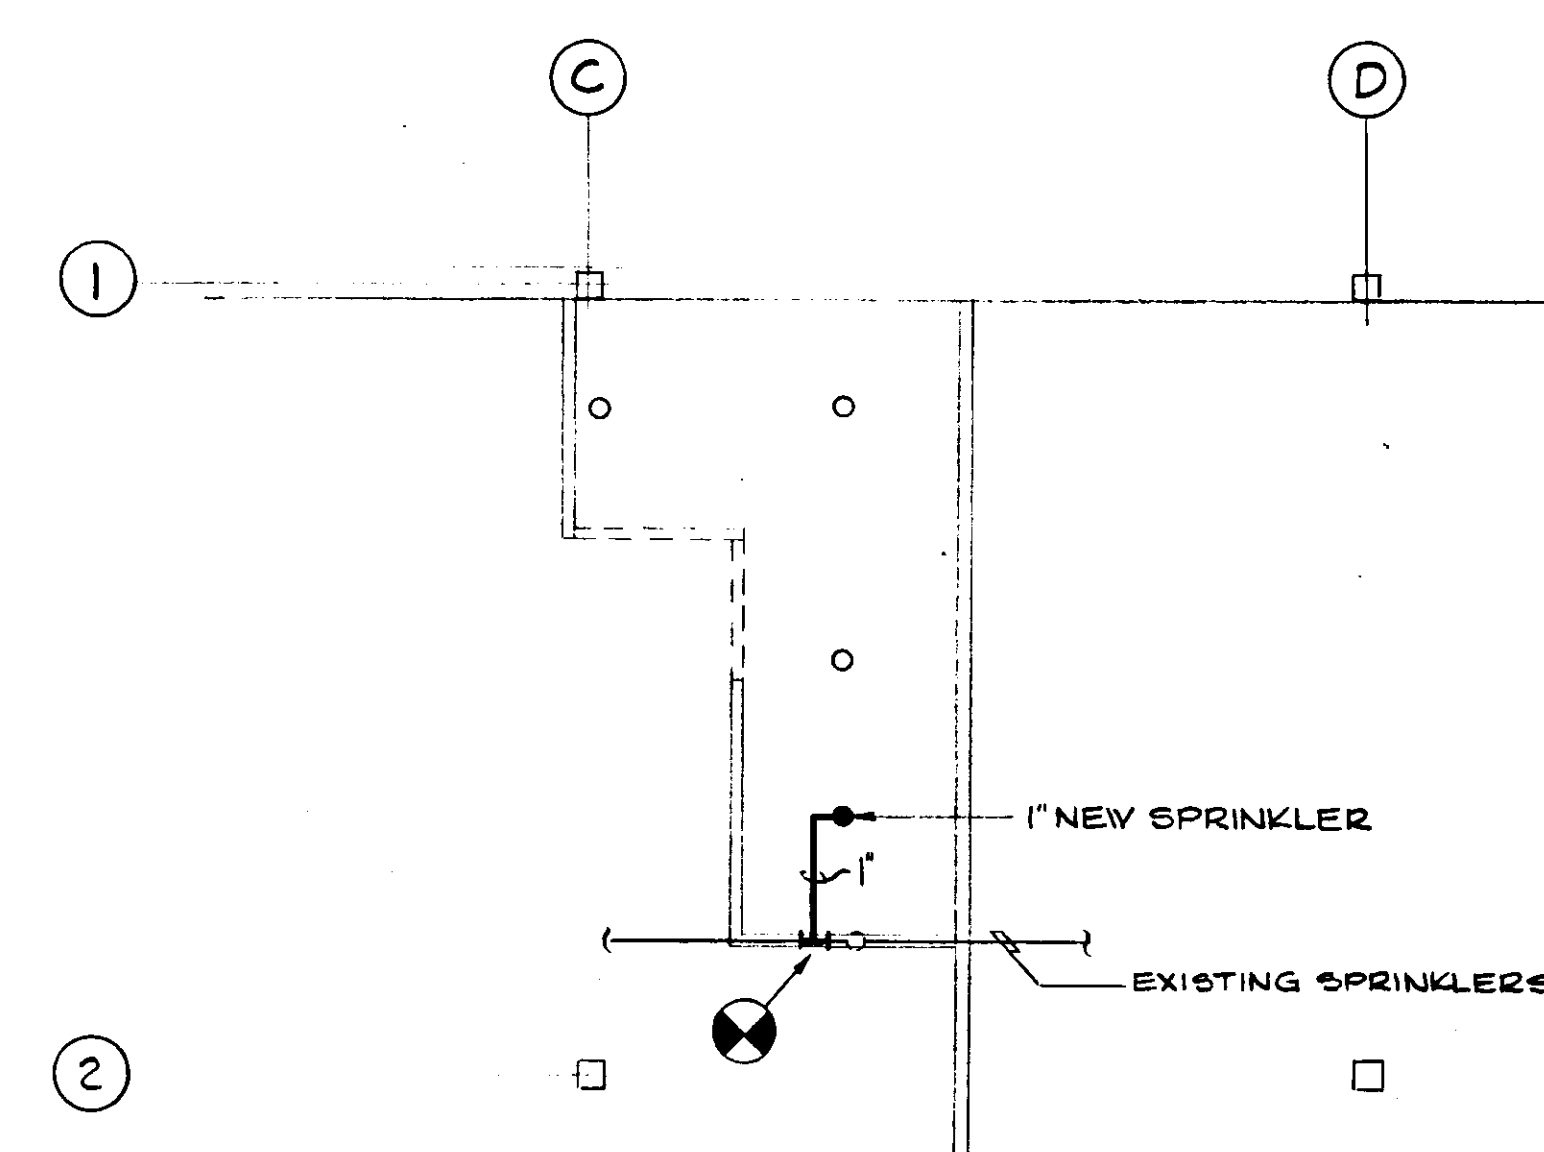

PARTIAL PLAN# 7 - SECOND FLOOR  
SCALE: 1/8" = 1'-0"

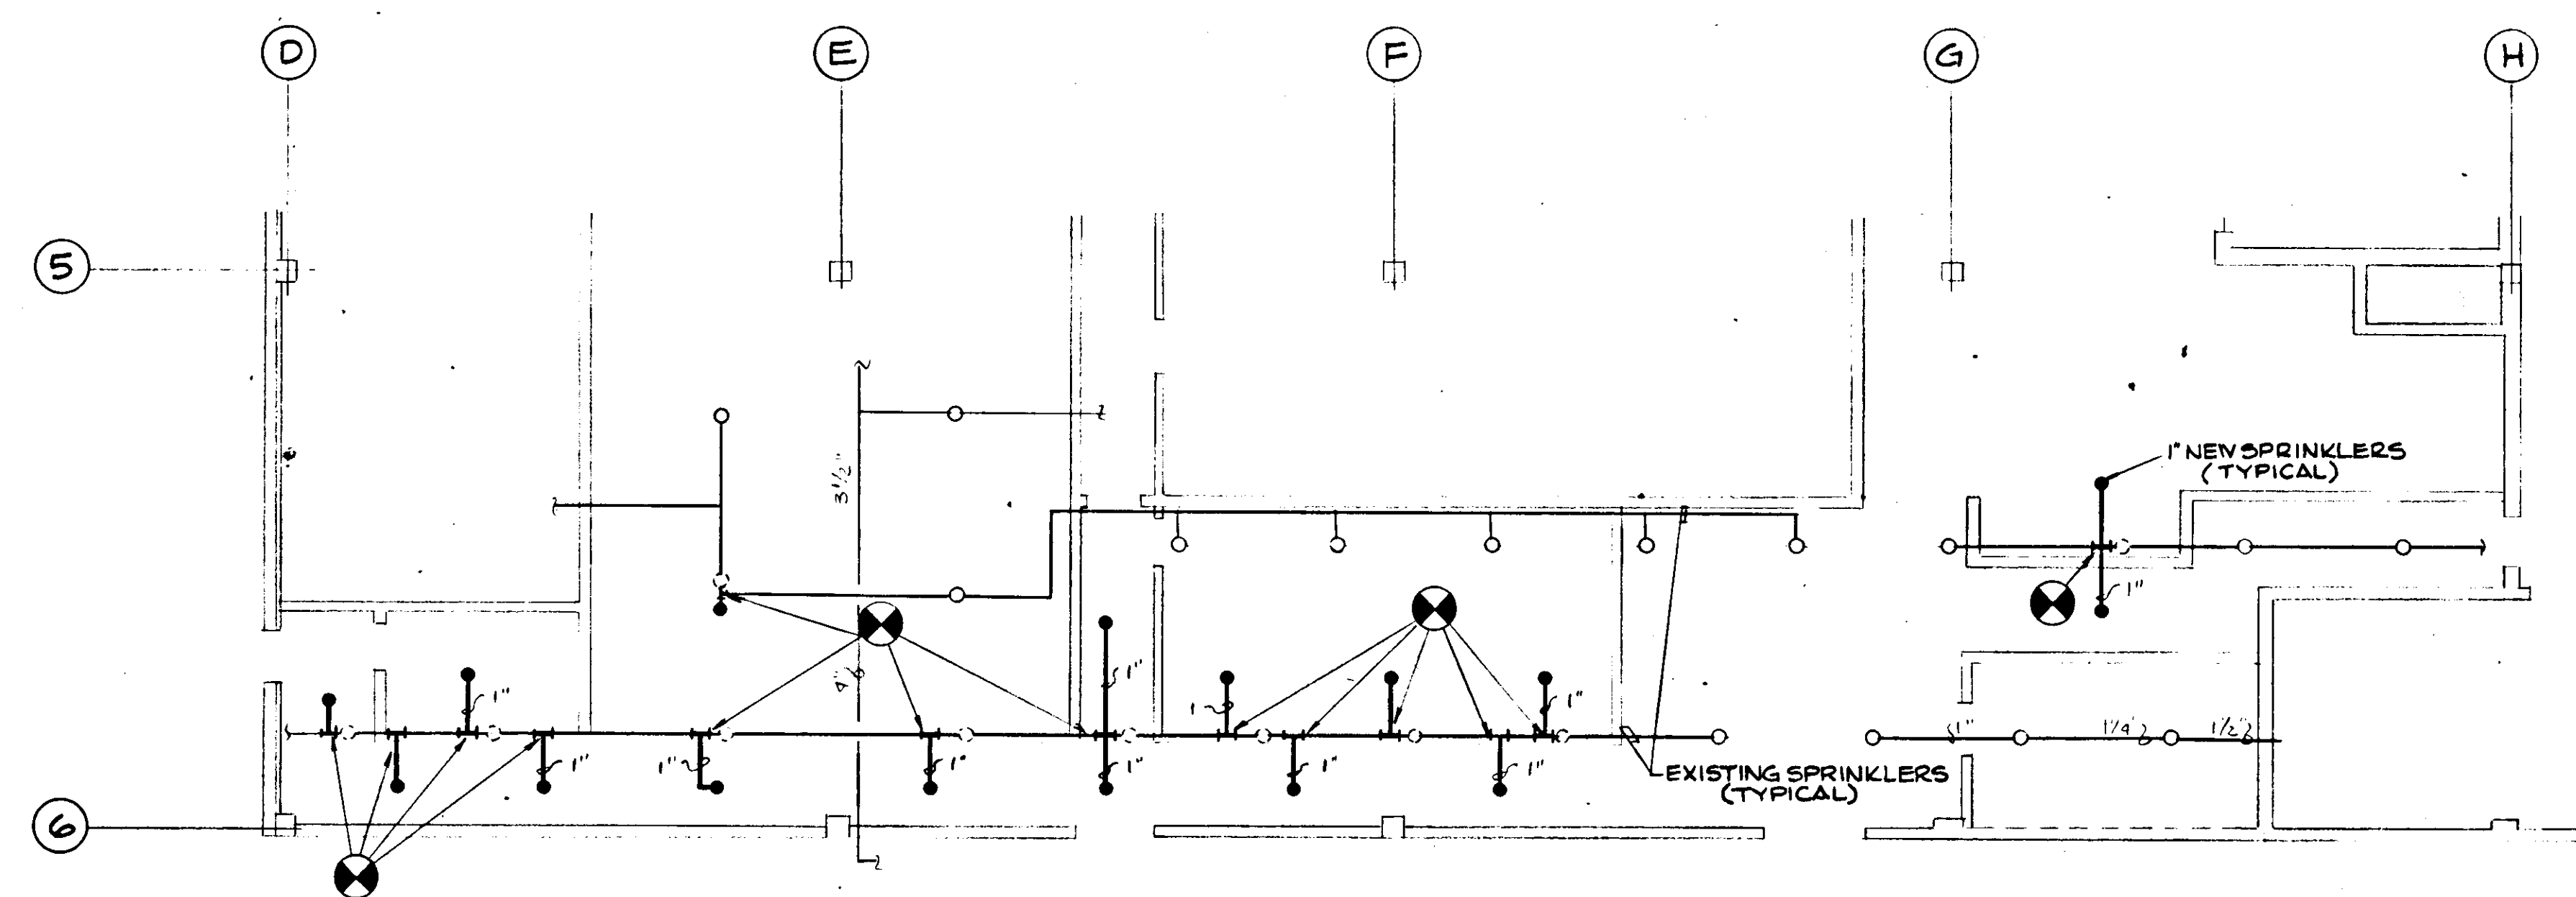

PARTIAL PLAN# 8 - SECOND FLOOR  
SCALE: 1/8" = 1'-0"

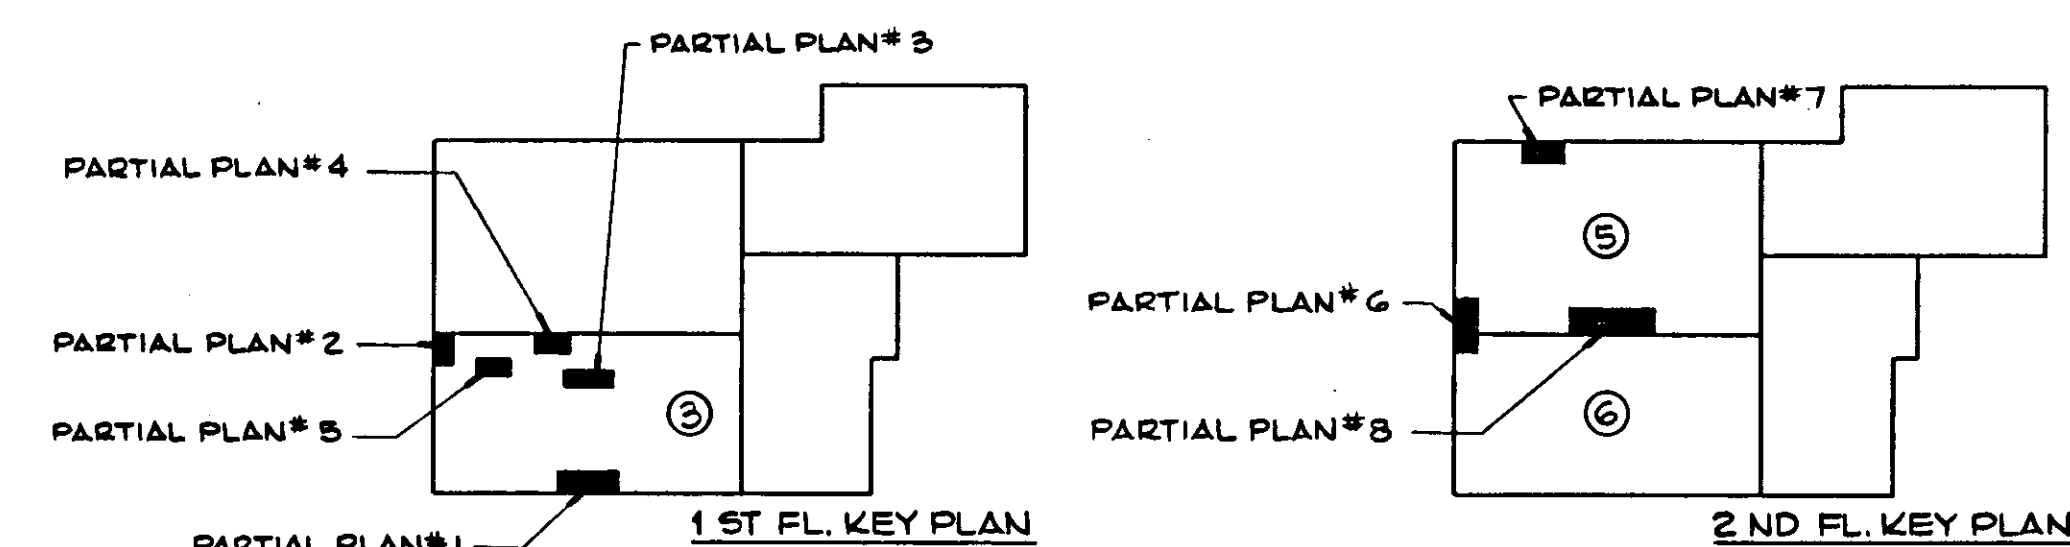

NOTES:  
1. SEE DWG. P-2 FOR GENERAL NOTES & SYMBOLS  
2. NEW DWG. P-3 - REVISION  $\Delta$

SHEET TITLE: PLUMBING - FIRST & SECOND FLOOR  
PARTIAL PLANS - SPRINKLER LAYOUTS

**SEARS**

SEARS, ROEBUCK AND CO.  
ALTERATIONS AND ADDITIONS TO  
RETAIL STORE  
SECURITY SQUARE, BALTIMORE, MD.

FEDCO SYSTEMS INC.  
10905 FT. WASHINGTON ROAD  
FORT WASHINGTON MARYLAND 20744  
292-3900 • 645-3337  
ARCHITECTS - ENGINEERS - PLANNERS - SURVEYORS



SHEET NO.

P - 3

ELECTRONIC CONTROL #  
R1634.119.P3

PROJECT NO.

| ISSUED | REVISIONS | DRAWN | CHECKED | DATE |
|--------|-----------|-------|---------|------|
|        | 1-14-85   |       |         |      |
|        | 2-26-85   |       |         |      |
|        | 5-8-85    |       |         |      |