



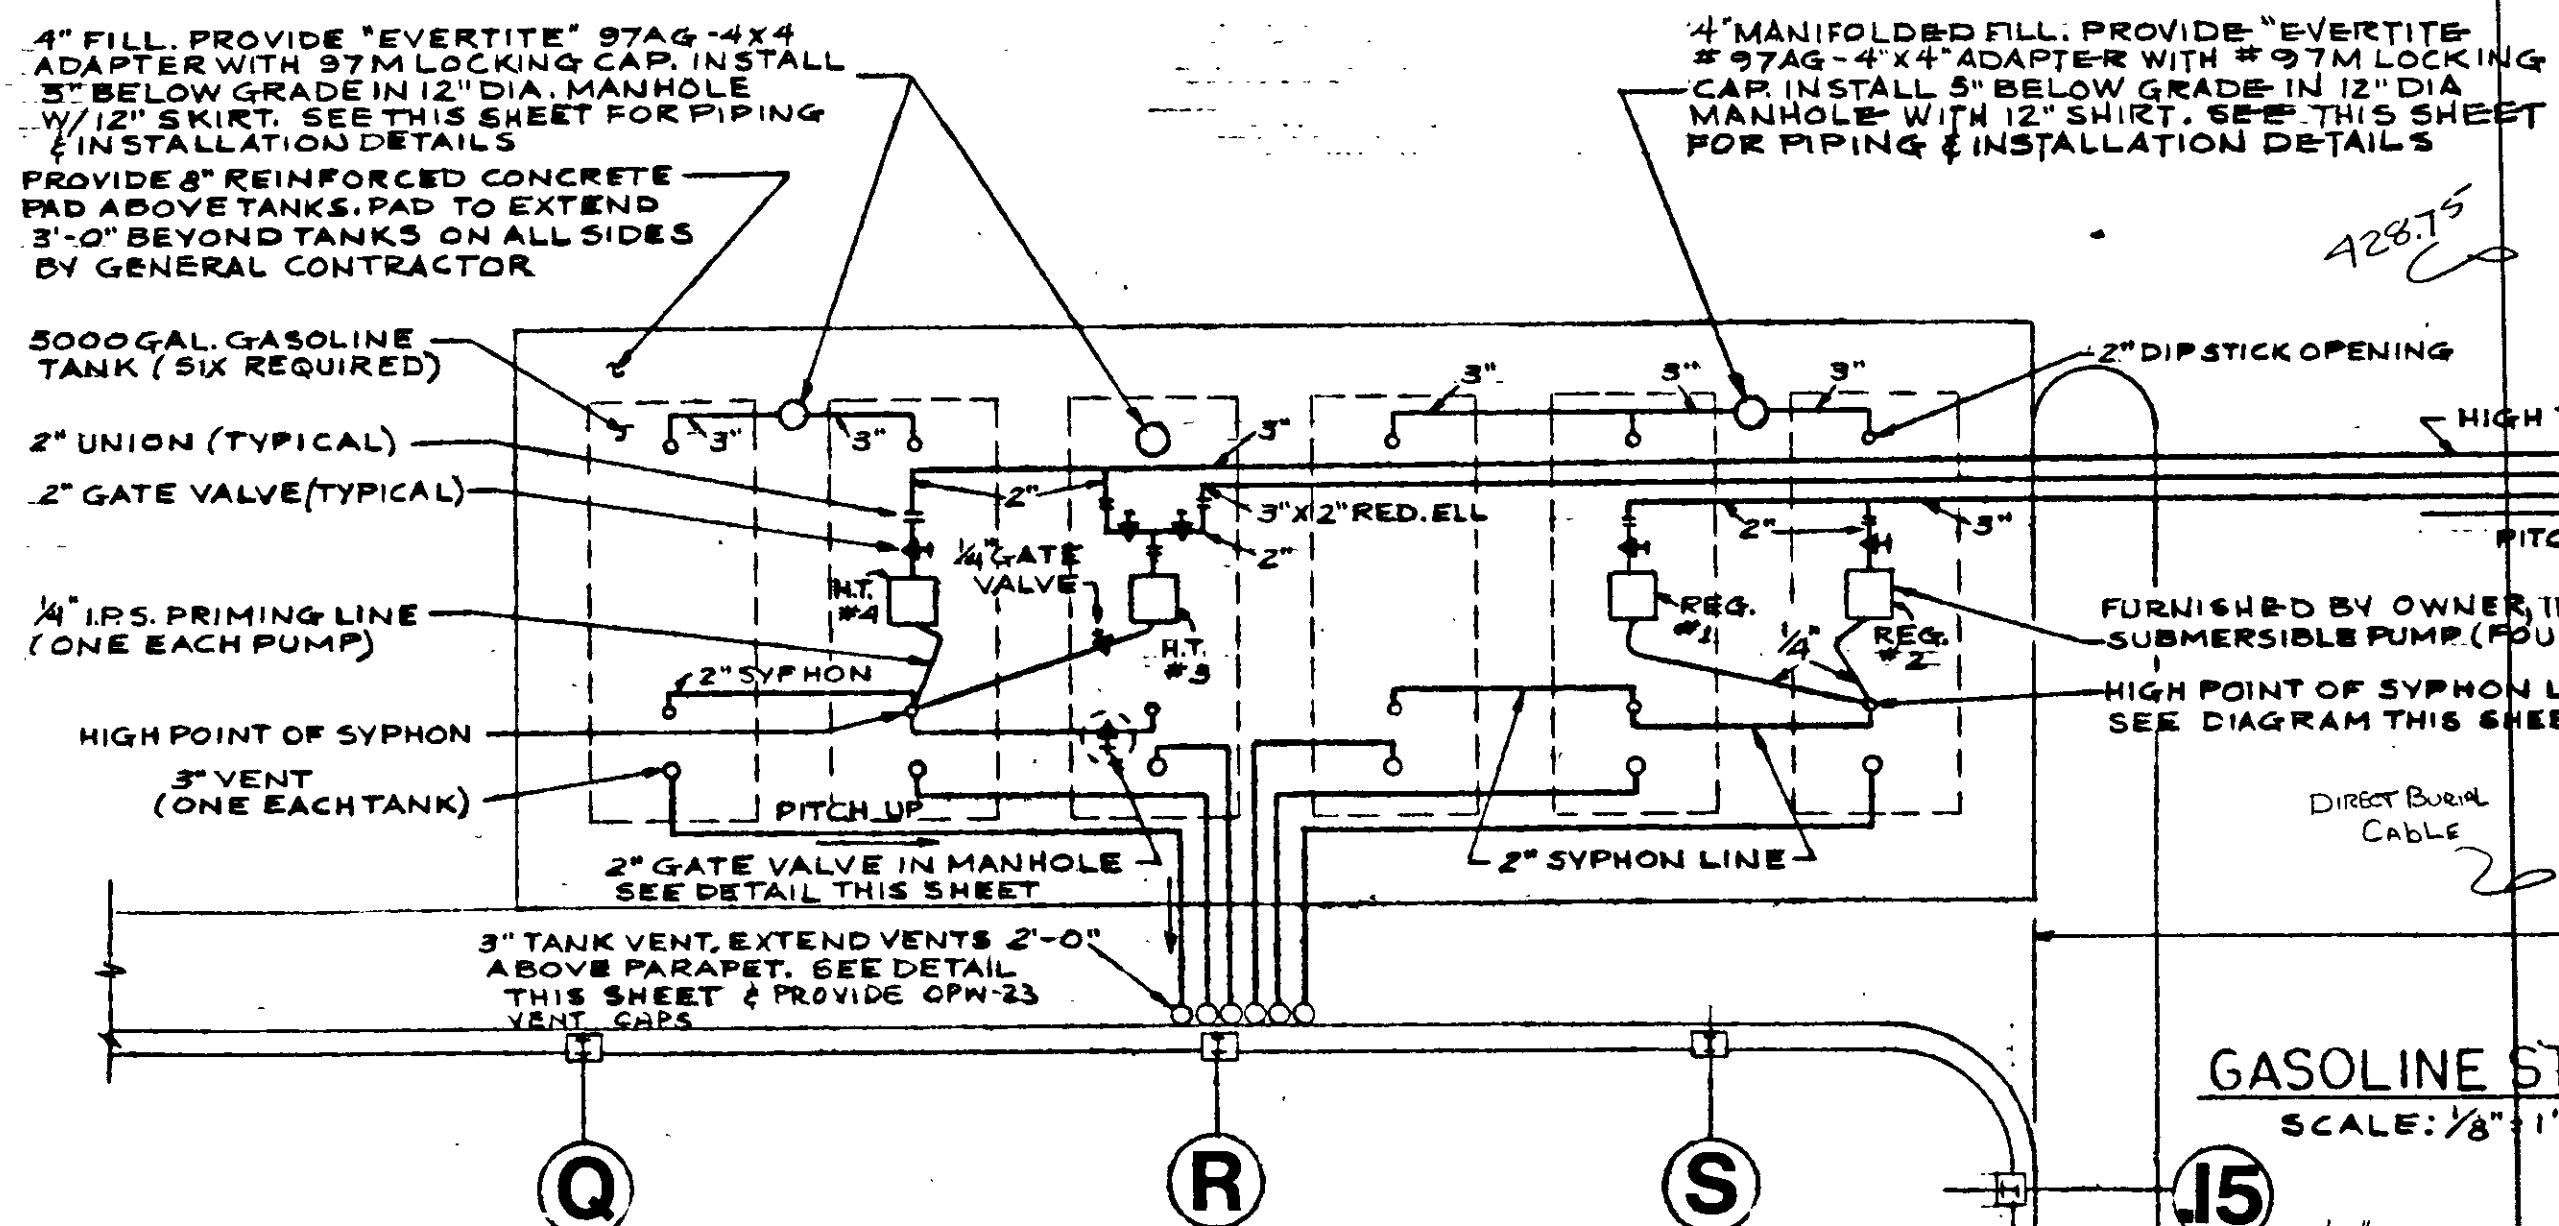


GASOLINE STORAGE TANK PIPING PLAN

SCALE: 1/8" = 1'-0"

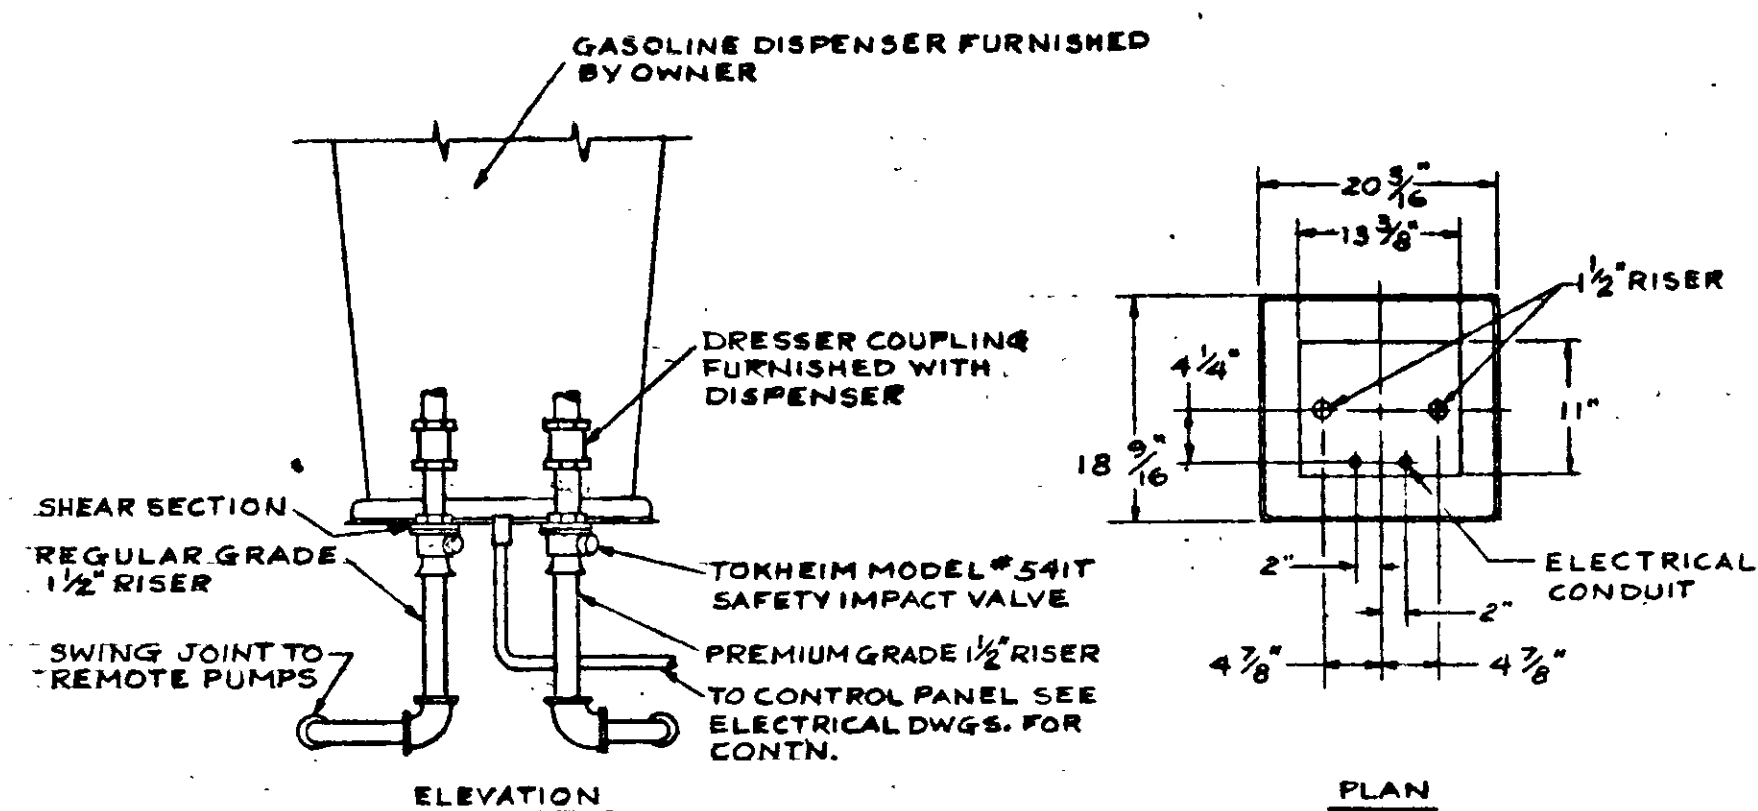


GASOLINE DISPENSER DETAIL

NO SCALE

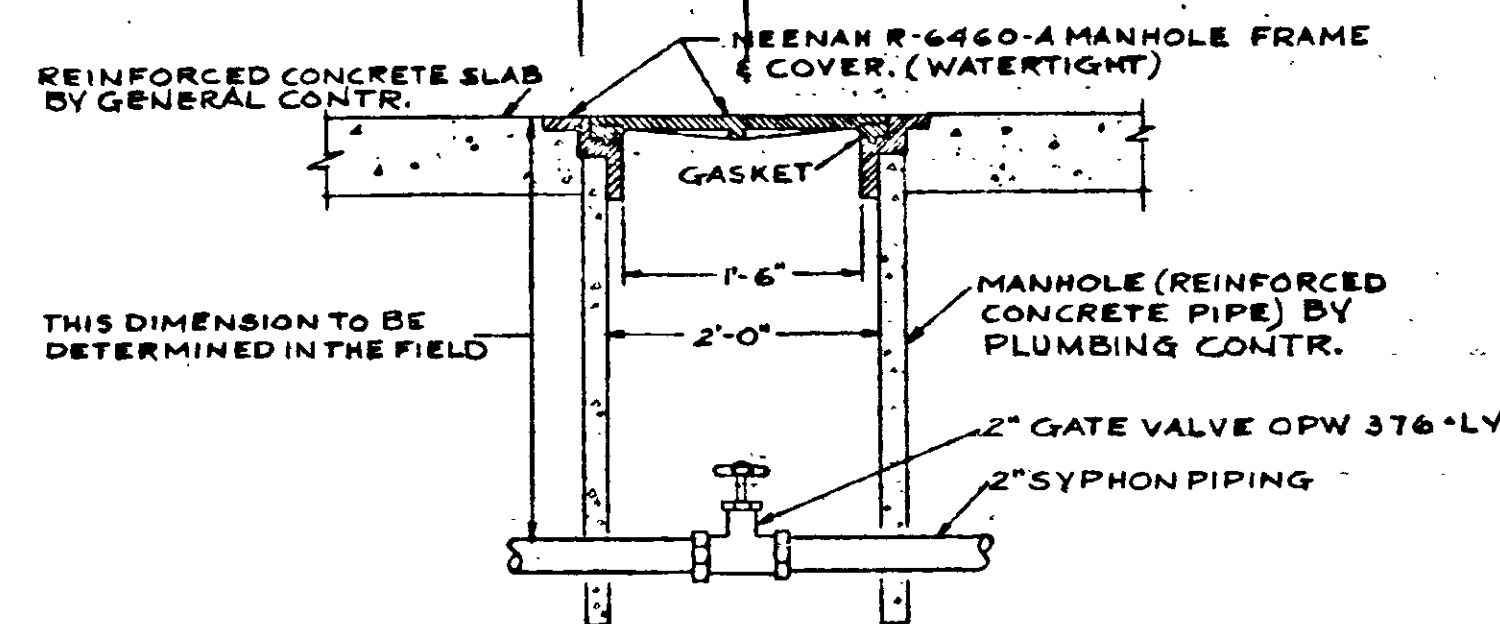


GASOLINE VALVE MANHOLE DETAIL

NO SCALE

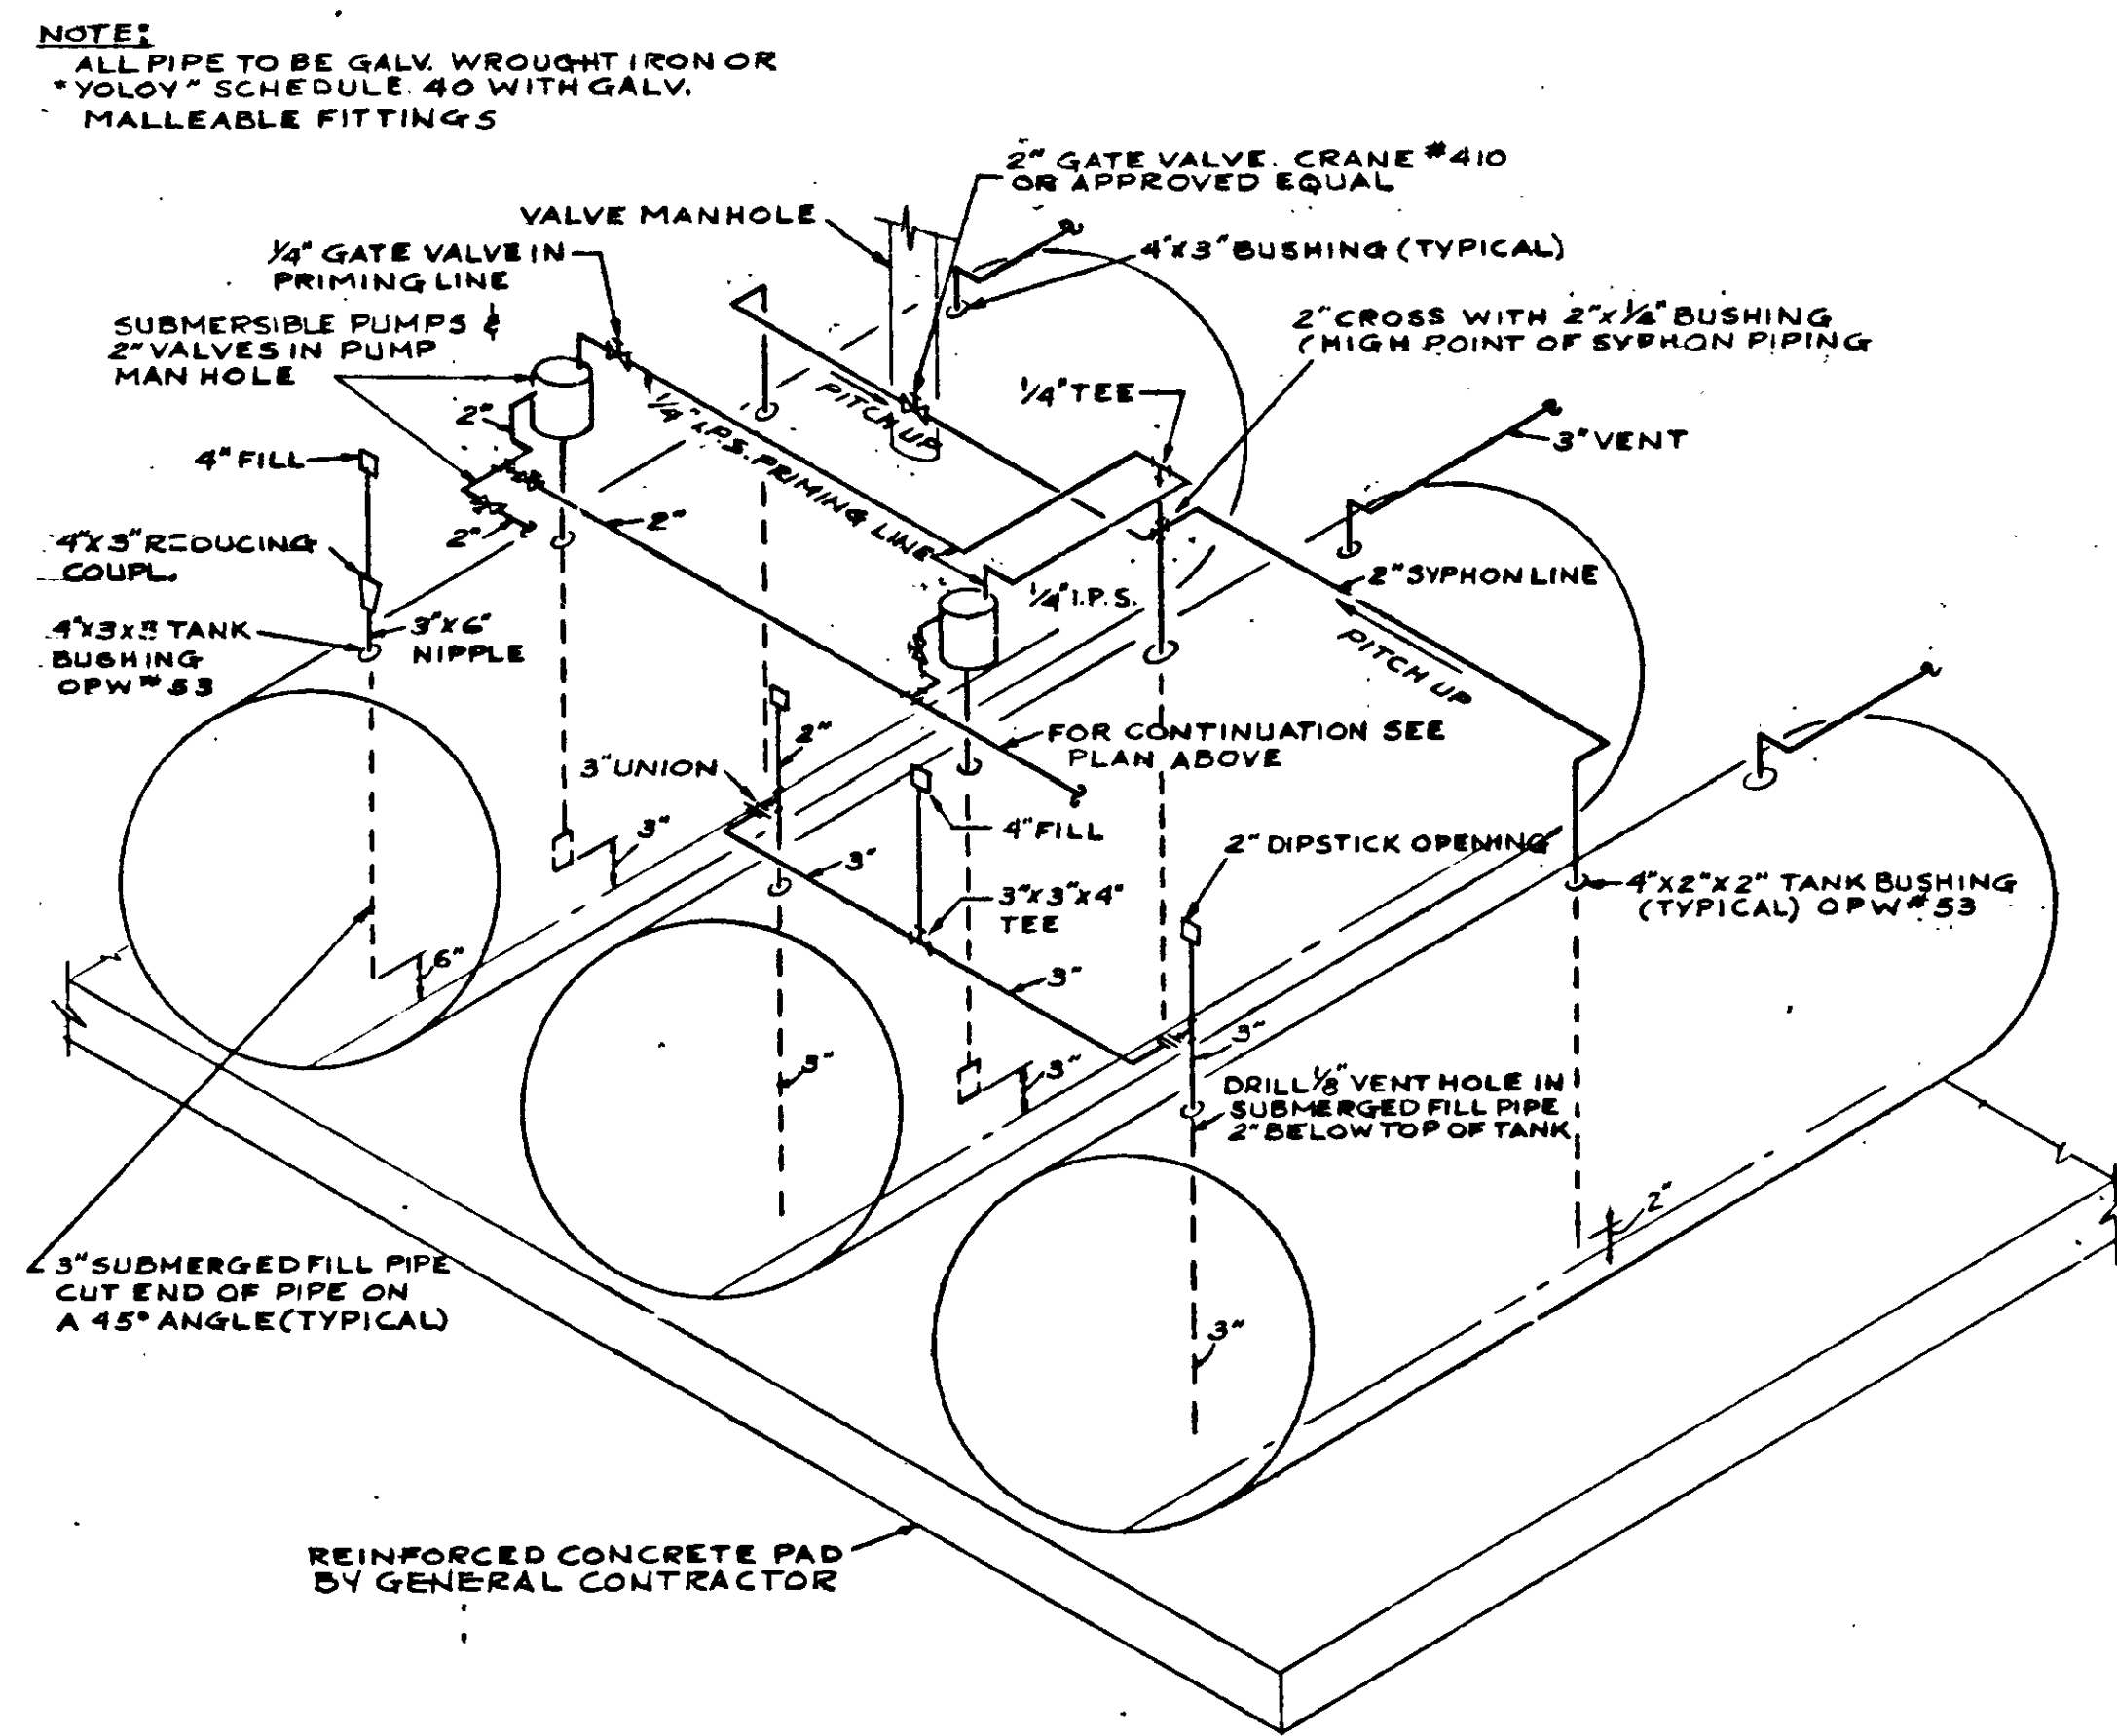


PREMIUM FUTURE GRADE GASOLINE PIPING DIAGRAM

NO SCALE

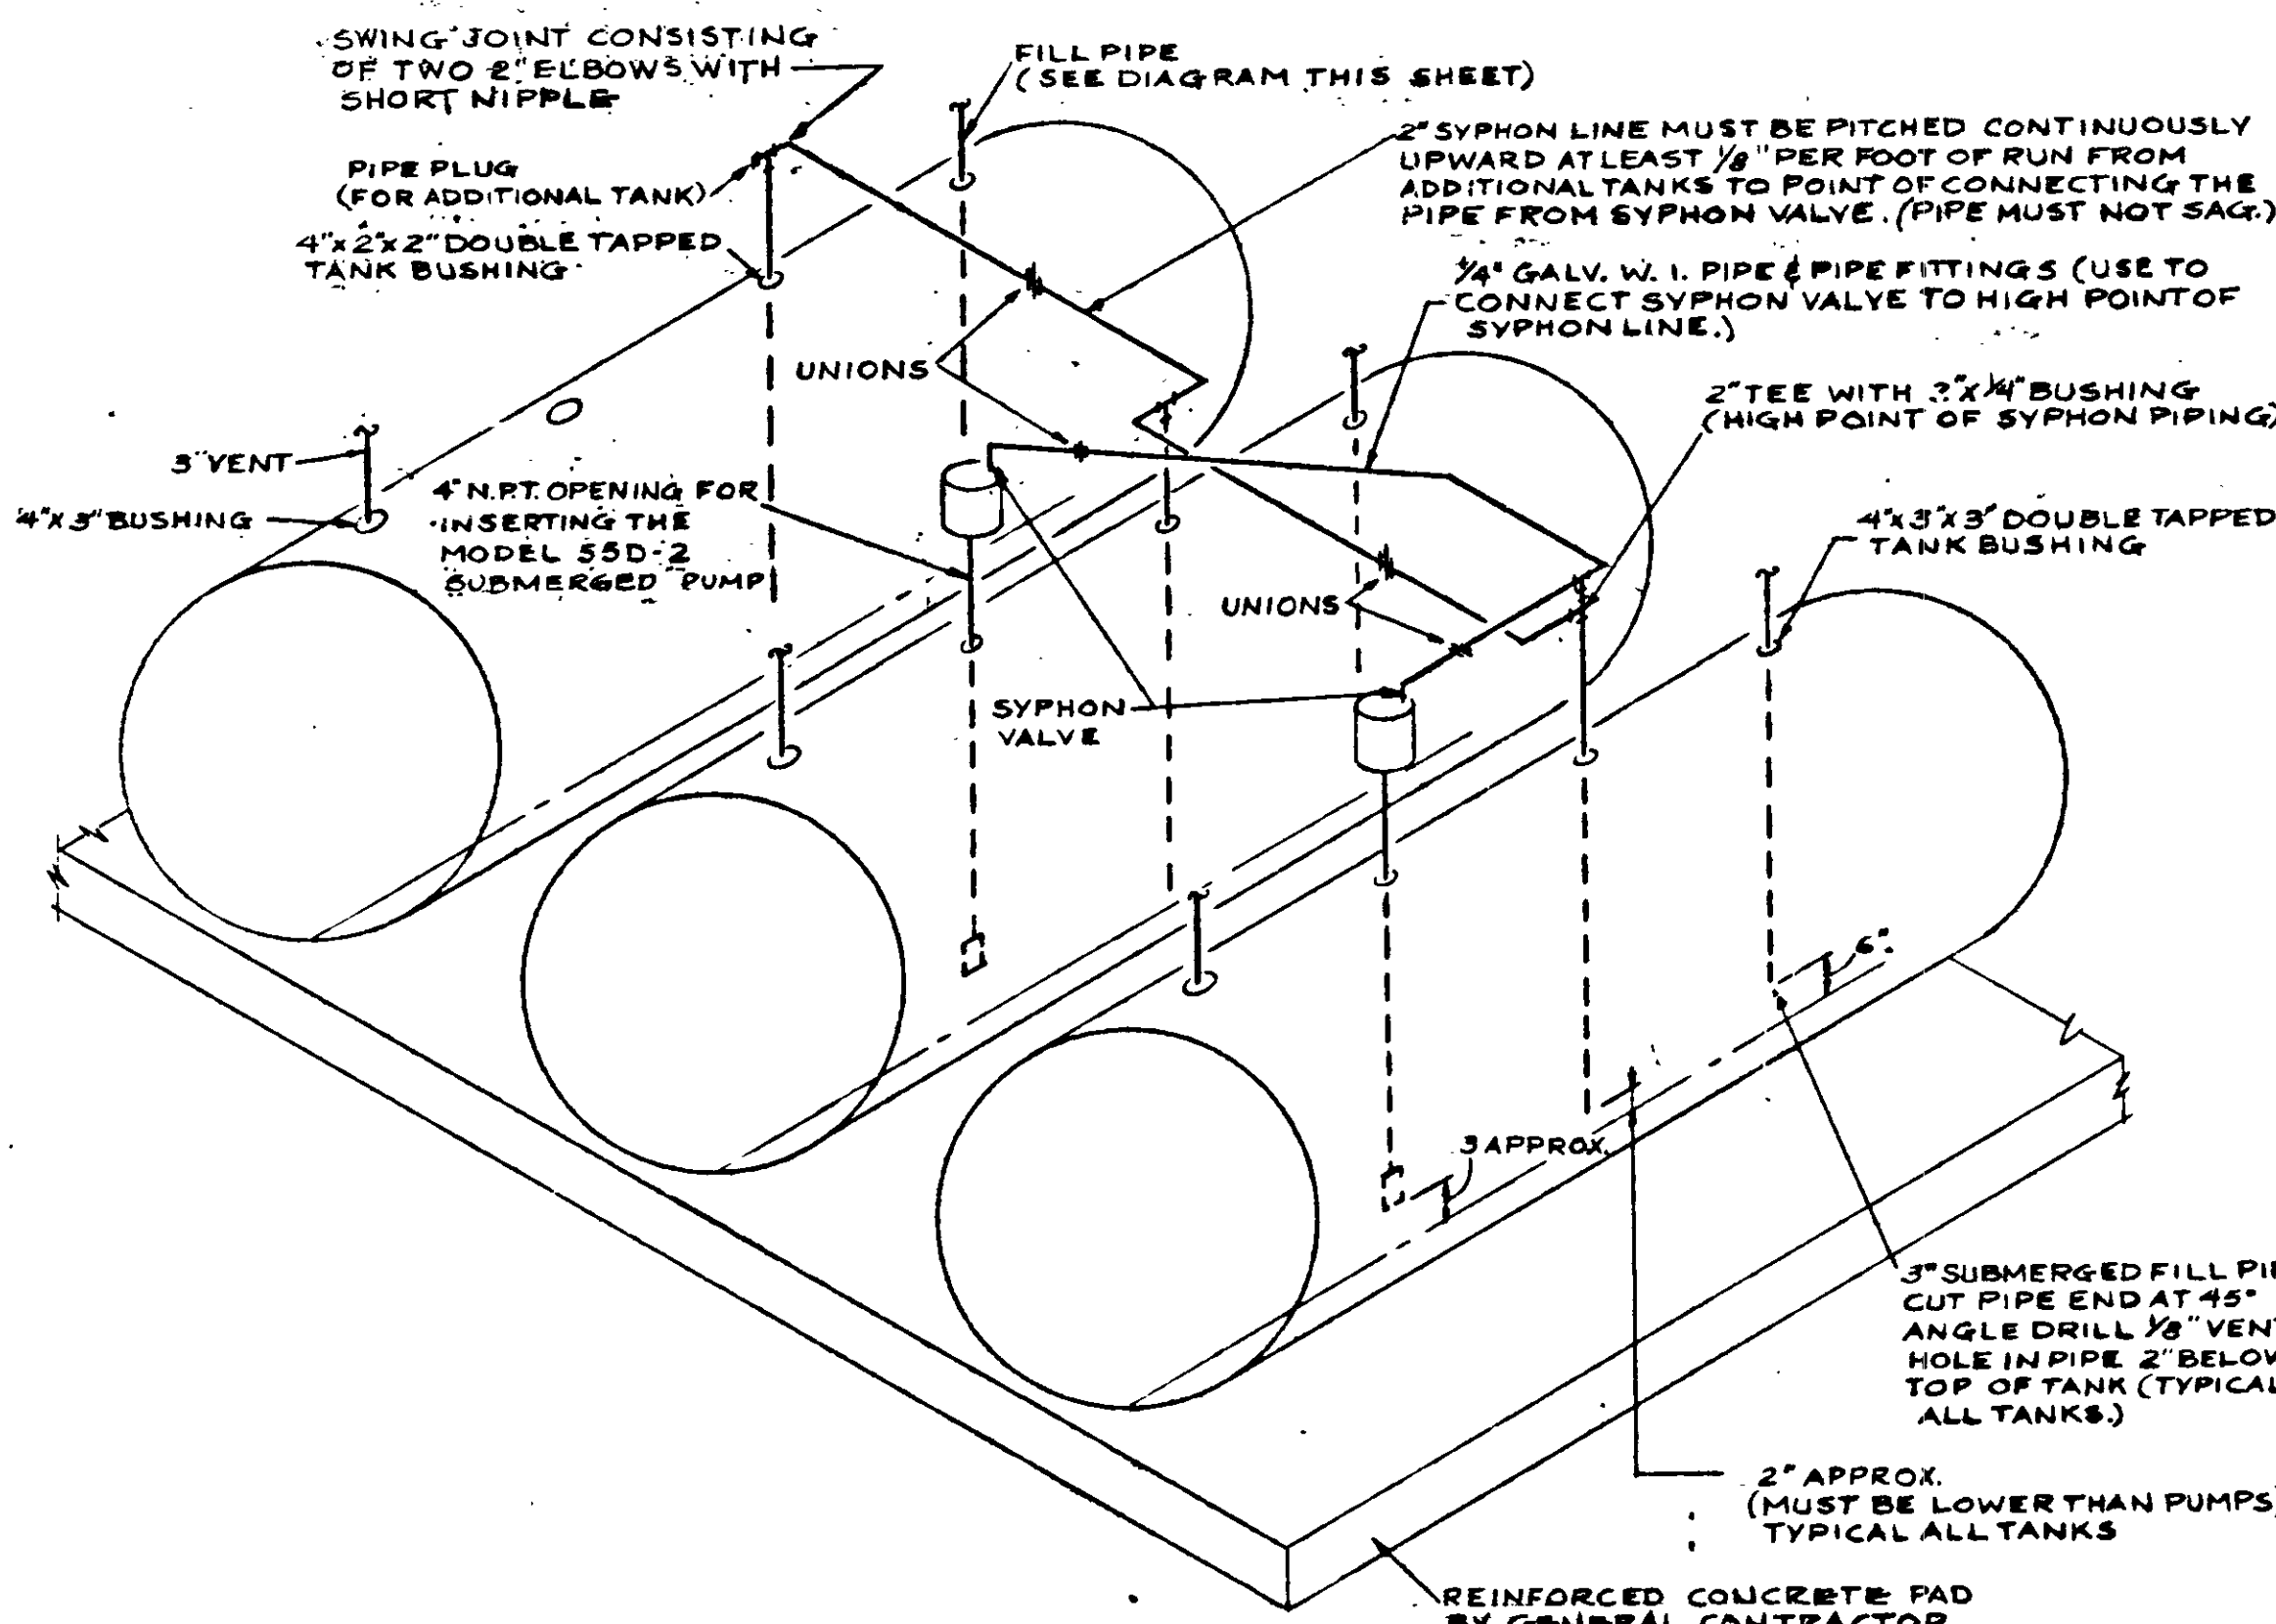


REGULAR GRADE GASOLINE PIPING DIAGRAM

NO SCALE

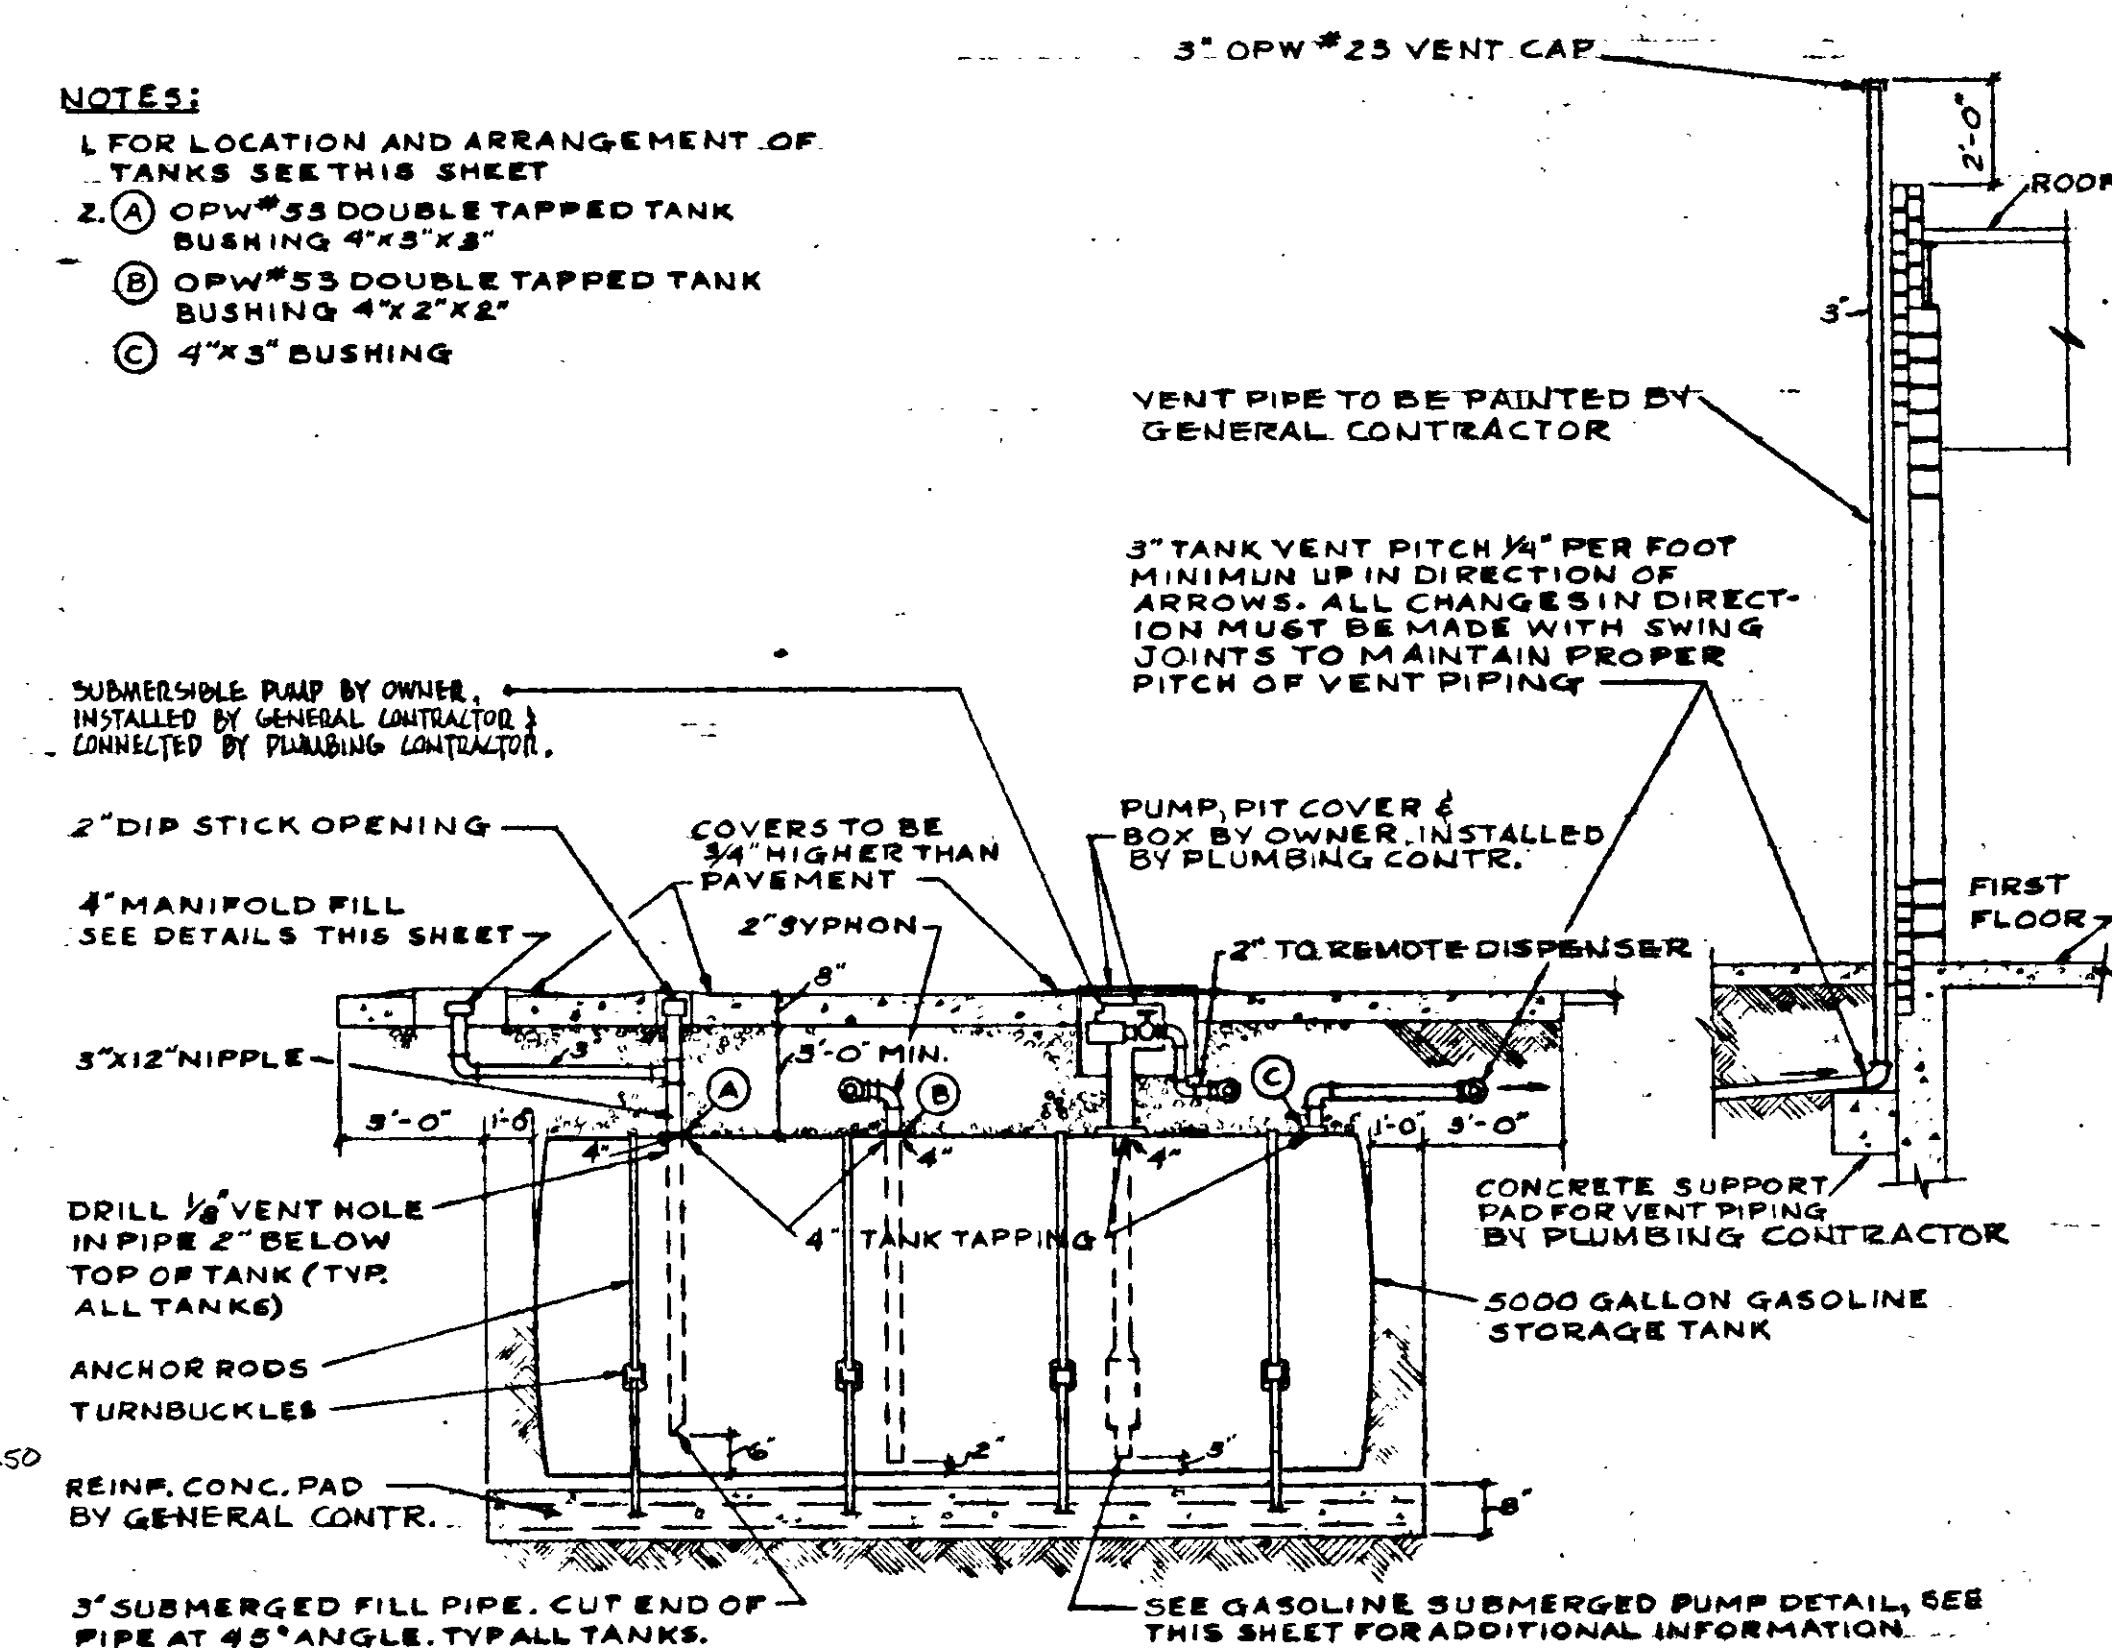


GASOLINE STORAGE TANK DETAIL

NO SCALE

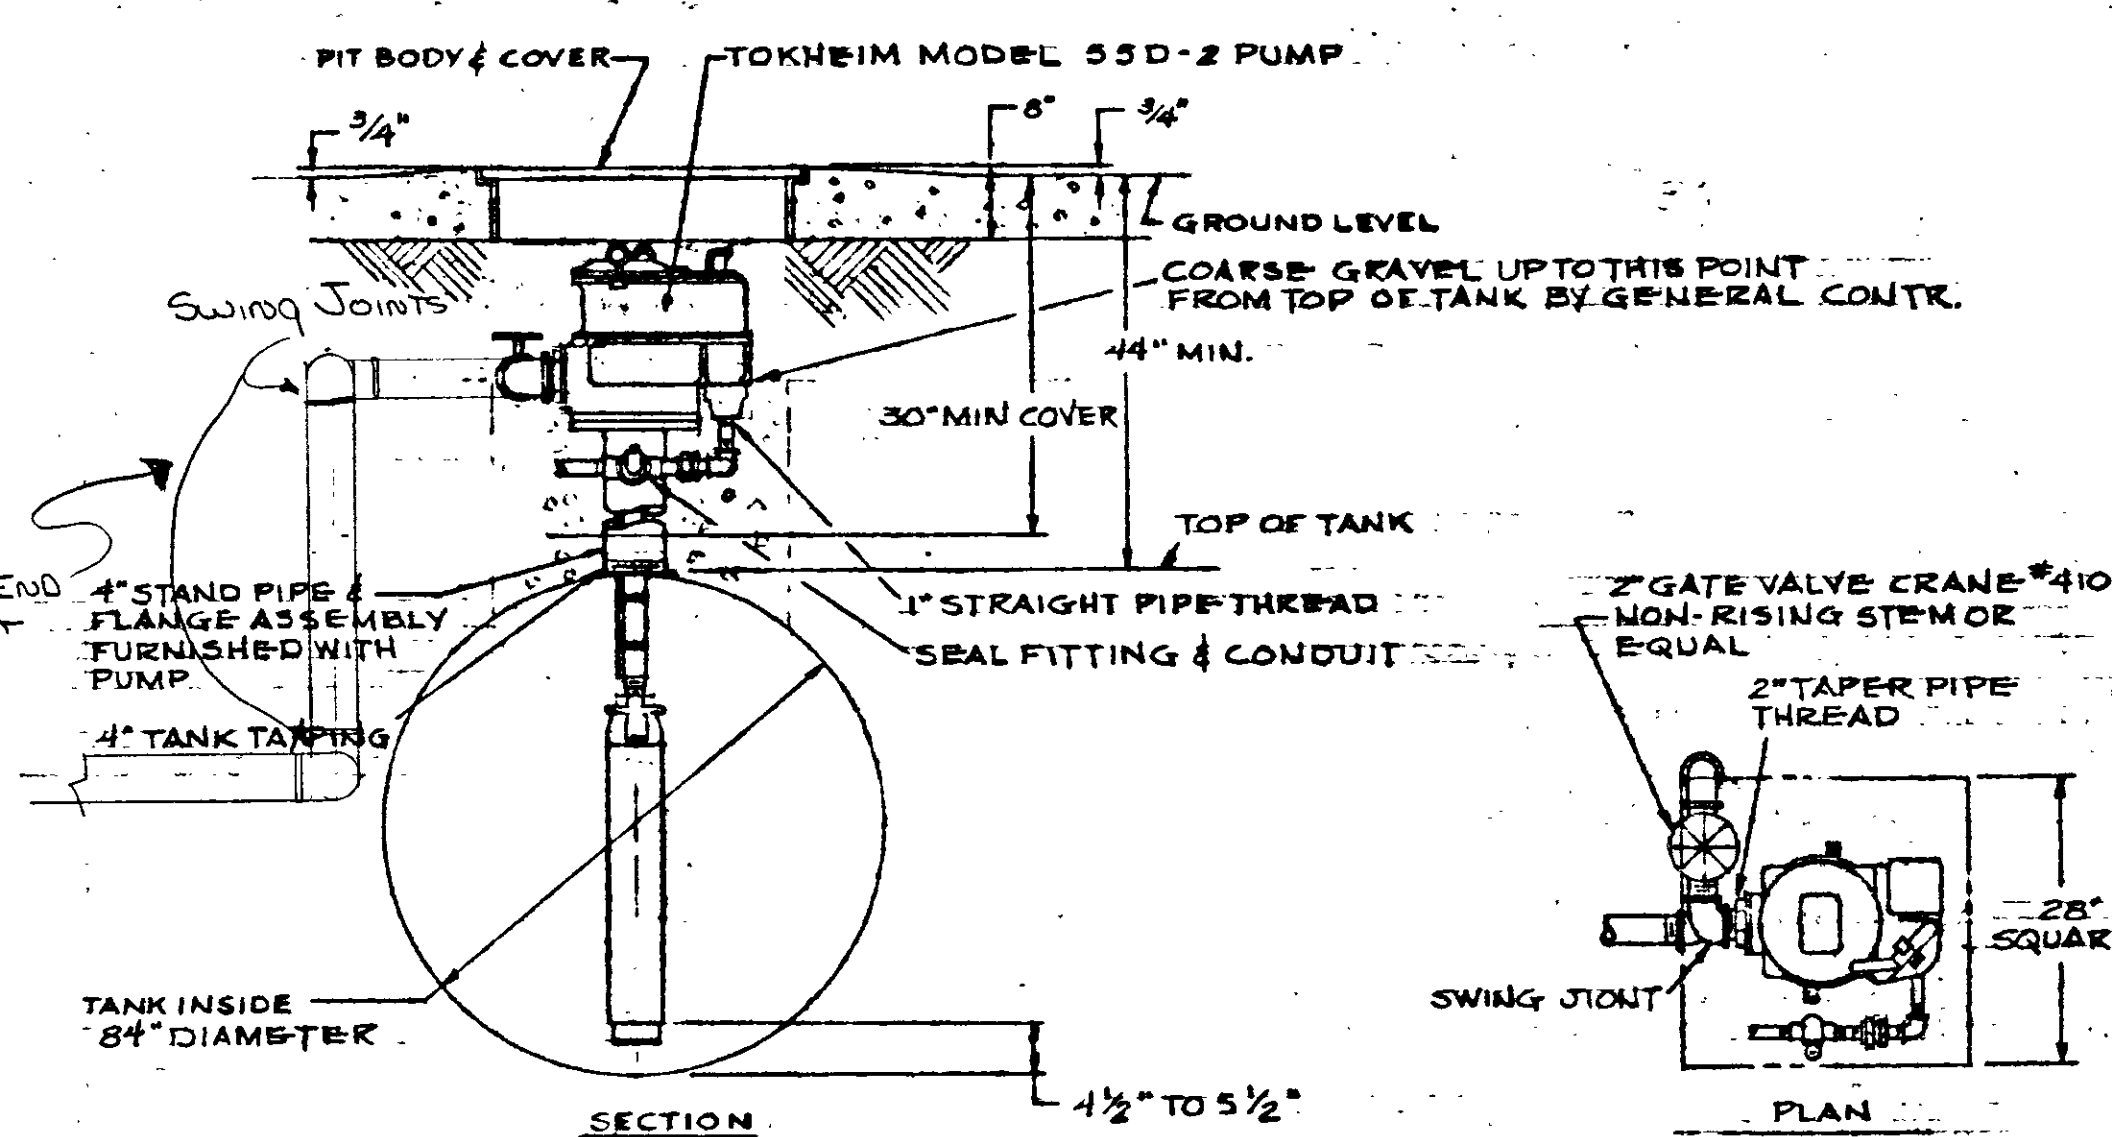

GASOLINE SUBMERGED PUMP DETAILS

NO SCALE

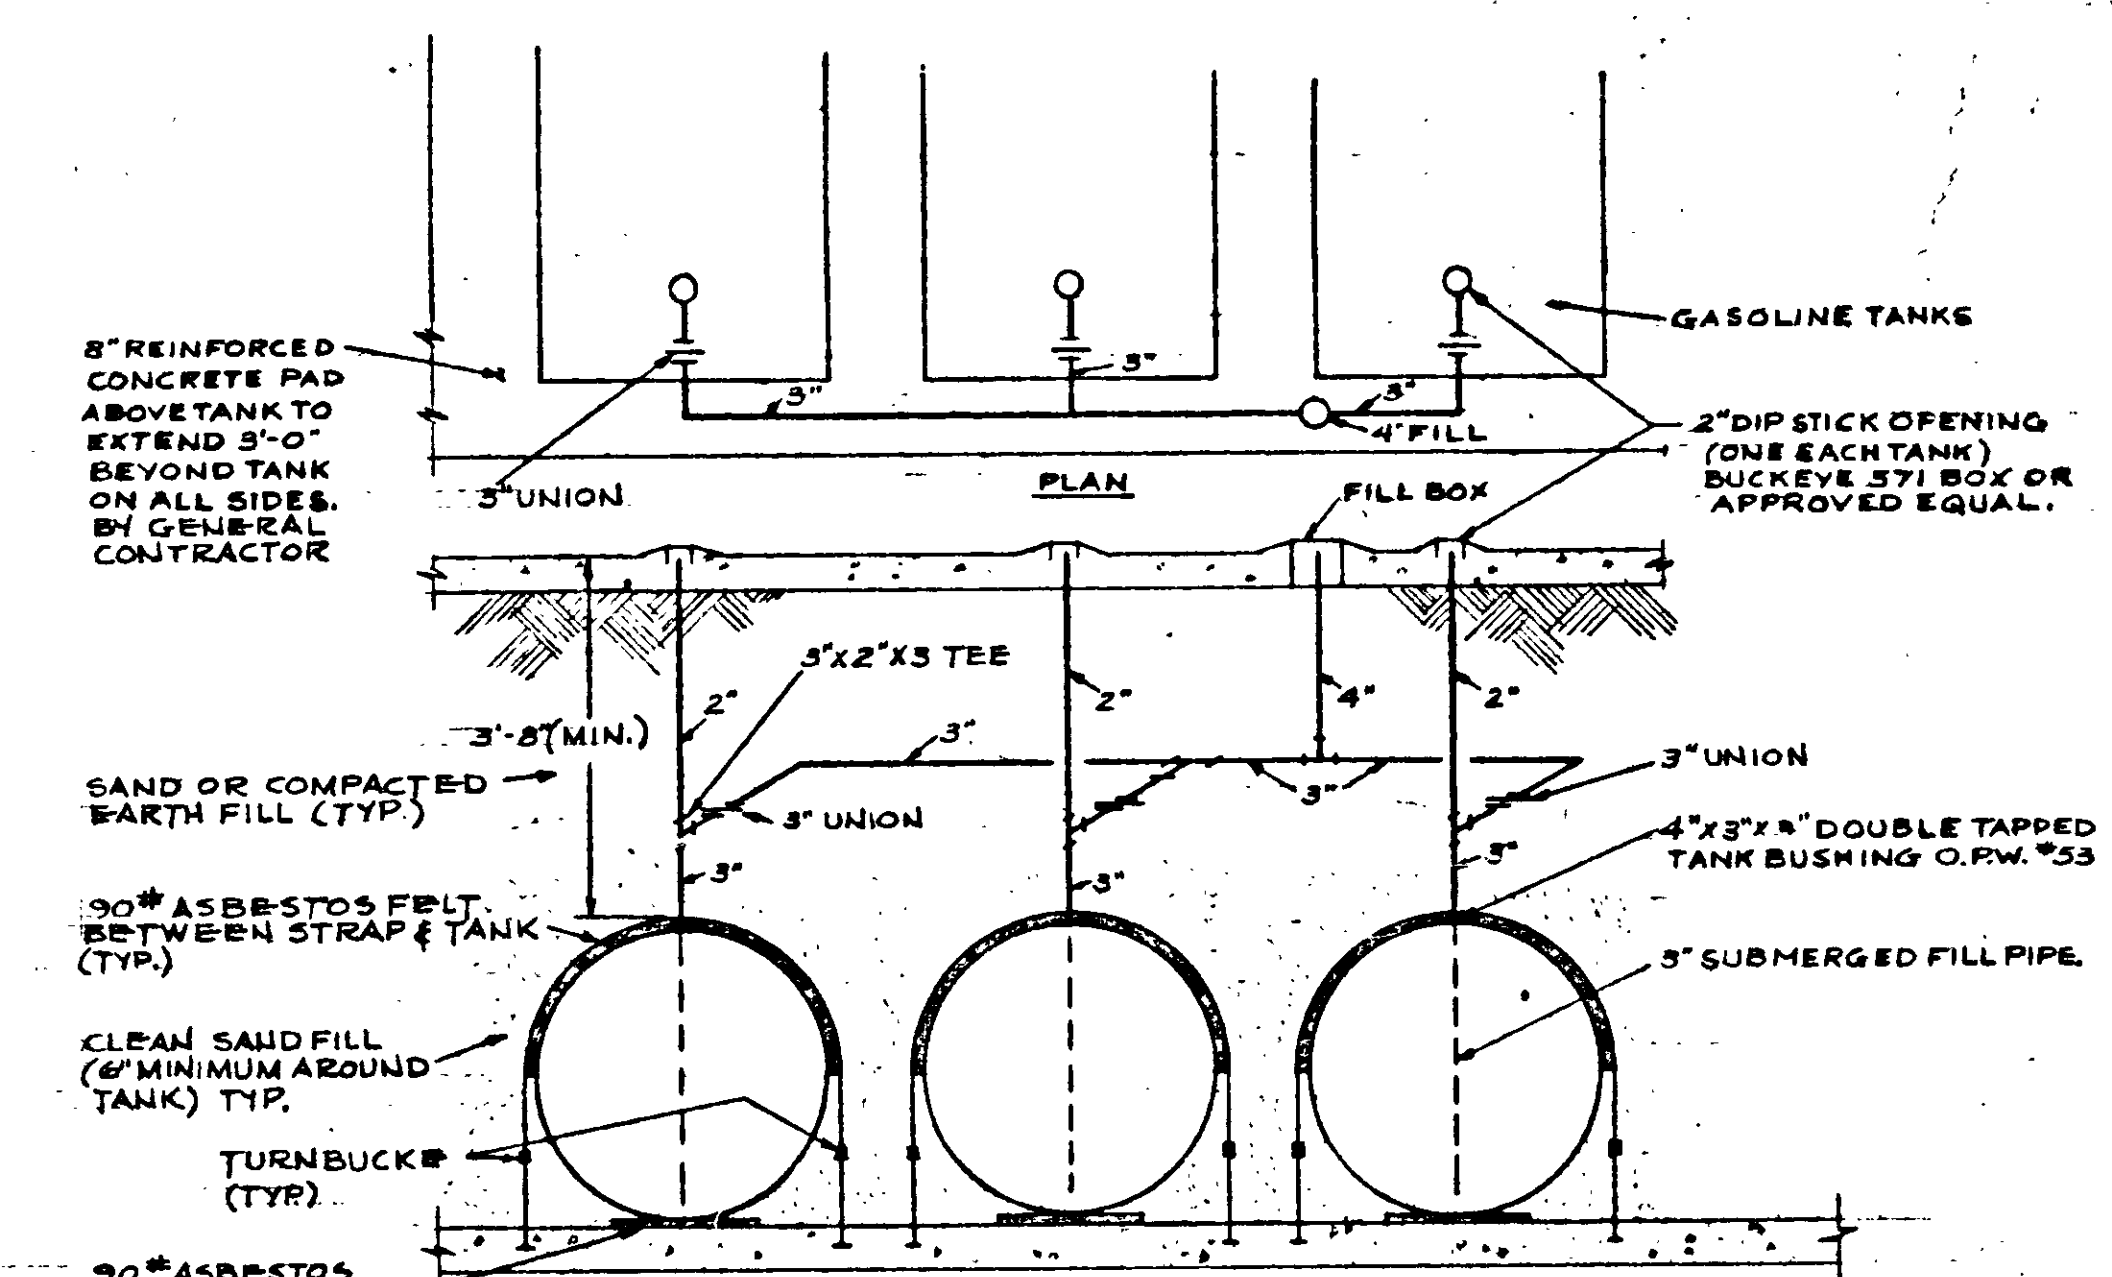

REGULAR GRADE MANIFOLDED GASOLINE FILL DETAIL

NO SCALE

ELECTRONIC CONTROL #
R1634-060 PB

ABM

ALLAN B. MITCHELL and ASSOCIATES ARCHITECTS PITTSBURGH, PA.

GASOLINE ISLAND & STORAGE TANKS PLAN & DETAILS
RETAIL STORE and 23 CAR AUTO SERVICE
SEARS, ROEBUCK & COMPANY
SECURITY SQUARE - BALTIMORE WEST, MARYLAND

SCALE AS NOTED

DATE AUGUST 16, 1971

REVISED

DRAWING NUMBER

P-8