


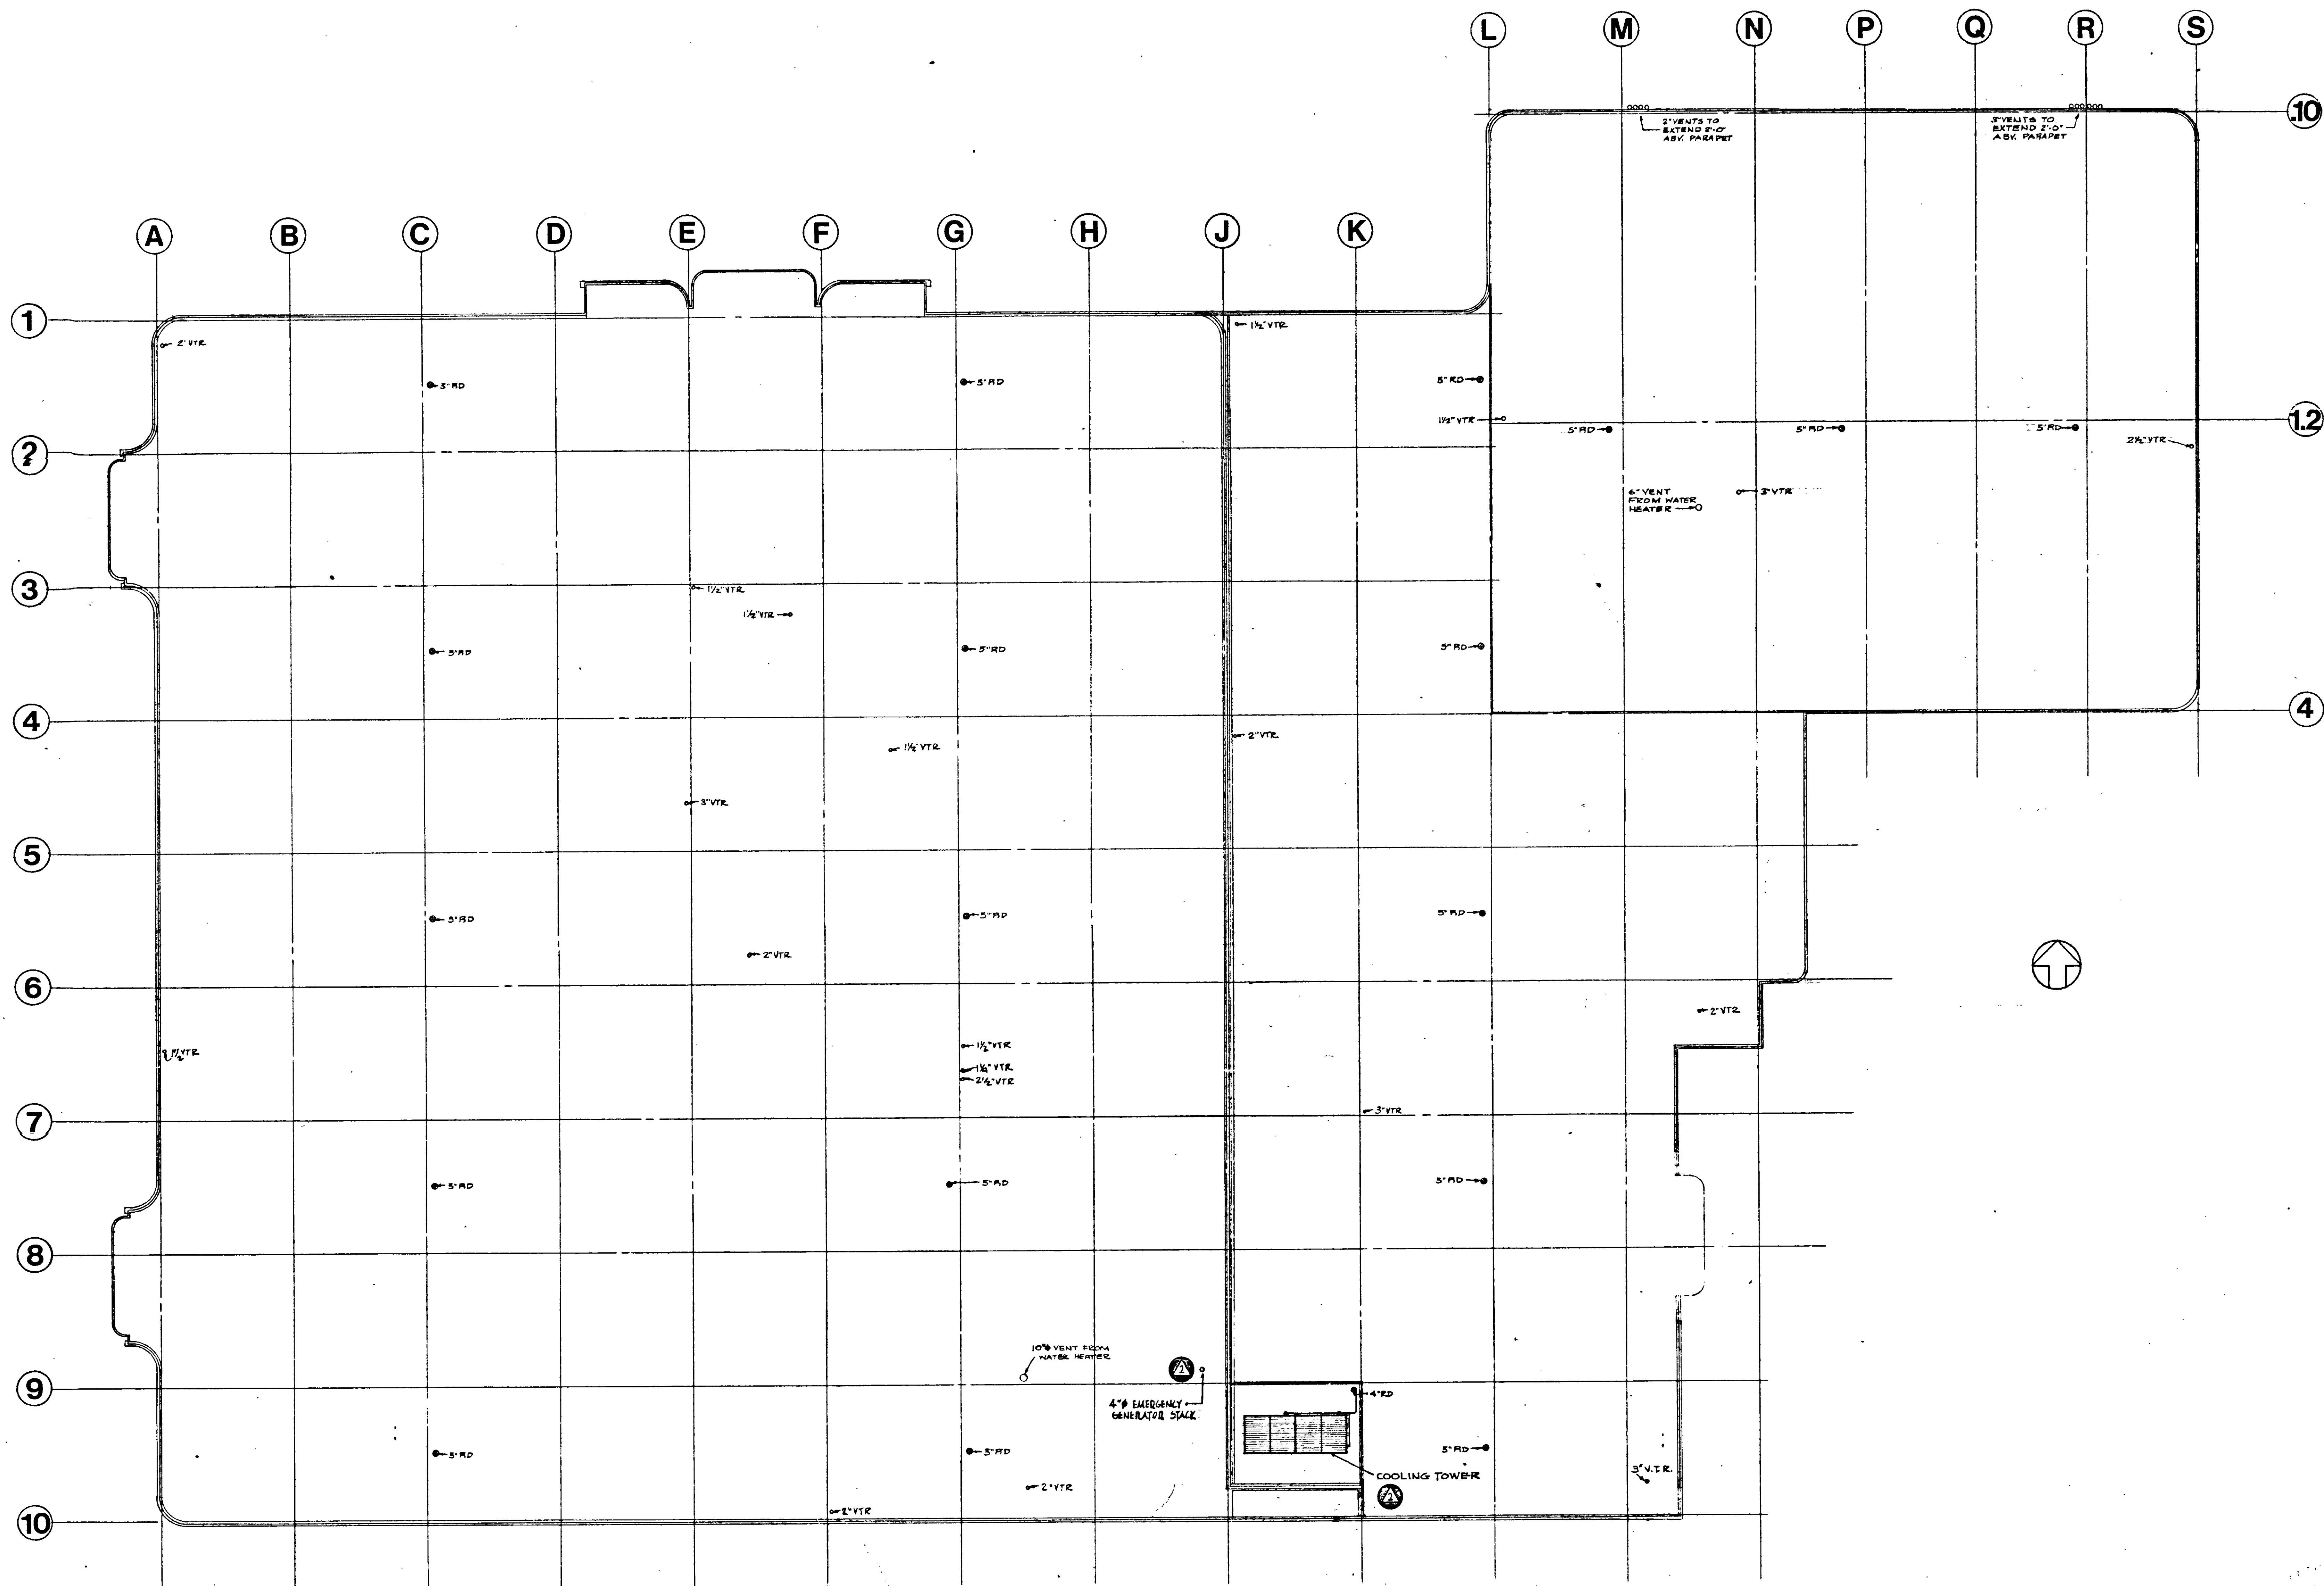

ELECTRONIC CONTROL #
R1634 061 P9

NOV. 1, 1971

Alban B. Mitchell
DATE AUGUST 16, 1971
REVISED

ABM

ALLAN B. MITCHELL and ASSOCIATES ARCHITECTS PITTSBURGH, PA.

ROOF PLAN
RETAIL STORE and 23 CAR AUTO SERVICE
SEARS, ROEBUCK & COMPANY
SECURITY SQUARE - BALTIMORE WEST, MARYLAND

SCALE 1/16" = 1'-0"
DATE AUGUST 16, 1971
REVISED

DRAWING NUMBER
P-9